



CITY OF OROVILLE
BUTTE COUNTY, CALIFORNIA

PLANS FOR CONSTRUCTION OF
COUNTY HOSPITAL SEWERAGE FACILITIES

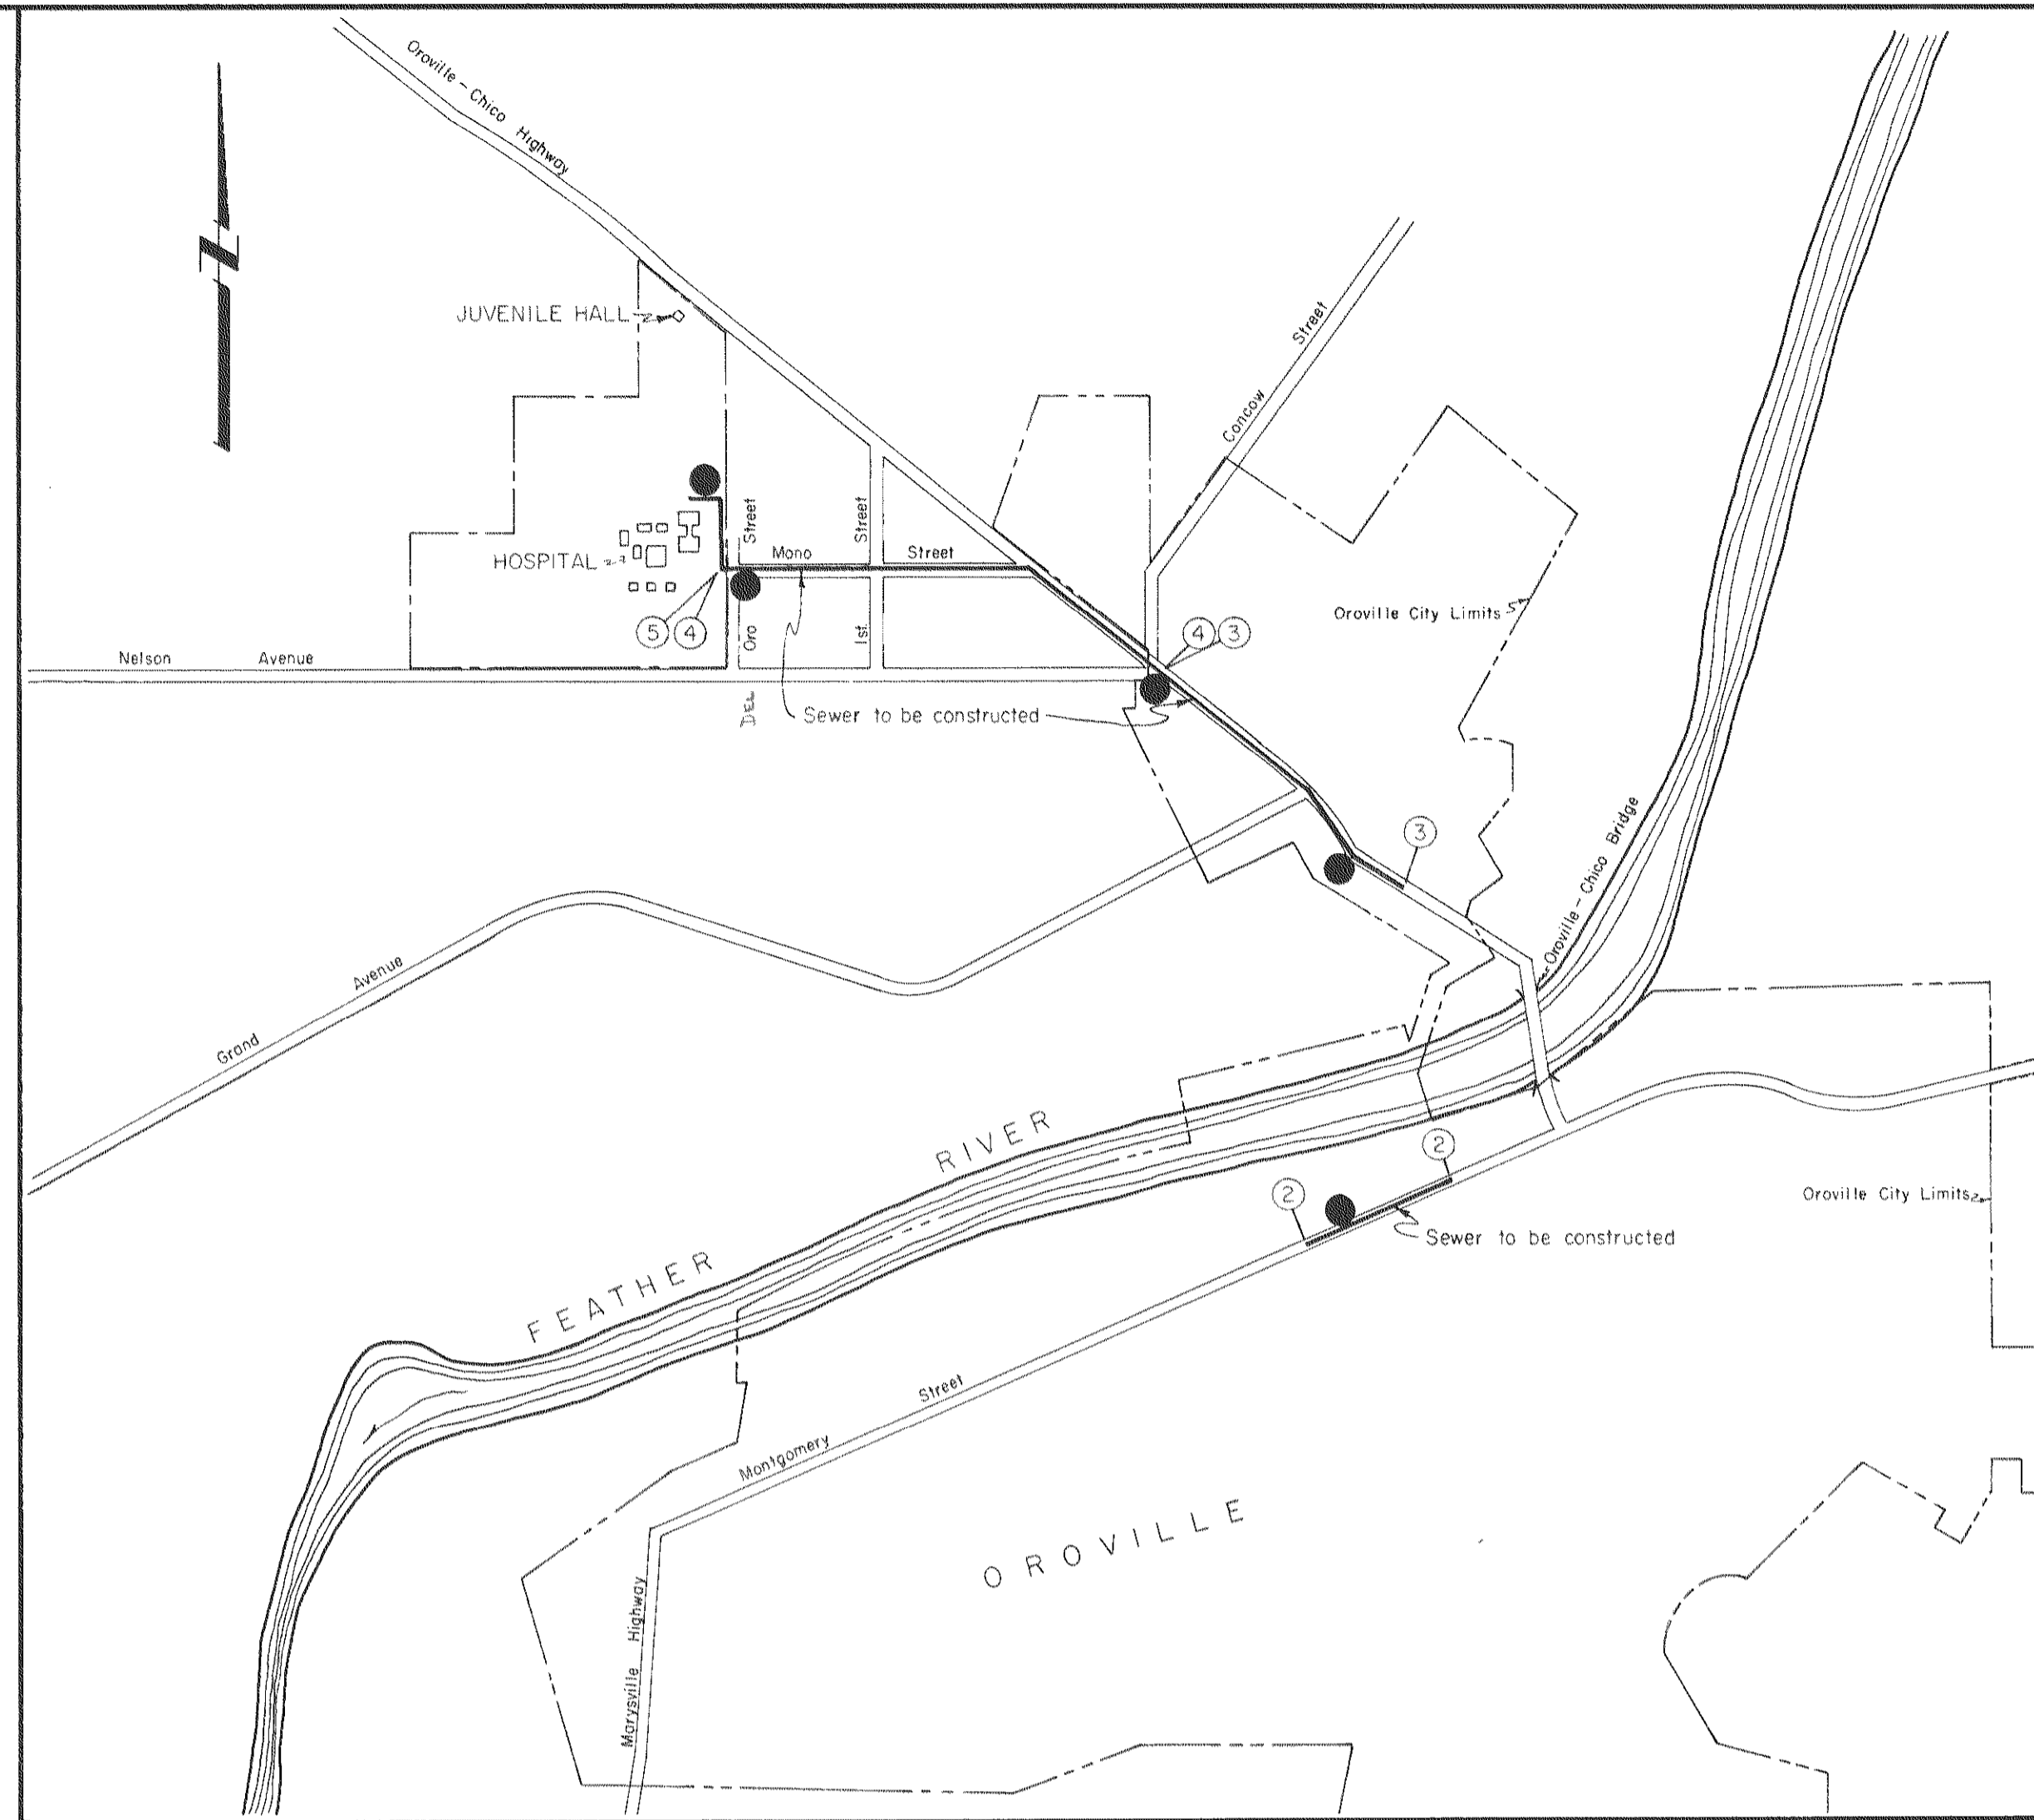

GENERAL MAP

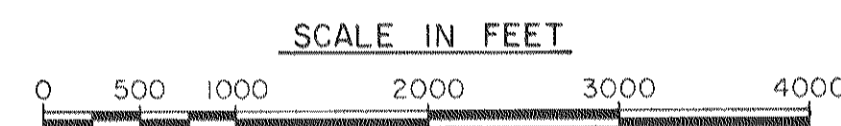

Adopted by City Council of City of Oroville

Approved by County of Butte

[Signature]
Director of Public Works R.C.E. No. 6696

[Signature]
Chairman, Board of Supervisors

INDEX TO SHEETS

SHEET NO.	TITLE
1	INDEX AND GENERAL MAP
2	PLAN & PROFILE SEWER LINE
3	PLAN & PROFILE SEWER LINE
4	PLAN & PROFILE SEWER LINE
5	PLAN & PROFILE SEWER LINE
6	PUMPING STATION MECHANICAL & ELECTRICAL - DELETED
7	MISCELLANEOUS DETAILS
8	LOG OF TEST BORINGS

LEGEND

	MANHOLE	Manhole & line to be constructed
	SEWER	Existing sewer
		Water line
		Gas line
		Edge of pavement
		R/W line
		Telephone line
		Power line
		Fence
		Water valve
		Culvert
		Drop inlet
		Power pole
		Tree
	D.I.	Drop inlet
	E.P.	Edge of pavement
	C.I.	Cast iron
	A.C.	Asbestos cement
	V.C.	Vitrified clay

NOTES

- ③ Denotes sheets on which Plan and Profiles are shown.
- Depth to underground utilities shown in profile are approx. only unless elevation indicated.
- All manholes to be set flush with finished grade unless otherwise noted.
- All stubs to be V.C. size as noted, one section long. Provide stopper with lime mortar or plastisol joint.
- Denotes location of test hole - See sheet 8 for logs. Location also shown on plan and profile sheets.

CITY OF OROVILLE
BUTTE COUNTY, CALIFORNIA
COUNTY HOSPITAL SEWERAGE FACILITIES
INDEX AND GENERAL MAP

DEWANTE AND STOWELL
SANITARY AND CIVIL ENGINEERS - SACRAMENTO, CALIFORNIA

DRAWN: L.R.K.	SUBMITTED: <i>[Signature]</i>	SHEET NO. 1
CHECKED: R.H.D.	APPROVED: <i>[Signature]</i>	OF 8
DATE: March 1960		