



E 138,000
E 139,000
E 140,000
E 138,000
E 139,000
E 140,000

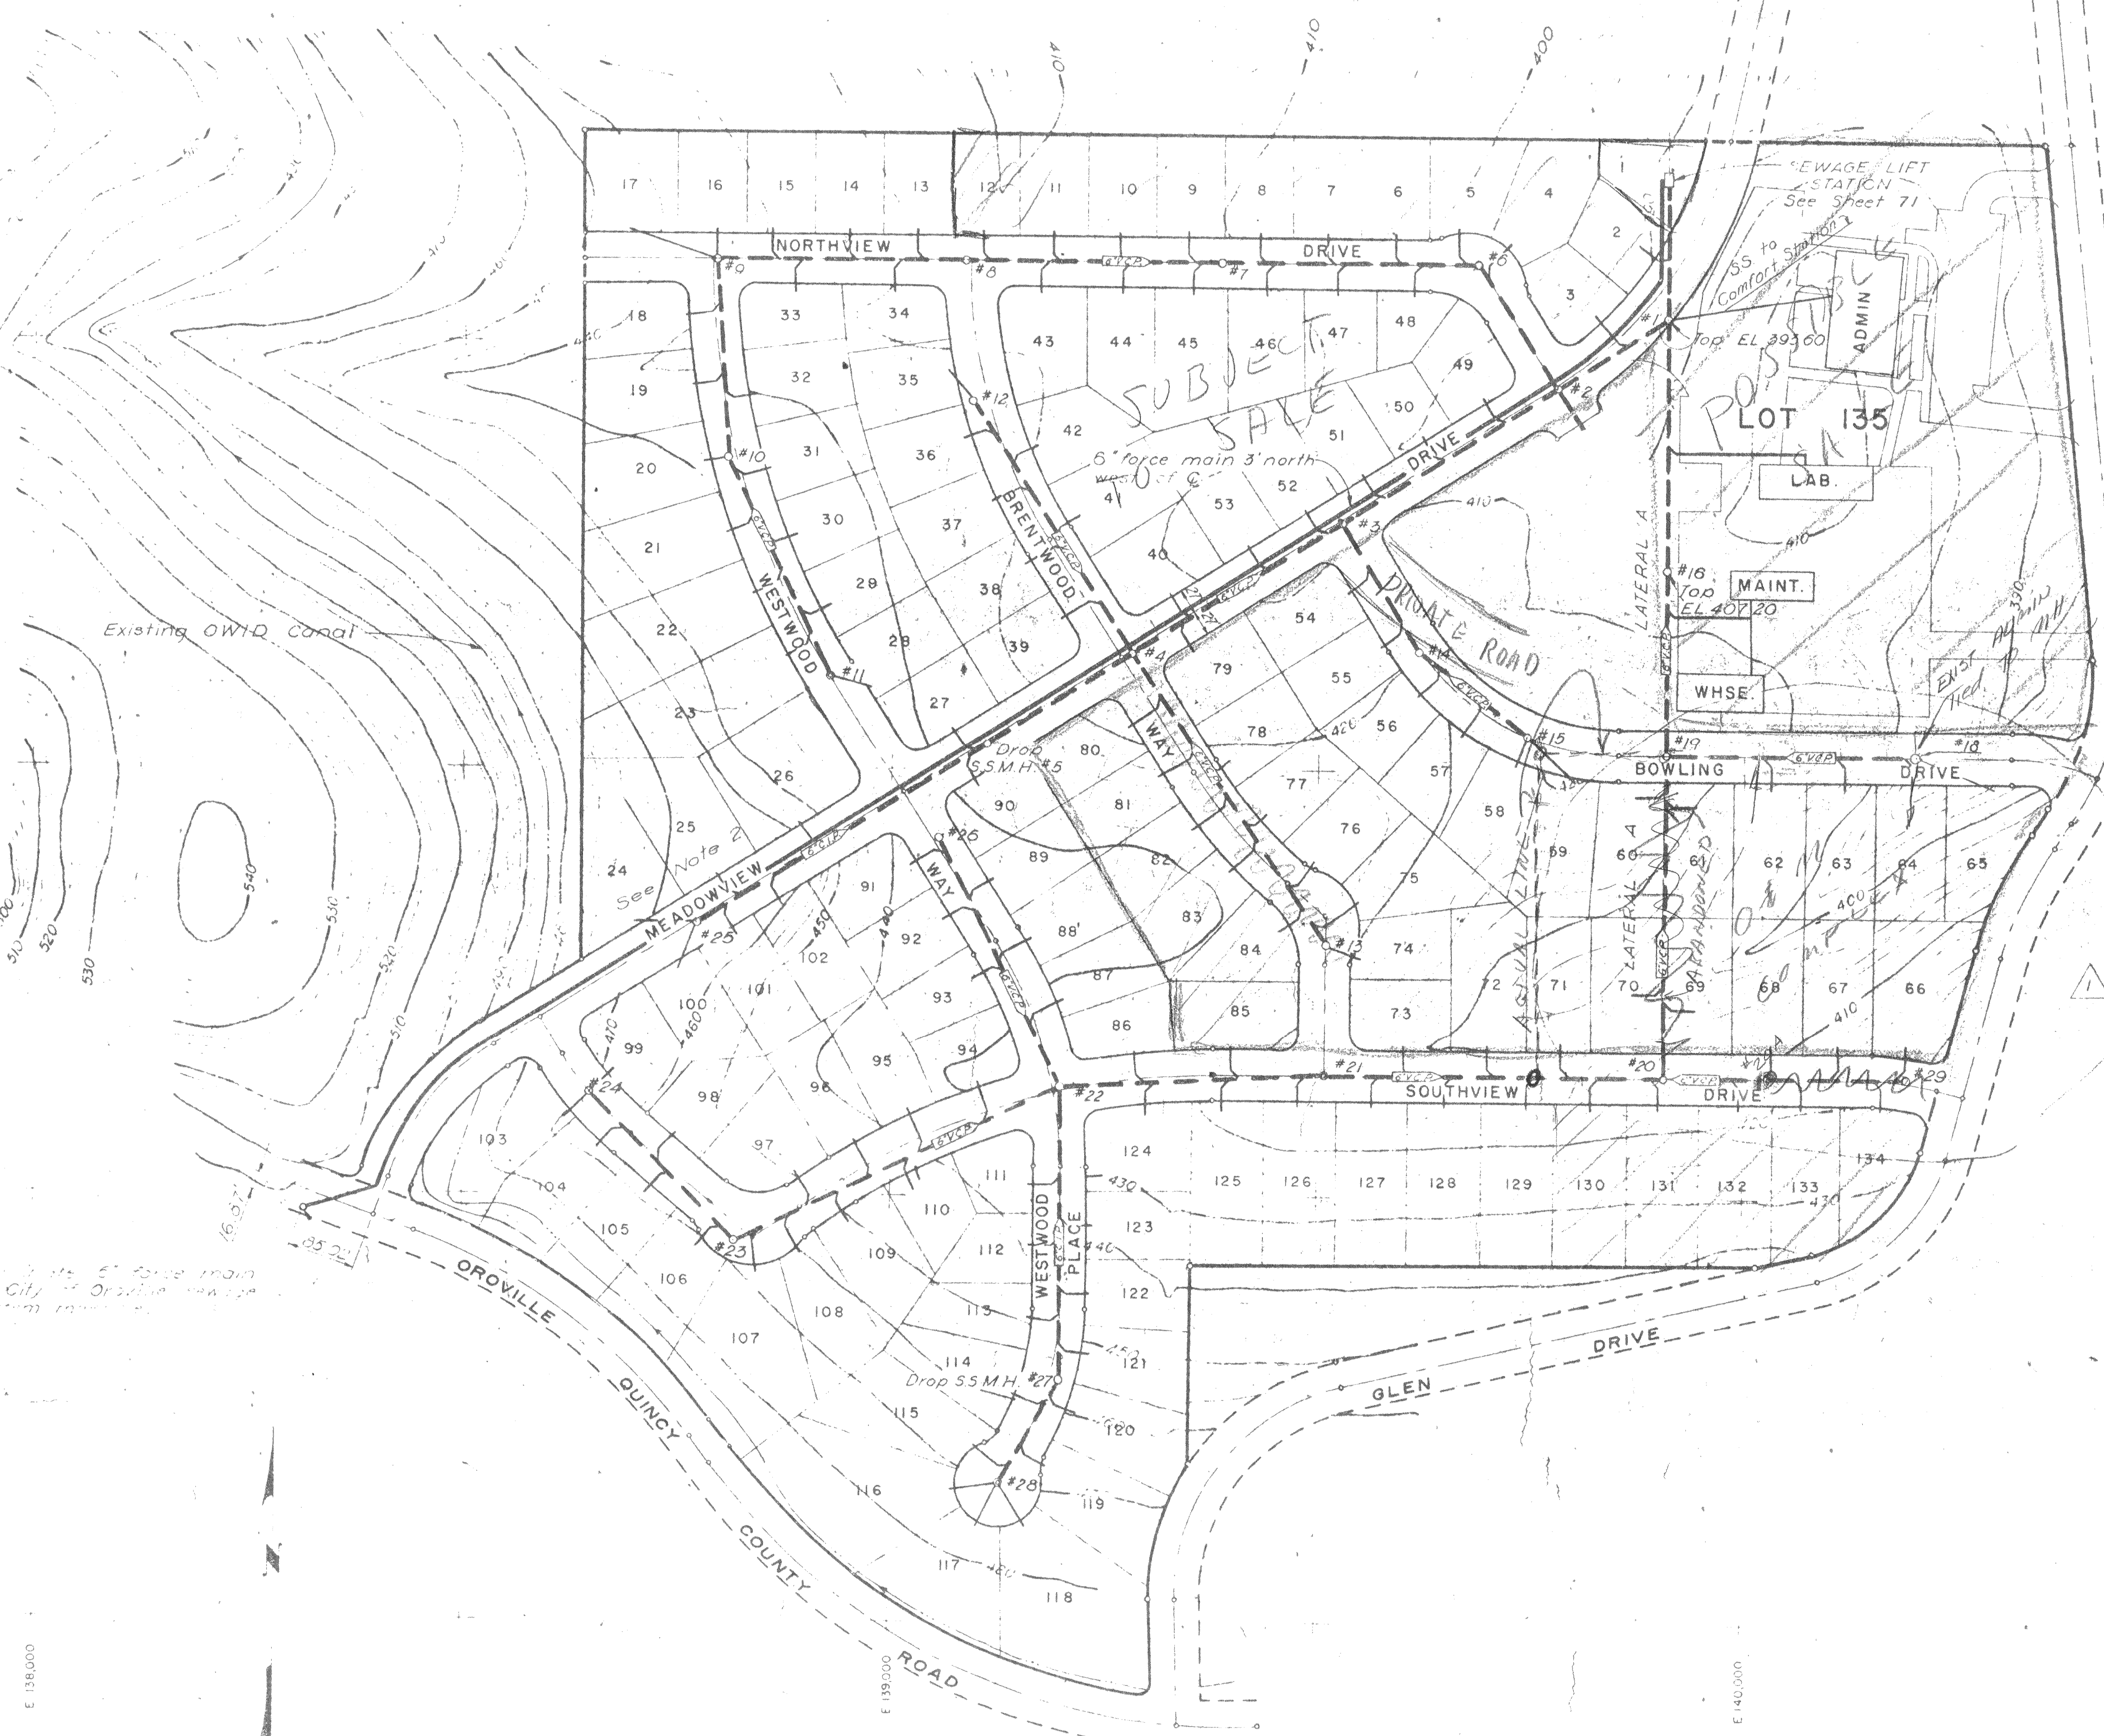

10 11
15 14 T.19N., R.4 E.

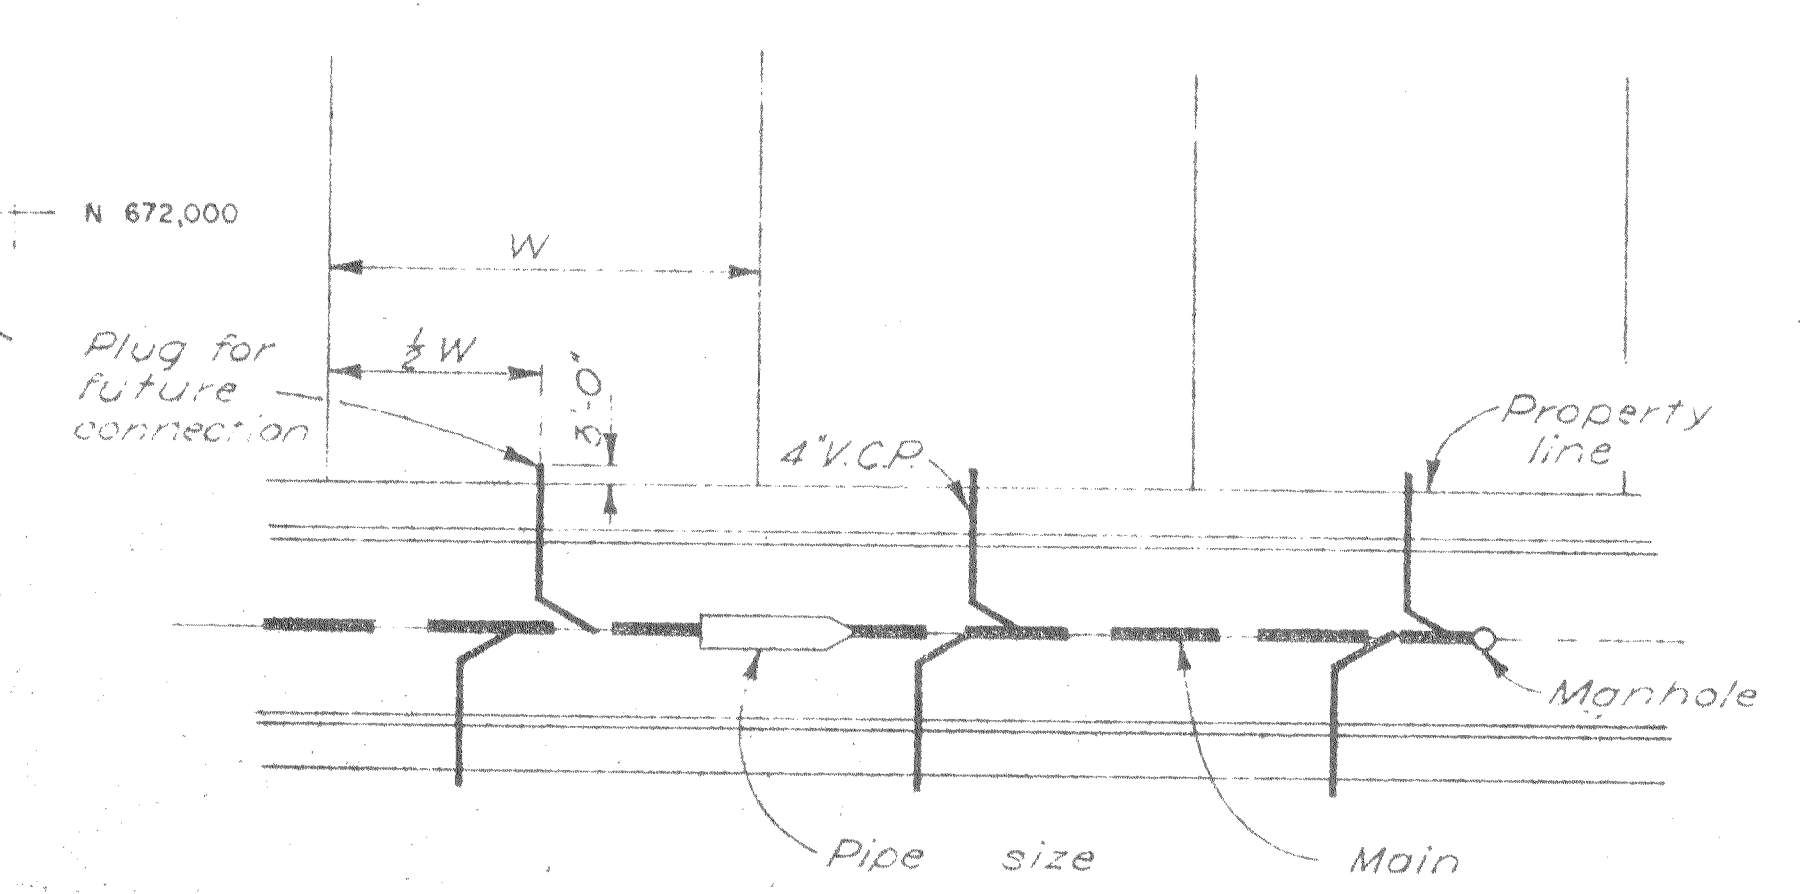

TYPICAL LOT SERVICE LINE
Not to Scale


NOTES:

- 1. Stationing shown on plan and profile sheets is street & stationing.
- 2. Lot service lines to lots 24, 25, 26 and lots 105, 106, 107, 108 terminate 9' back of curb.

AS BUILT

12-9-65
RESIDENT ENGINEER DATE

12-15-65
PROJECT ENGINEER DATE

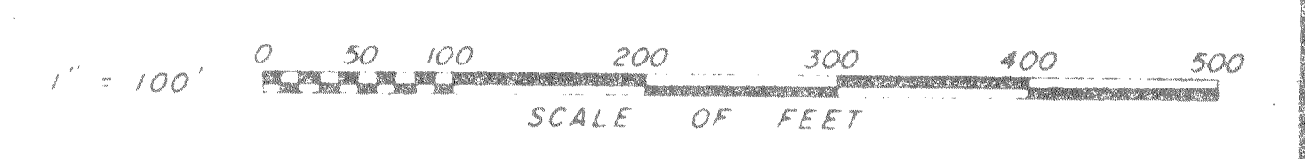

STATE OF CALIFORNIA
RESOURCES AGENCY OF CALIFORNIA
DEPARTMENT OF WATER RESOURCES
DIVISION OF DESIGN AND CONSTRUCTION

STATE WATER FACILITIES
OROVILLE DIVISION
CONSTRUCTION HEADQUARTERS
SANITARY SEWER SYSTEM AND
FORCE MAIN LAYOUT

Sheet 2 of 8

DESIGNED R. S. T. R. O. S.	DATE 5-62	DRAWN J. Ikami	DATE 5/62	CHECKED R. S. T. R. O. S.	DATE 8/62	REVIEWED OWEN	DATE 8-14	APPROVAL RECOMMENDED [Signature]	DATE	APPROVAL RECOMMENDED [Signature]	DATE
SUBMITTED: [Signature]								APPROVED: [Signature]		DATE: AUG 27 1962	
REVISIONS								DIVISION ENGINEER [Signature]		NO. 1850	
DRAWING NO. A-1264 SS-260											