
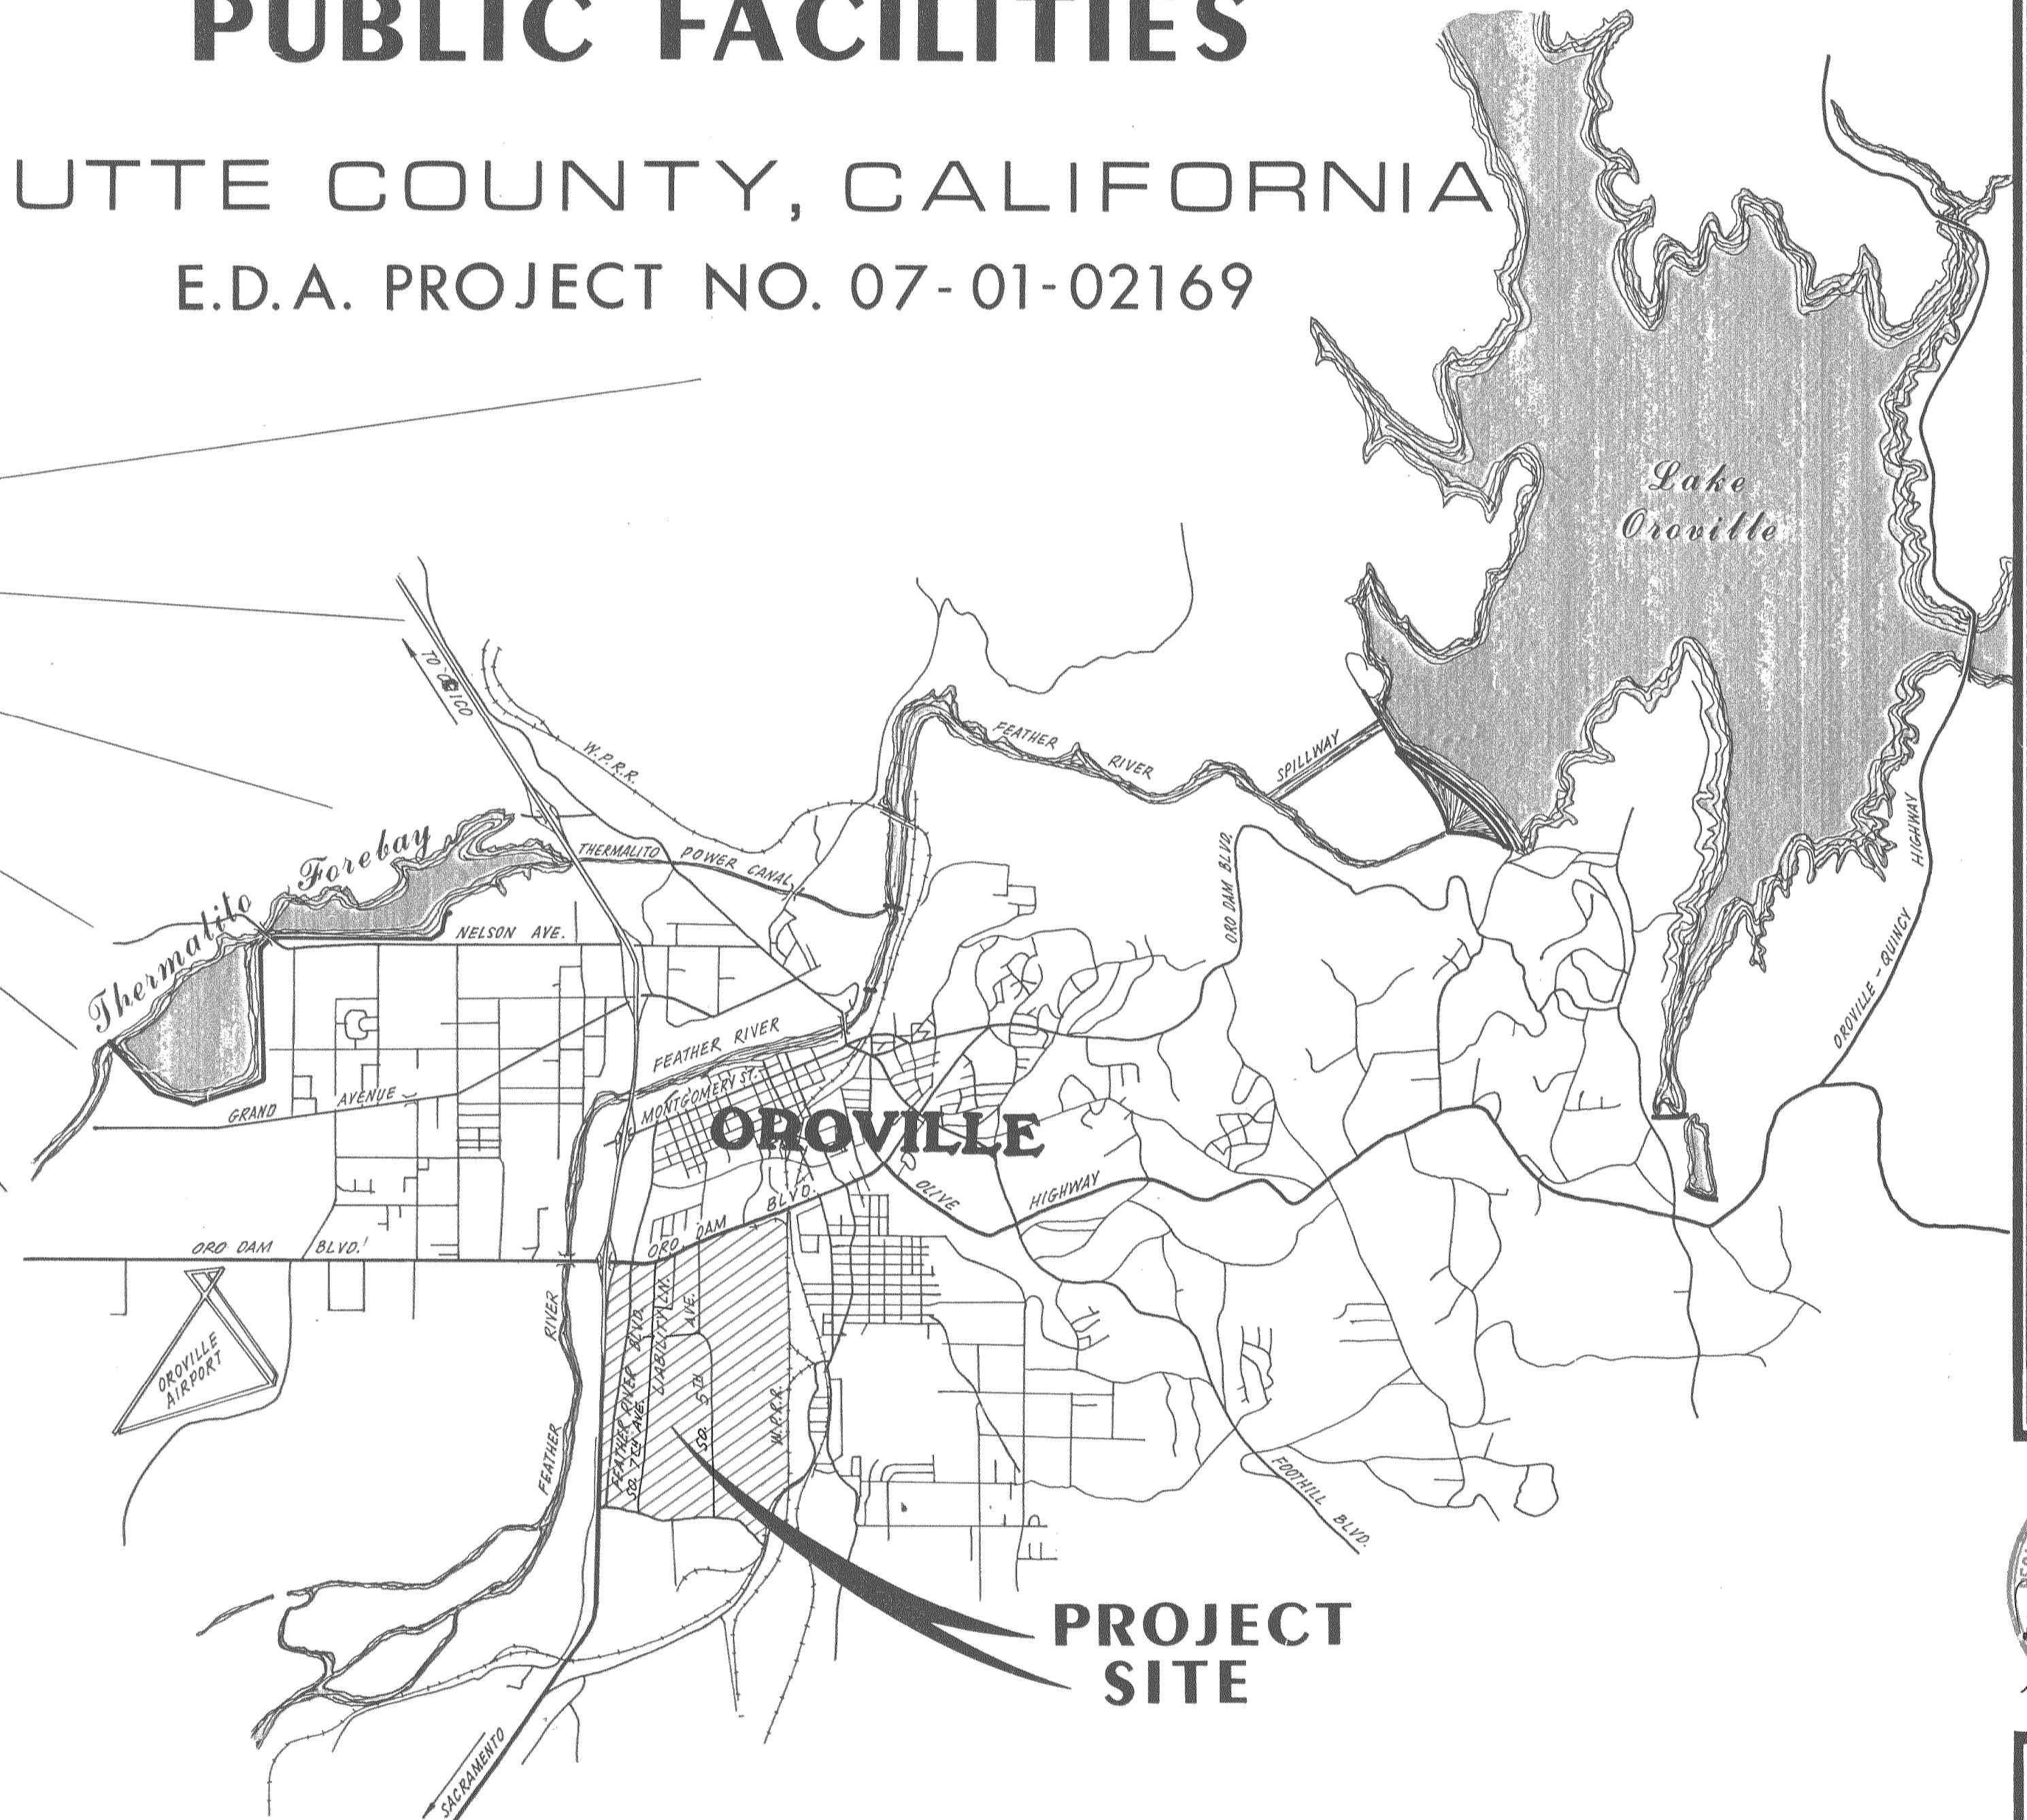
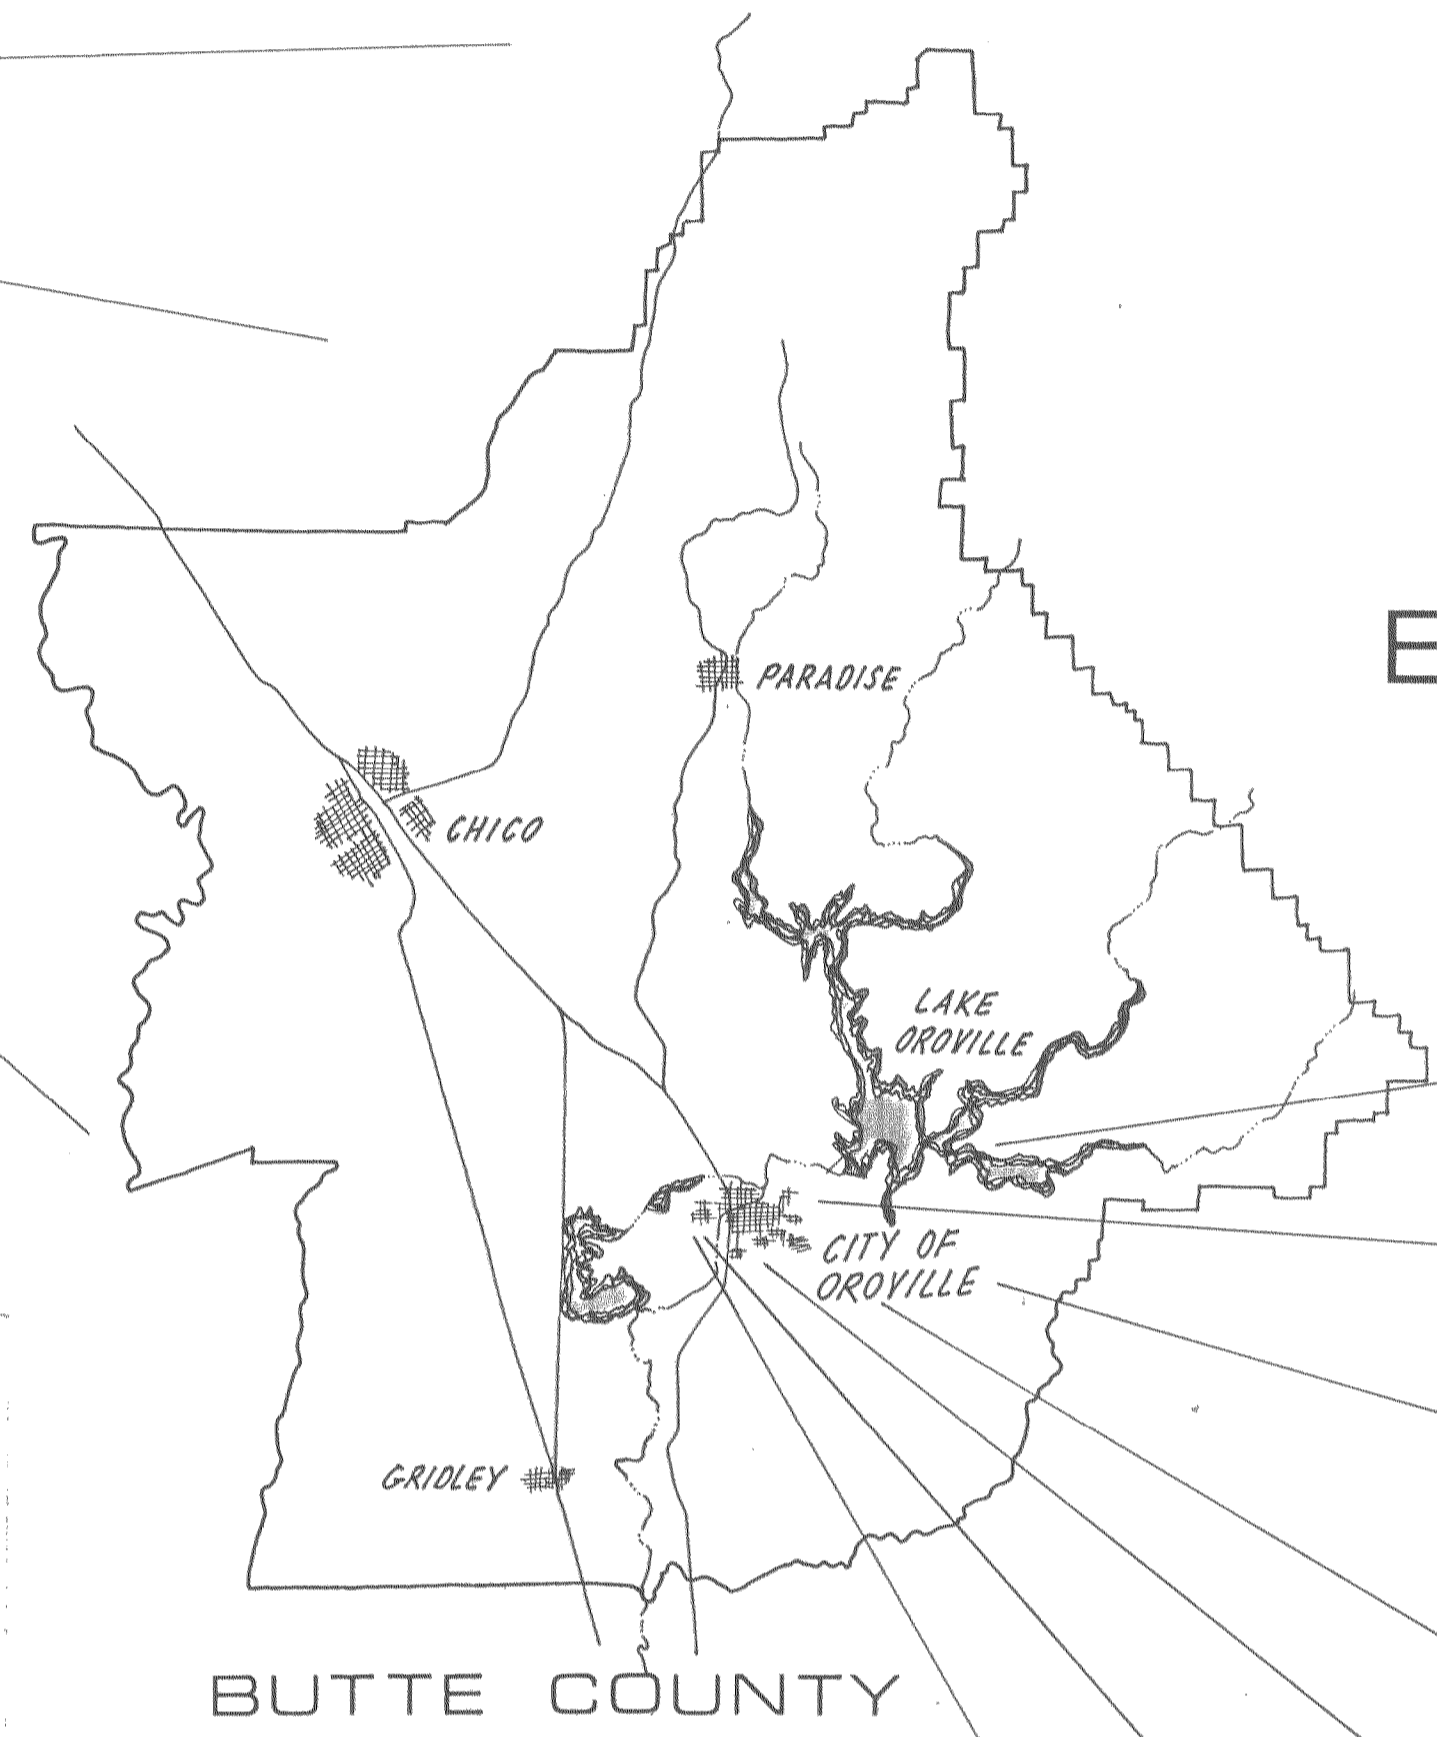


CITY OF OROVILLE PLANS

FOR CONSTRUCTION OF INDUSTRIAL UNIT No. 2 PUBLIC FACILITIES

BUTTE COUNTY, CALIFORNIA
E.D.A. PROJECT NO. 07-01-02169

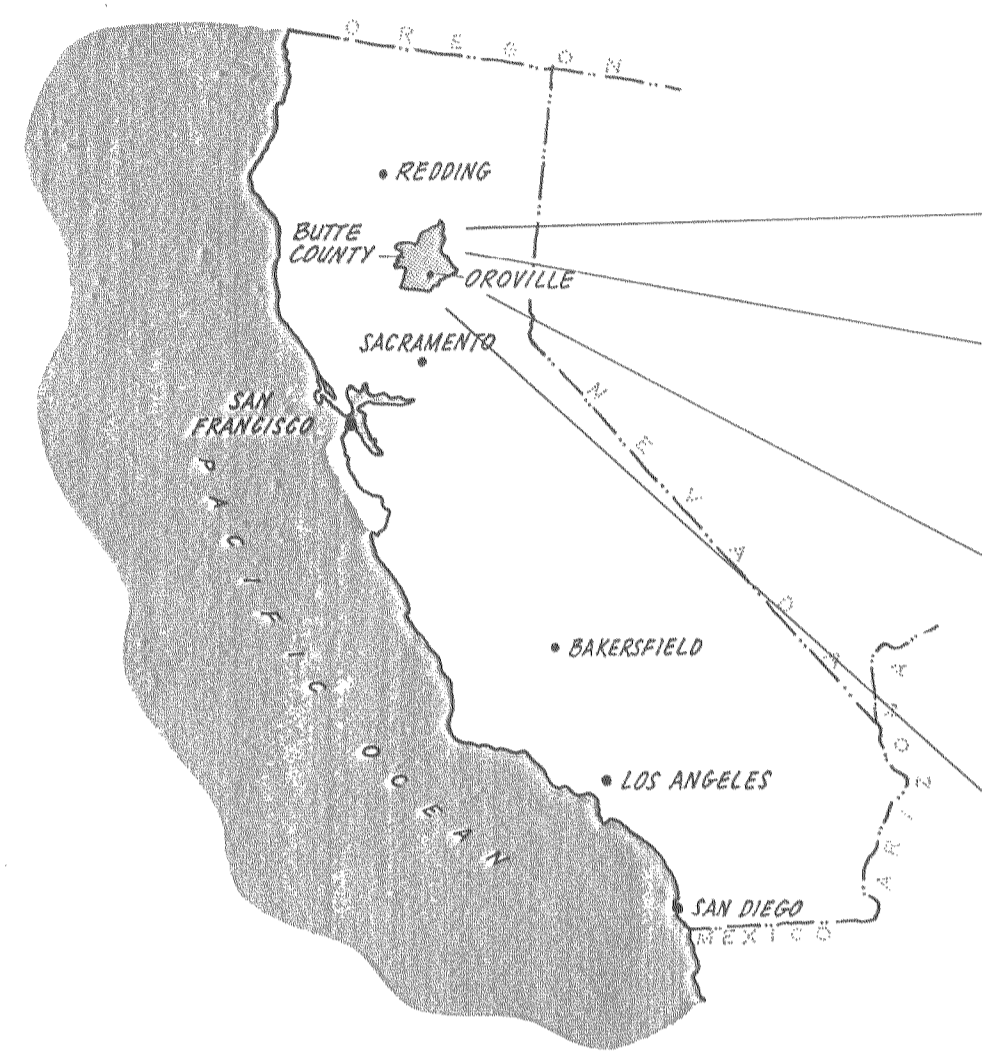

SHEET INDEX

SHEET NO.	TITLE
1	TITLE SHEET - APPROVALS
2	LOCATION MAP
2A	SCHEDULE A LOCATION MAP
2B	SCHEDULE B LOCATION MAP
2C	SCHEDULE C LOCATION MAP
3	PLAN & PROFILE SO. FIFTH AVENUE
4	PLAN & PROFILE SO. FIFTH AVE./E-W UTILITY
5	PLAN & PROFILE SO. SEVENTH AVENUE
6	PLAN & PROFILE SO. SEVENTH AVENUE
7	PLAN & PROFILE CAL-OAK ROAD
8	PLAN & PROFILE SO. SEVENTH AVE./LIABILITY LANE
9	PLAN & PROFILE FEATHER RIVER BOULEVARD
10	PLAN & PROFILE FEATHER RIVER BOULEVARD
11	PLAN & PROFILE FEATHER RIVER BOULEVARD
12	STORM DRAIN OUTFALL CHANNEL
13	STORM DRAIN OUTFALL CHANNEL
14	STORM DRAIN OUTFALL CHANNEL
C1	INTERSECTION LAYOUT DETAILS
C2	INTERSECTION LAYOUT DETAILS
C3	MISCELLANEOUS STRUCTURES
C4	DUPLEX SEWAGE PUMPING STATION
C5	DUPLEX SEWAGE PUMPING STATION DETAILS
C6	S.C.O.R. OUTFALL LINE RELOCATION
C7	MISC. TYPICAL SECTIONS & DETAILS
C8	MISC. DETAILS - WATER
C9	MISC. DETAILS - SEWER
E1	ELECTRICAL DETAILS SEWAGE PUMPING STATION

COOK ASSOCIATES
ENGINEERING CONSULTANTS
2060 PARK AVENUE, OROVILLE, CALIFORNIA 95965

CITY OF OROVILLE
Industrial Unit No. 2
E.D.A. PROJECT NO. 07-01-02169
TITLE SHEET



SUBMITTED BY
Dan J. Cook
DAN J. COOK R.C.E. 13062

Ronald D. McElroy
RONALD D. McELROY R.C.E. 15170

APPROVALS
APPROVED FOR CONSTRUCTION MARCH 17, 1980.

Clayton W. D'Arcy
MAYOR
CLAYTON W. D'ARCY

David M. Jinkens
CITY ADMINISTRATOR
DAVID M. JINKENS

William S. Harelson
DIRECTOR OF PUBLIC WORKS
WILLIAM S. HARELSON

REVISION	DATE

S. JACKSON
DRAWN DATE
P.L.C. 3-80
APPROVED DATE
A-361
FILE NO.
SHEET NO. 1
OF 27 SHTS
JOB NO. 79457