

| SHEET NO. | SUBJECT |
|-----------|---|
| 1 | VICINITY MAP; INDEX SHEET; LEGEND; GENERAL DATA |
| 2 | PLAN & PROFILE, RUDY CREEK LIFT STATION, "W" LINE |
| 3 | PLAN & PROFILE, "W" LINE |
| 4 | PLAN & PROFILE, "W" LINE |
| 5 | PLAN & PROFILE, "W" LINE |
| 6 | PLAN & PROFILE, "W" LINE, FEATHER RIVER PUMP STATION & FORCE MAIN |
| 7 | PLAN & PROFILE, FEATHER RIVER FORCE MAIN |
| 8 | PLAN & PROFILE, FEATHER RIVER FORCE MAIN, "E" LINE |
| 9 | PLAN & PROFILE, "E" LINE, "S" LINE |
| 10 | PLAN & PROFILE, "S" LINE |
| 11 | PLAN & PROFILE, "S" LINE |
| 12 | PLAN & PROFILE, "S" LINE |
| 13 | MANHOLES, HOUSE LATERALS, AND PIPELINE DETAILS |
| 14 | FEATHER RIVER FORCE MAIN DETAILS |
| 15 | FEATHER RIVER PUMP STATION, LAYOUT, MECHANICAL PLAN & SECTION |
| 16 | FEATHER RIVER PUMP STATION, BUILDING & MISCELLANEDUS DETAILS |
| 17 | FEATHER RIVER PUMP STATION DETAIL SHEET |
| 18 | ELECTRICAL |
| 19 | ELECTRICAL |
| 20 | RUDY CREEK LIFT STATION |



LEGEND

| | |
|-----|---|
| CAP | CORRUGATED ALUMINIUM PIPE |
| CMP | CORRUGATED METAL PIPE (GENERALLY STEEL) |
| CSP | CORRUGATED STEEL PIPE |
| T | PT&T (UNDERGROUND) |
| NIC | NOT IN CONTRACT |
| G | GAS LINE (EXISTING) |
| W | WATER LINE (EXISTING) |
| CO | CLEANOUT |
| SE | SAND EQUIVALENT |
| RC | RELATIVE COMPACTION (% OF MODIFIED AASHO) |
| ROW | RIGHT-OF-WAY |
| — | SEWER |
| ○ | MANHOLE |

GENERAL DATA:
 DATUM IS MEAN SEA LEVEL, USC&GS
 PLOTTED STREET R/W LINES AND PROPERTY LINES ARE APPROXIMATE ONLY
 DATE OF AERIAL PHOTOGRAPHY: NOV. 21, 1973 (CH2M-HILL)

AS-BUILT LEGEND

| | | |
|--|---------|---|
| | S=0.002 | =SLOPE OF SEWER AS-BUILT |
| | CUT 122 | = AS-BUILT INFORMATION & CUTS SHOWN ARE @ END & T-O-R SERVICE AS SHOWN |
| | | = AS-BUILT ALIGNMENT (VERTICAL OR HORIZONTAL) OR GENERAL AS-BUILT RELOCATION AS NOTED |

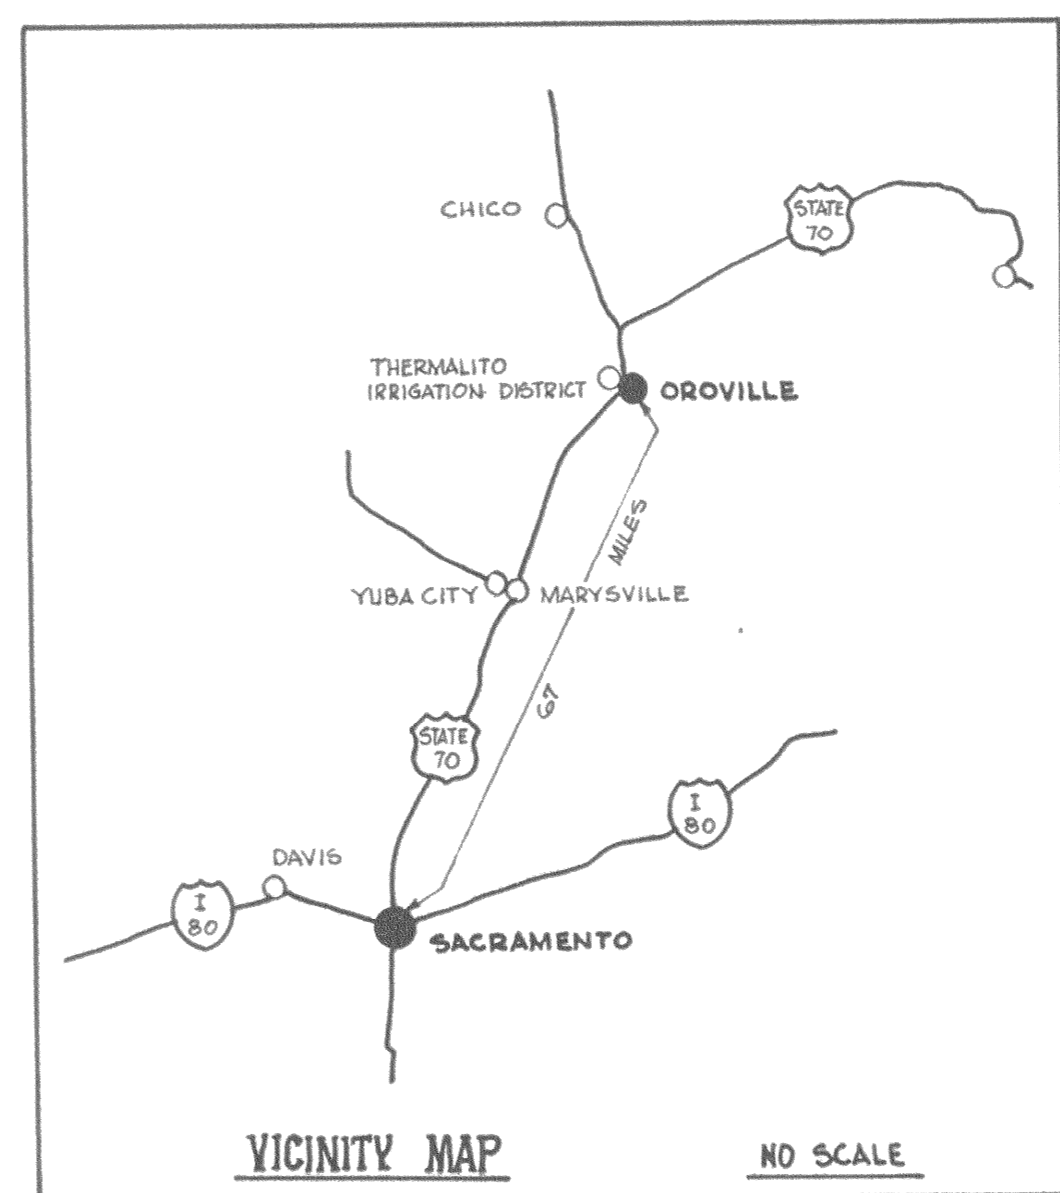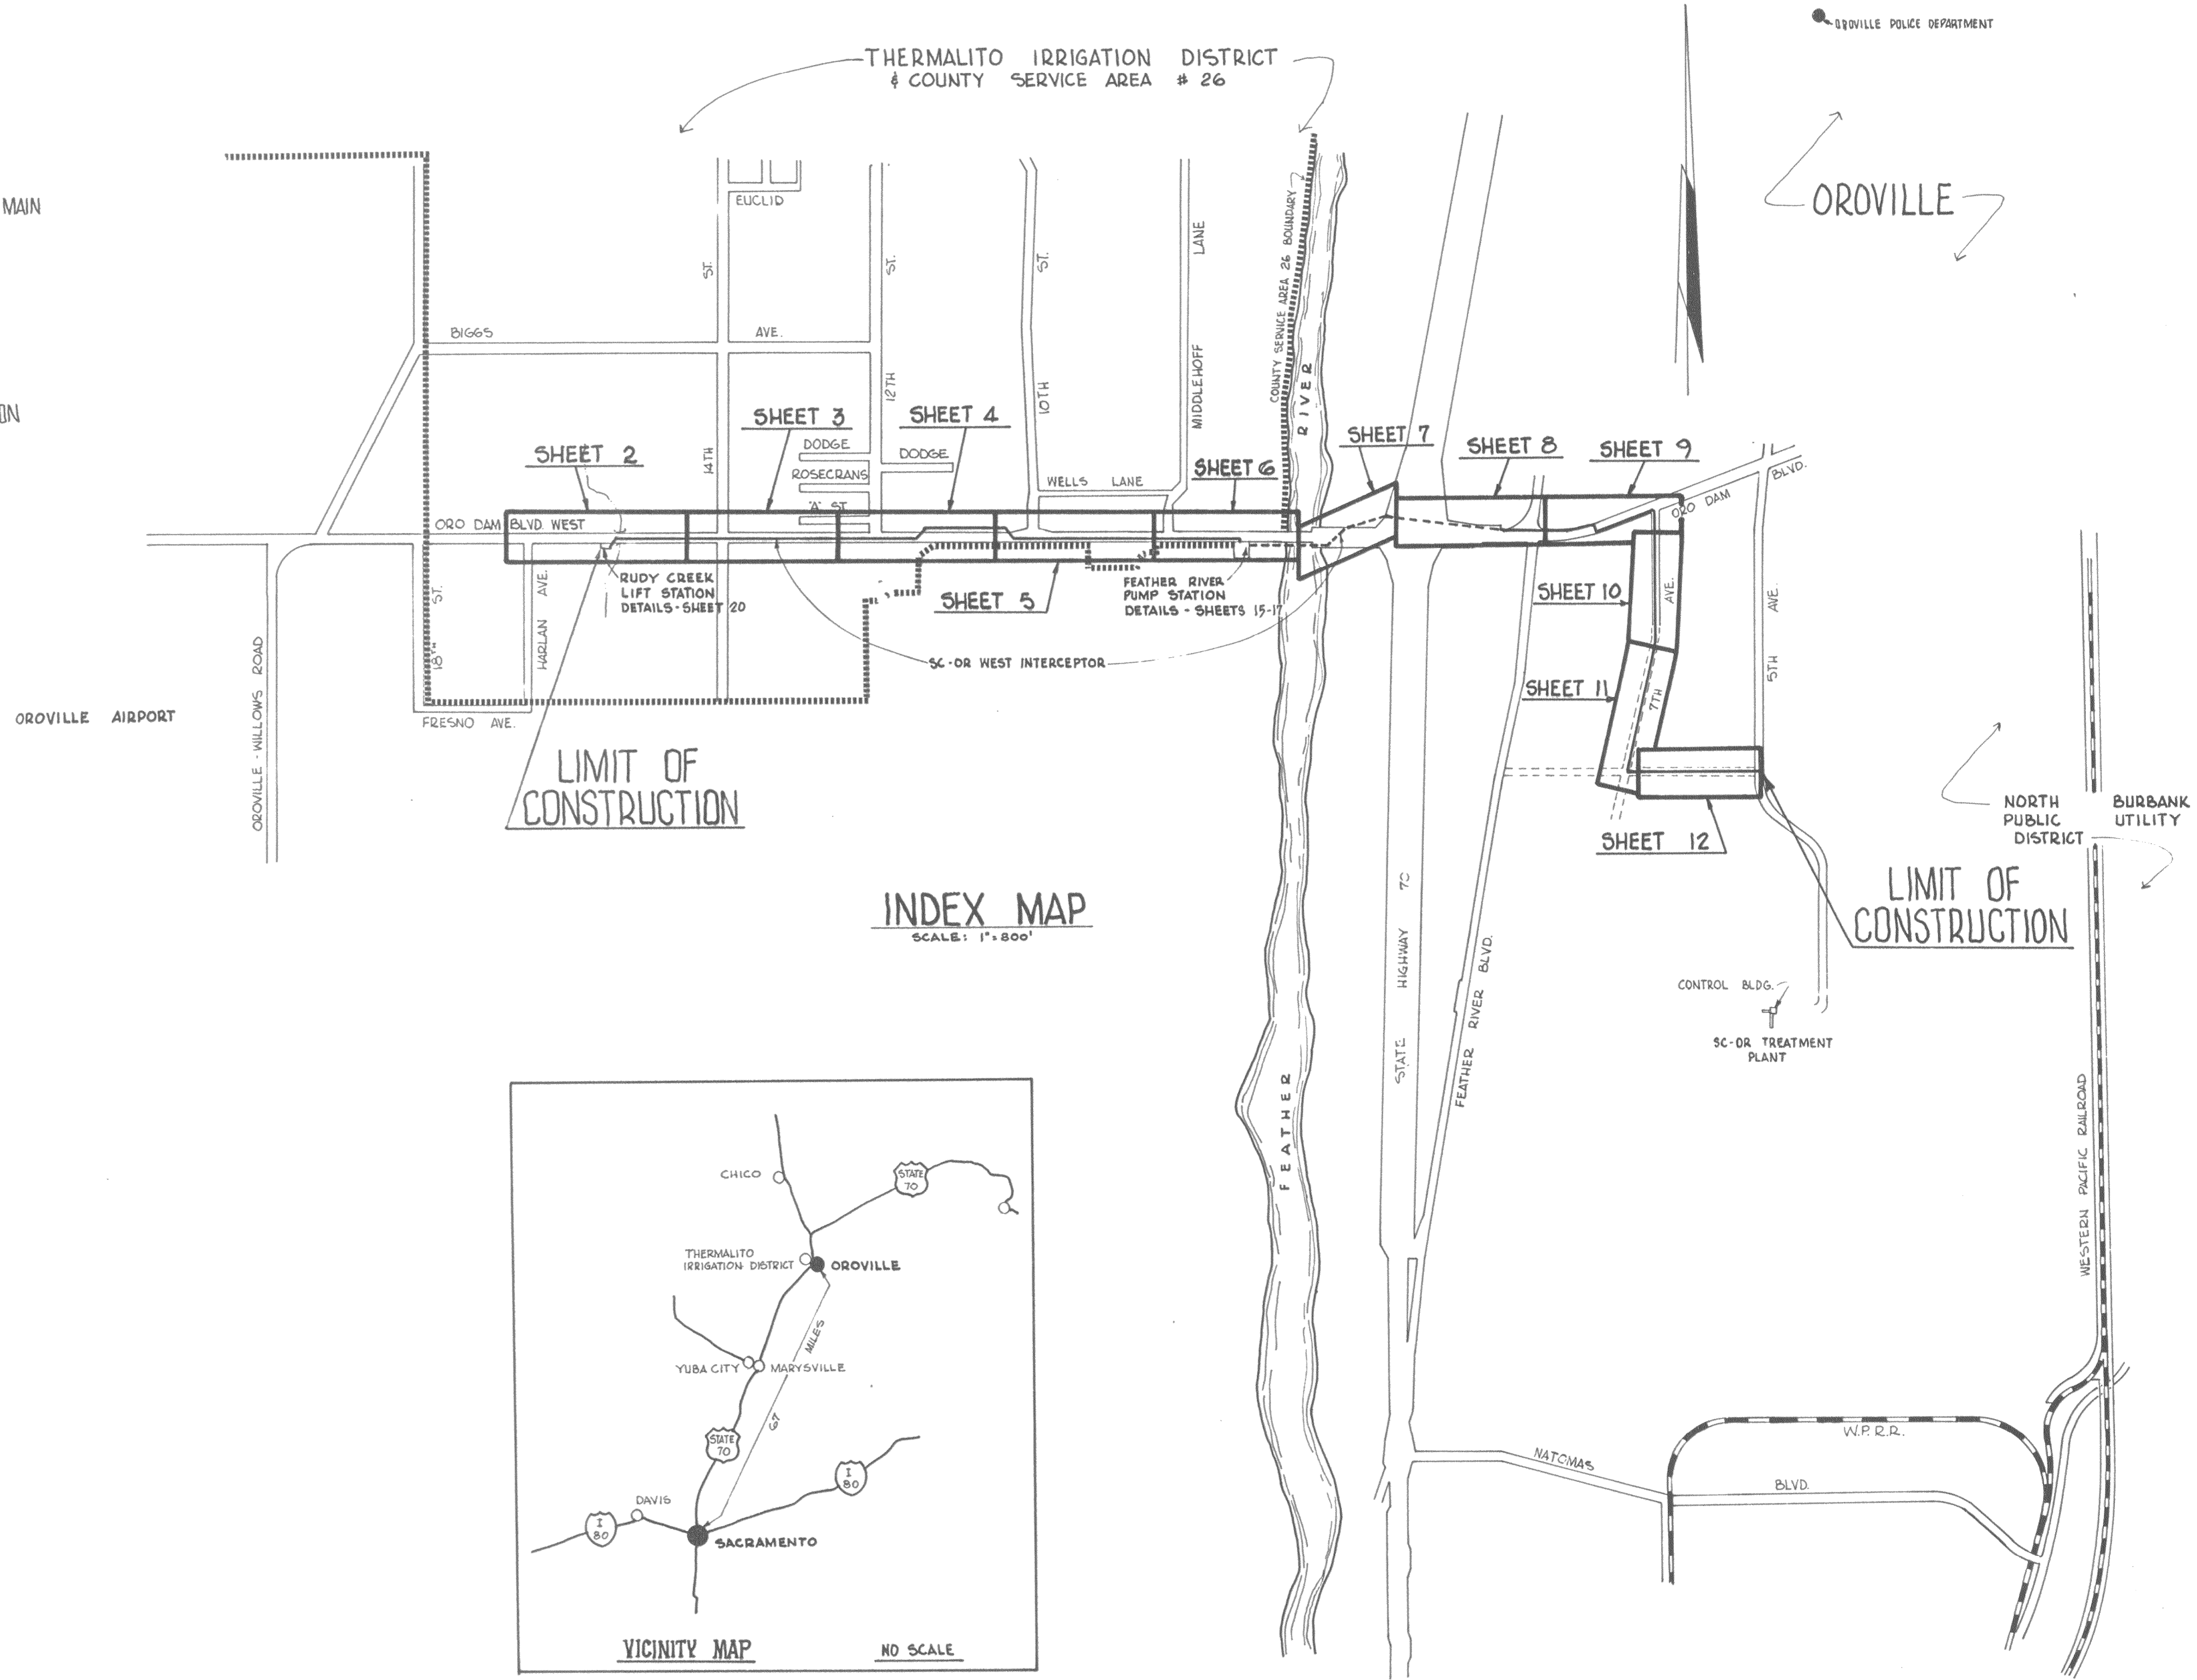

AS-BUILT

| | | | | | | | | | |
|--|--------------------------|-----|------|----------|----|-------------------------|---|--------------------------|--|
| | DES. | | | | | VICINITY MAP, INDEX MAP | SEWERAGE COMMISSION, OROVILLE REGION OROVILLE, CALIFORNIA | SC - OR WEST INTERCEPTOR | SHEET 1 OF 20 DATE AUG. 1, 1974 PROJ. 2316 NO. |
| | DR. GB | | | | | | | | |
| | CHK. EAR | | | | | | | | |
| | APPD. <i>[Signature]</i> | NO. | DATE | REVISION | BY | APPD. | | | |