


OLIVE GLEN LIFT STATION

City of Oroville


FOR TECHNICAL INFORMATION CONTACT THE FOLLOWING:

CIVIL/GENERAL	COOK ASSOCIATES, OROVILLE (916) 533-6457	TOM KUYKENDALL
ELECTRICAL	ED FARMER & ASSOC., SACRAMENTO (916) 443-8842	DAVE ARCHANGELO

SHEET INDEX	
No.	Sheet Title
1	TITLE SHEET
2	GENERAL ARRANGEMENT
3	PLAN AT BASE OF WET & DRY PITS
4	GENERAL SECTION
5	SECTION THRU WET WELL
6	MISCELLANEOUS DETAILS
7	PUMP & PIPING ARRANGEMENT
8	E1 ELECTRICAL DETAILS
9	E2 CONTROL BUILDING
10	E3 GENERATOR & SYMBOLS
11	E4 WIRING DETAILS

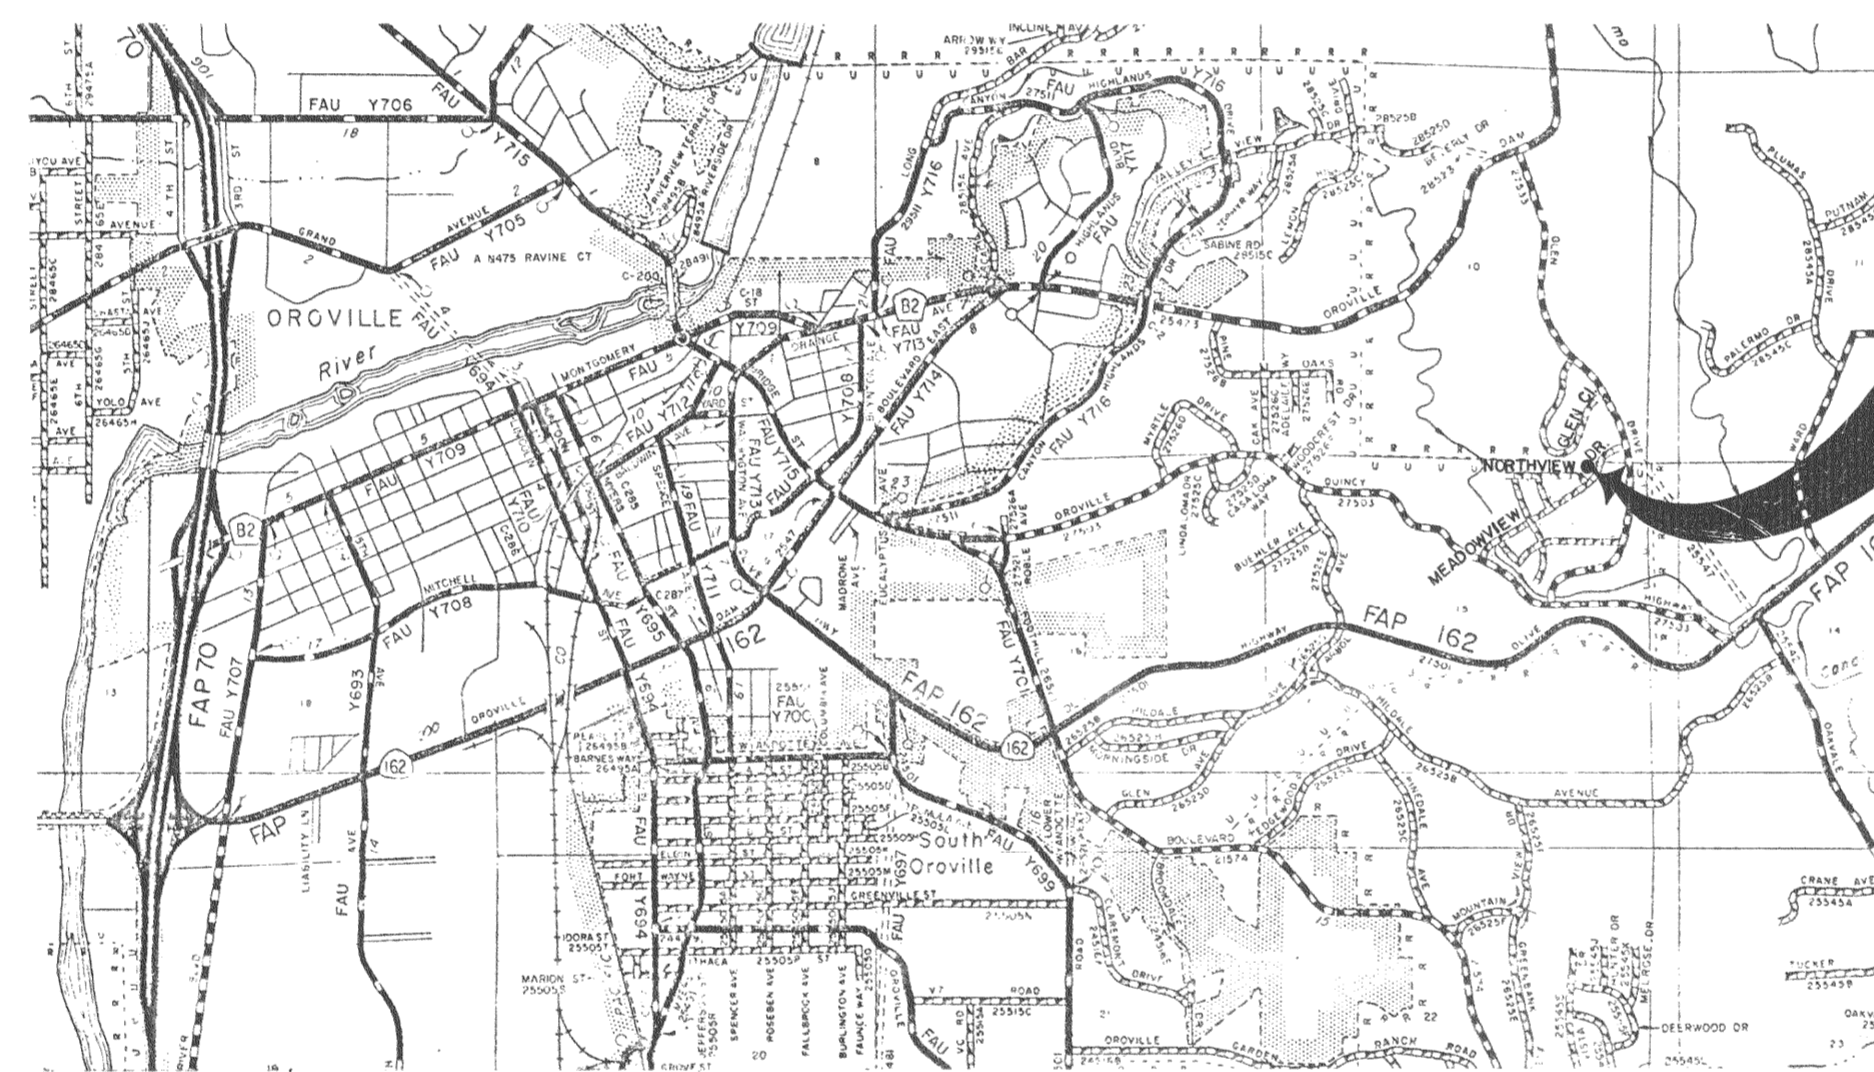

(A) LOCATION MAP CITY OF OROVILLE
NO. SCALE

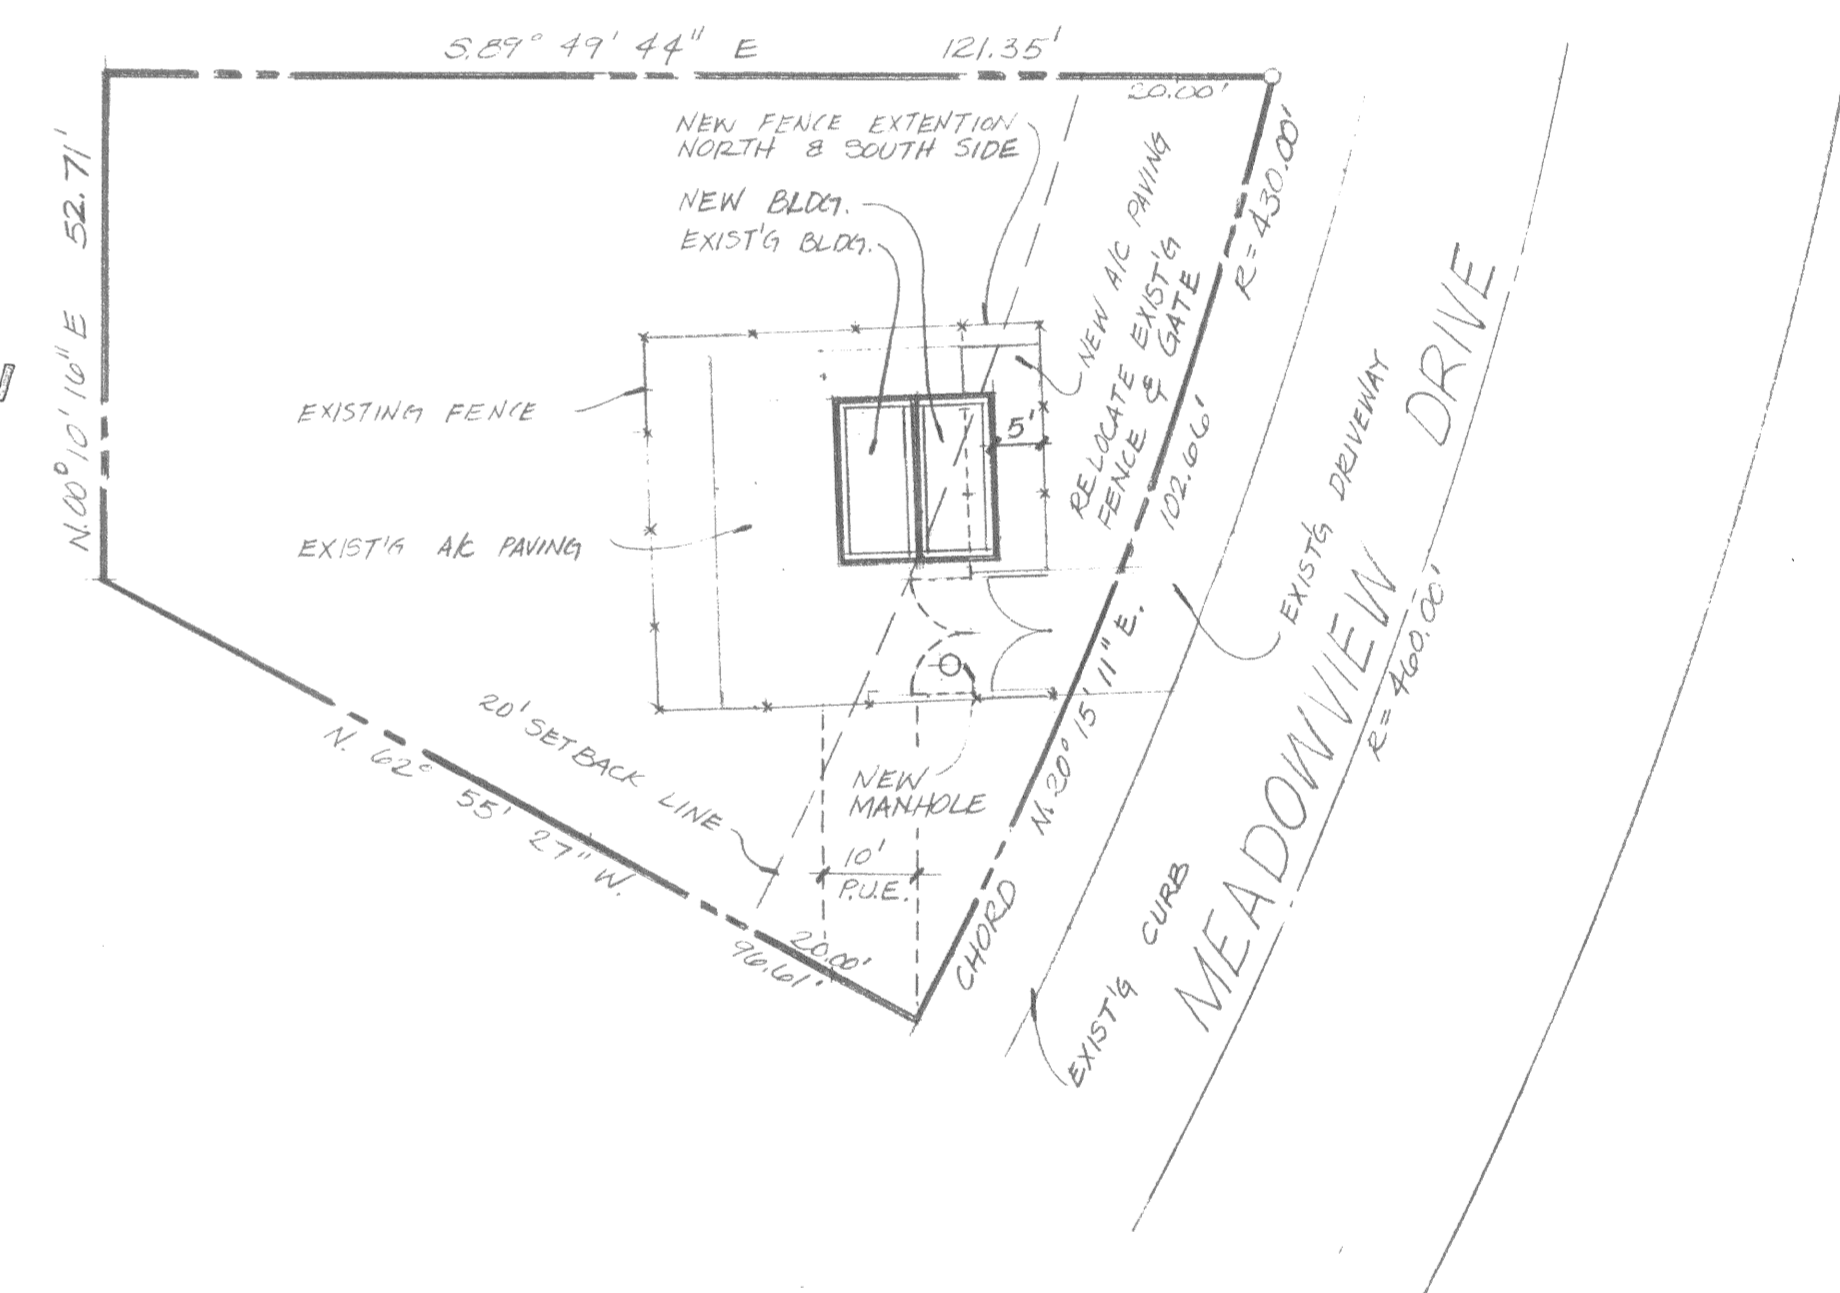

(B) SITE PLAN
1" = 20' - 0"

SUBMITTED:

Dan J. Cook
DAN J. COOK R.C.E. 13062

APPROVED:

Kirt M. Hunter
DIRECTOR OF PUBLIC WORKS
Kirt M. Hunter R.C.E. 21762

COOK ASSOCIATES
ENGINEERS ARCHITECTS

CITY OF OROVILLE
OLIVE GLEN LIFT STATION
TITLE SHEET, INDEX, SITE LOCATION



JOYCE	JULY 81
DATE	DATE
AUG 81	
11-452	
1	
11	
80465	