


THE EXISTENCE AND LOCATION OF ALL UTILITIES SHALL BE VERIFIED BY THE CONTRACTOR.

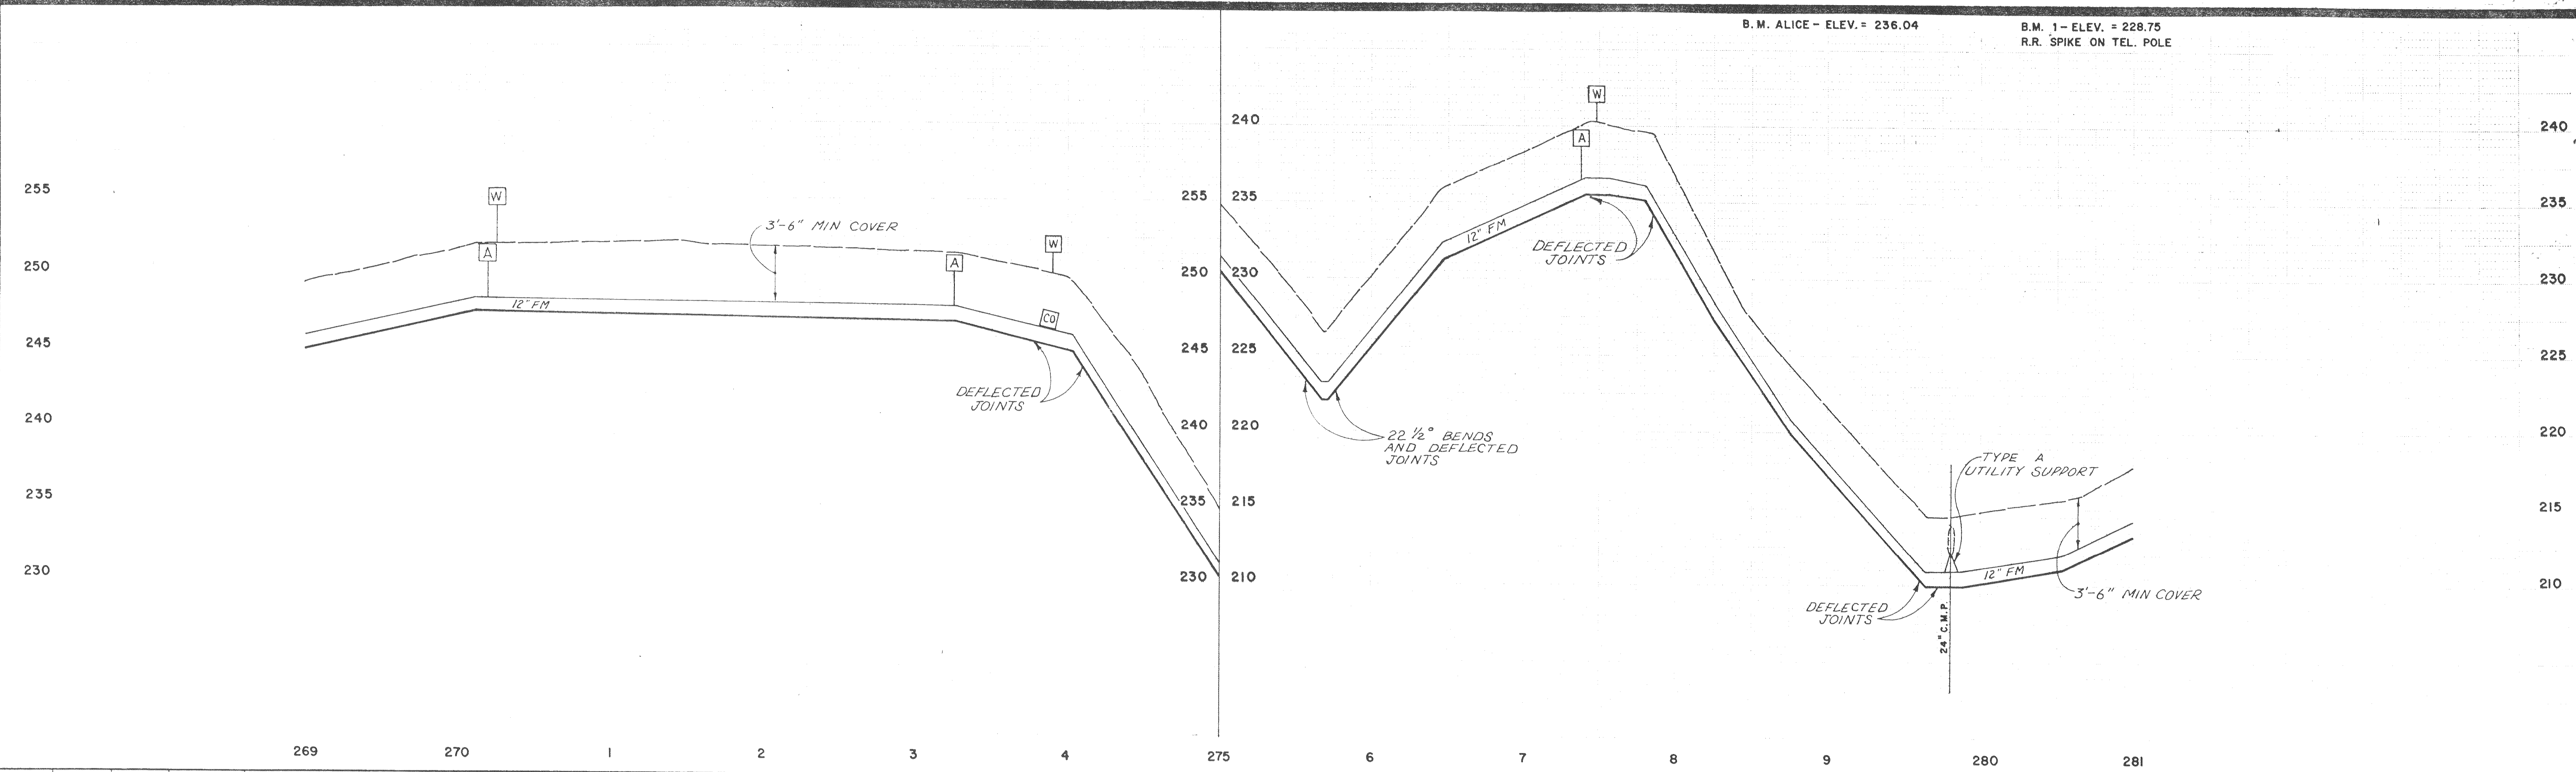

NUMBER	DATE	MADE BY	CHECKED BY	DESCRIPTION
REVISIONS				

DRAWN BY  
*D. Schlink*

DEPT. CHECK

PROJ. CHECK  
*D. Smith*

**M&E** METCALF & EDDY, INC. ENGINEERS  
BOSTON • NEW YORK • PALO ALTO • CHICAGO

REG. PROF. ENGR. *Charles E. Howard* DATE *8/30/74*

SCALE:  
HORIZONTAL 1" = 50'  
VERTICAL 1" = 5'

UNLESS OTHERWISE NOTED OR CHANGED BY REPRODUCTION

PACIFIC COAST PRODUCERS  
ORVILLE, CALIFORNIA  
INDUSTRIAL WASTEWATER TREATMENT & DISPOSAL FACILITIES  
FORCE MAIN - PLAN AND PROFILE  
STA 269+00 TO STA 281+00

JOB \_\_\_\_\_  
FILE NO. \_\_\_\_\_  
SHEET C-17