



DOWNER

THE EXISTENCE AND LOCATION OF ALL UTILITIES SHALL BE VERIFIED BY THE CONTRACTOR.

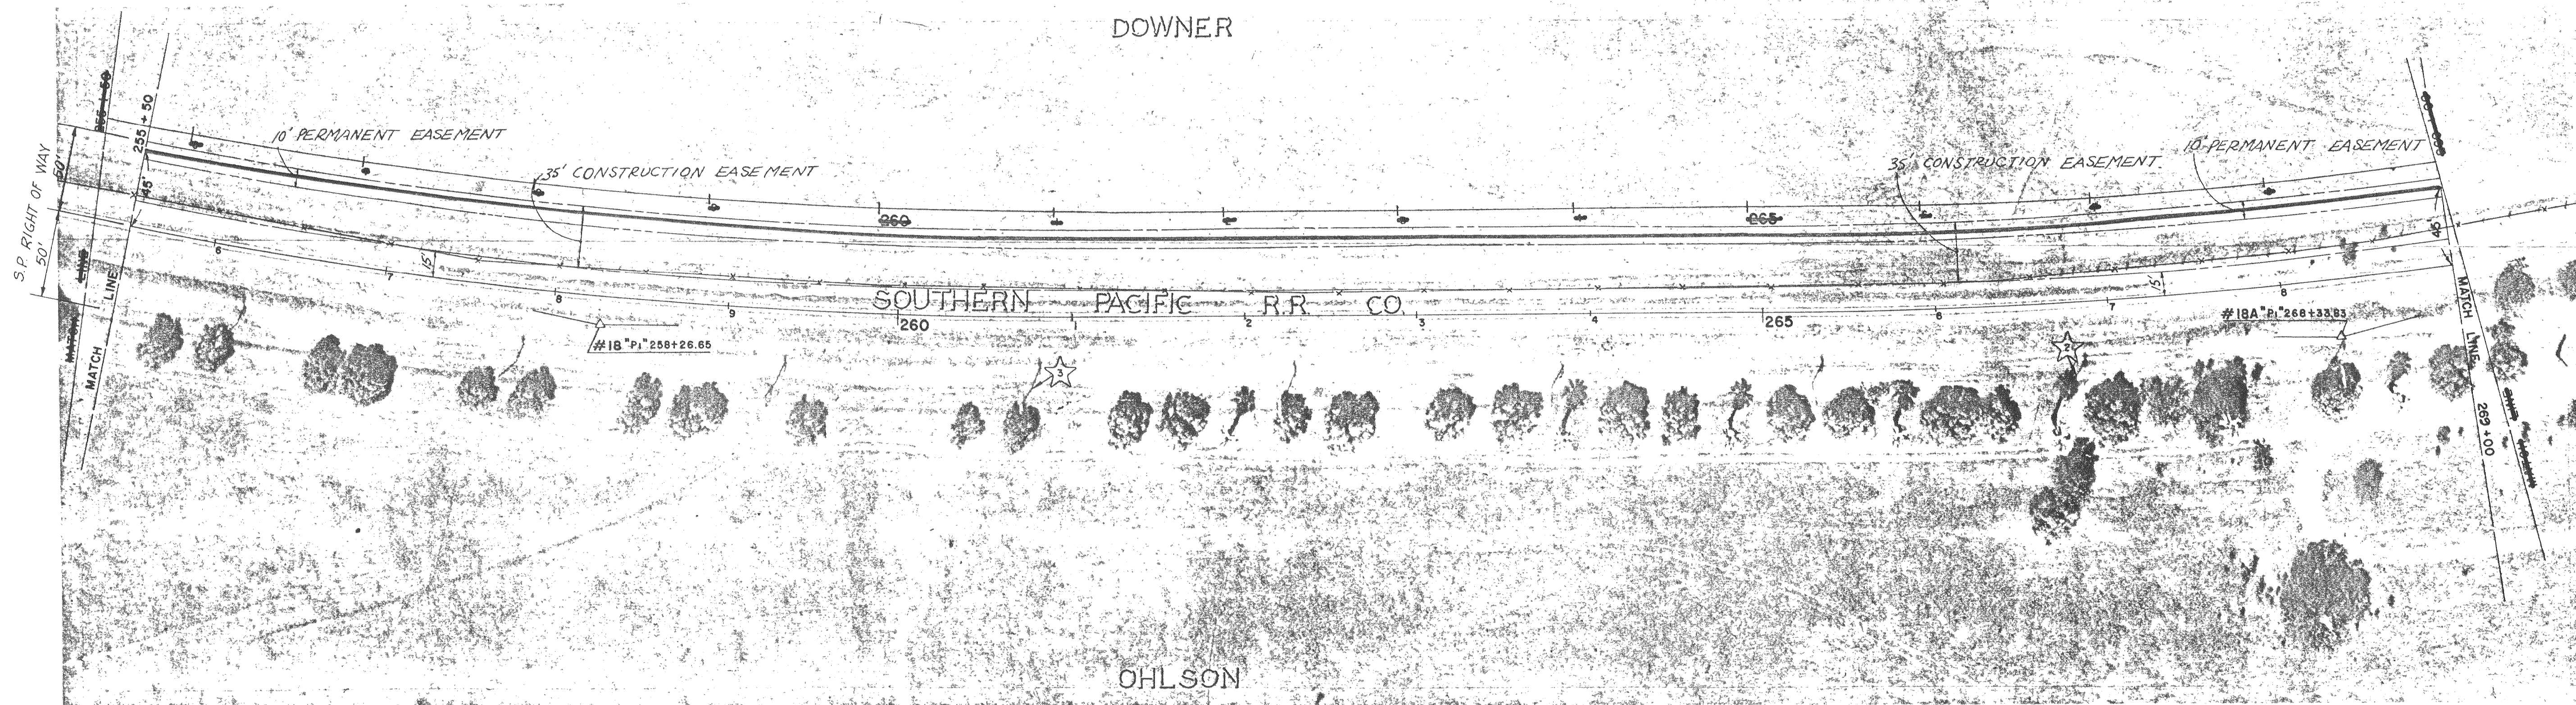

B.M. 3 - ELEV. = 236.14
R.R. SPIKE ON TEL. POLE # 858

B.M. 2 - ELEV. = 241.56
R.R. SPIKE ON TEL. POLE

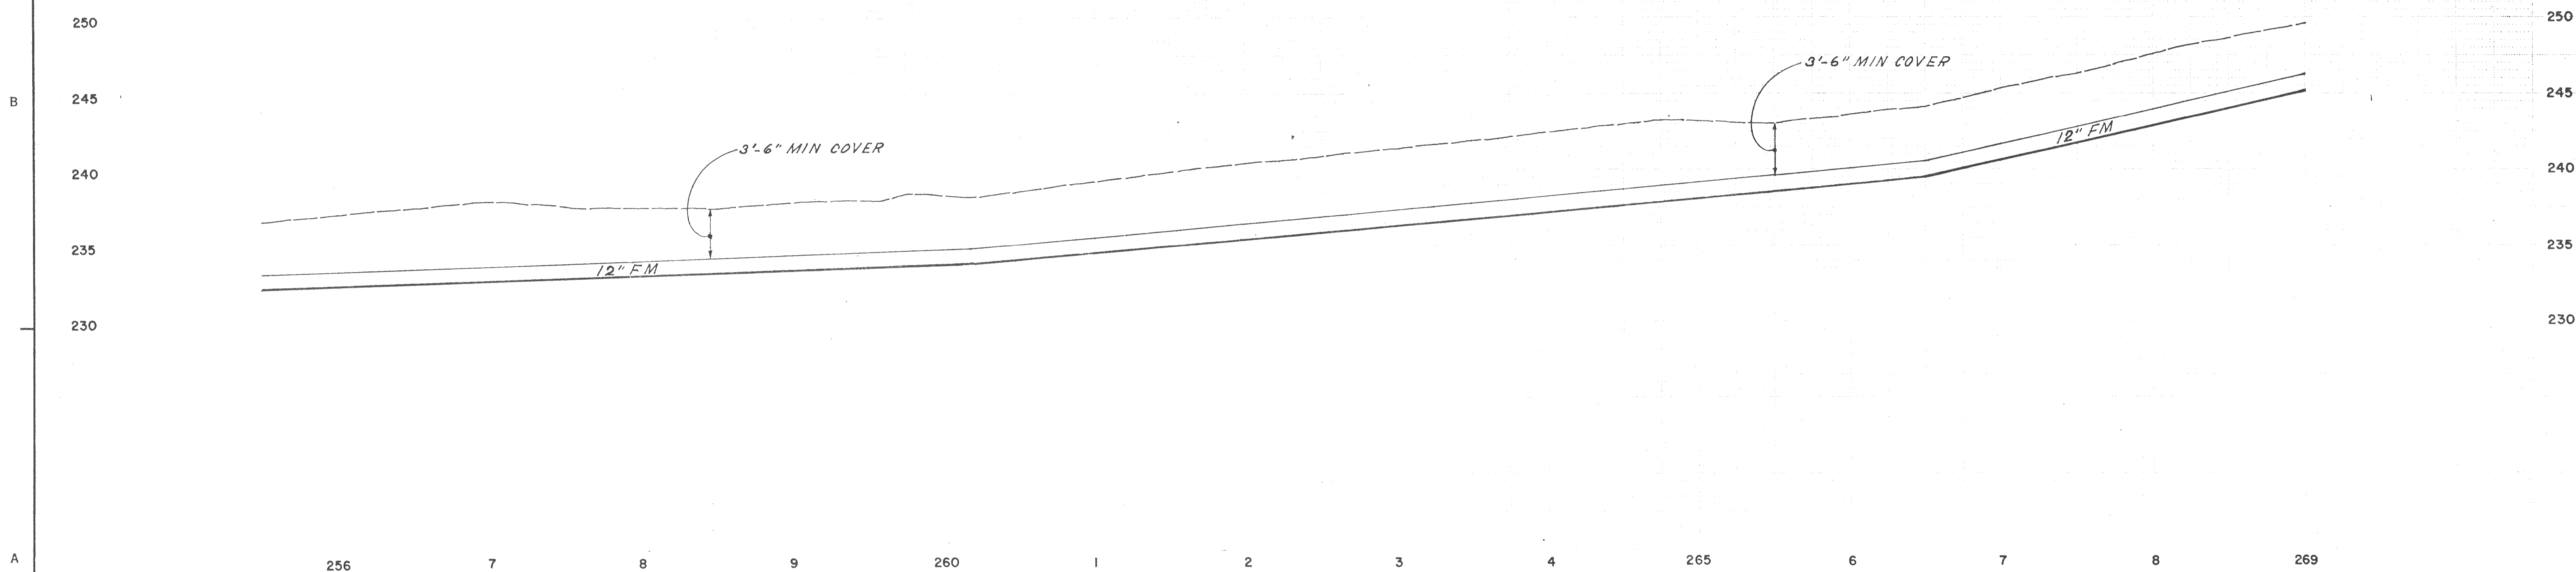

NUMBER	DATE	MADE BY	CHECKED BY	REVISIONS	DESCRIPTION

DRAWN BY *[Signature]*
 DEPT. CHECK
 PROJ. CHECK *[Signature]*

M&E METCALF & EDDY, INC. ENGINEERS
 BOSTON • NEW YORK • PALO ALTO • CHICAGO

REG. PROF. ENGR. *[Signature]* DATE 8/30/74
 REG. PROF. ENGR.

SCALE:
 HORIZONTAL 1" = 50'
 VERTICAL 1" = 5'

UNLESS OTHERWISE NOTED OR CHANGED BY REPRODUCTION

PACIFIC COAST PRODUCERS
 OROVILLE, CALIFORNIA
 INDUSTRIAL WASTEWATER TREATMENT & DISPOSAL FACILITIES
 FORCE MAIN - PLAN AND PROFILE
 STA 255+50 TO STA 269+00

JOB _____
 FILE NO. _____
 SHEET C-16