


B.M. 6 - ELEV. = 215.66  
 R.R. SPIKE ON TEL. POLE # 840

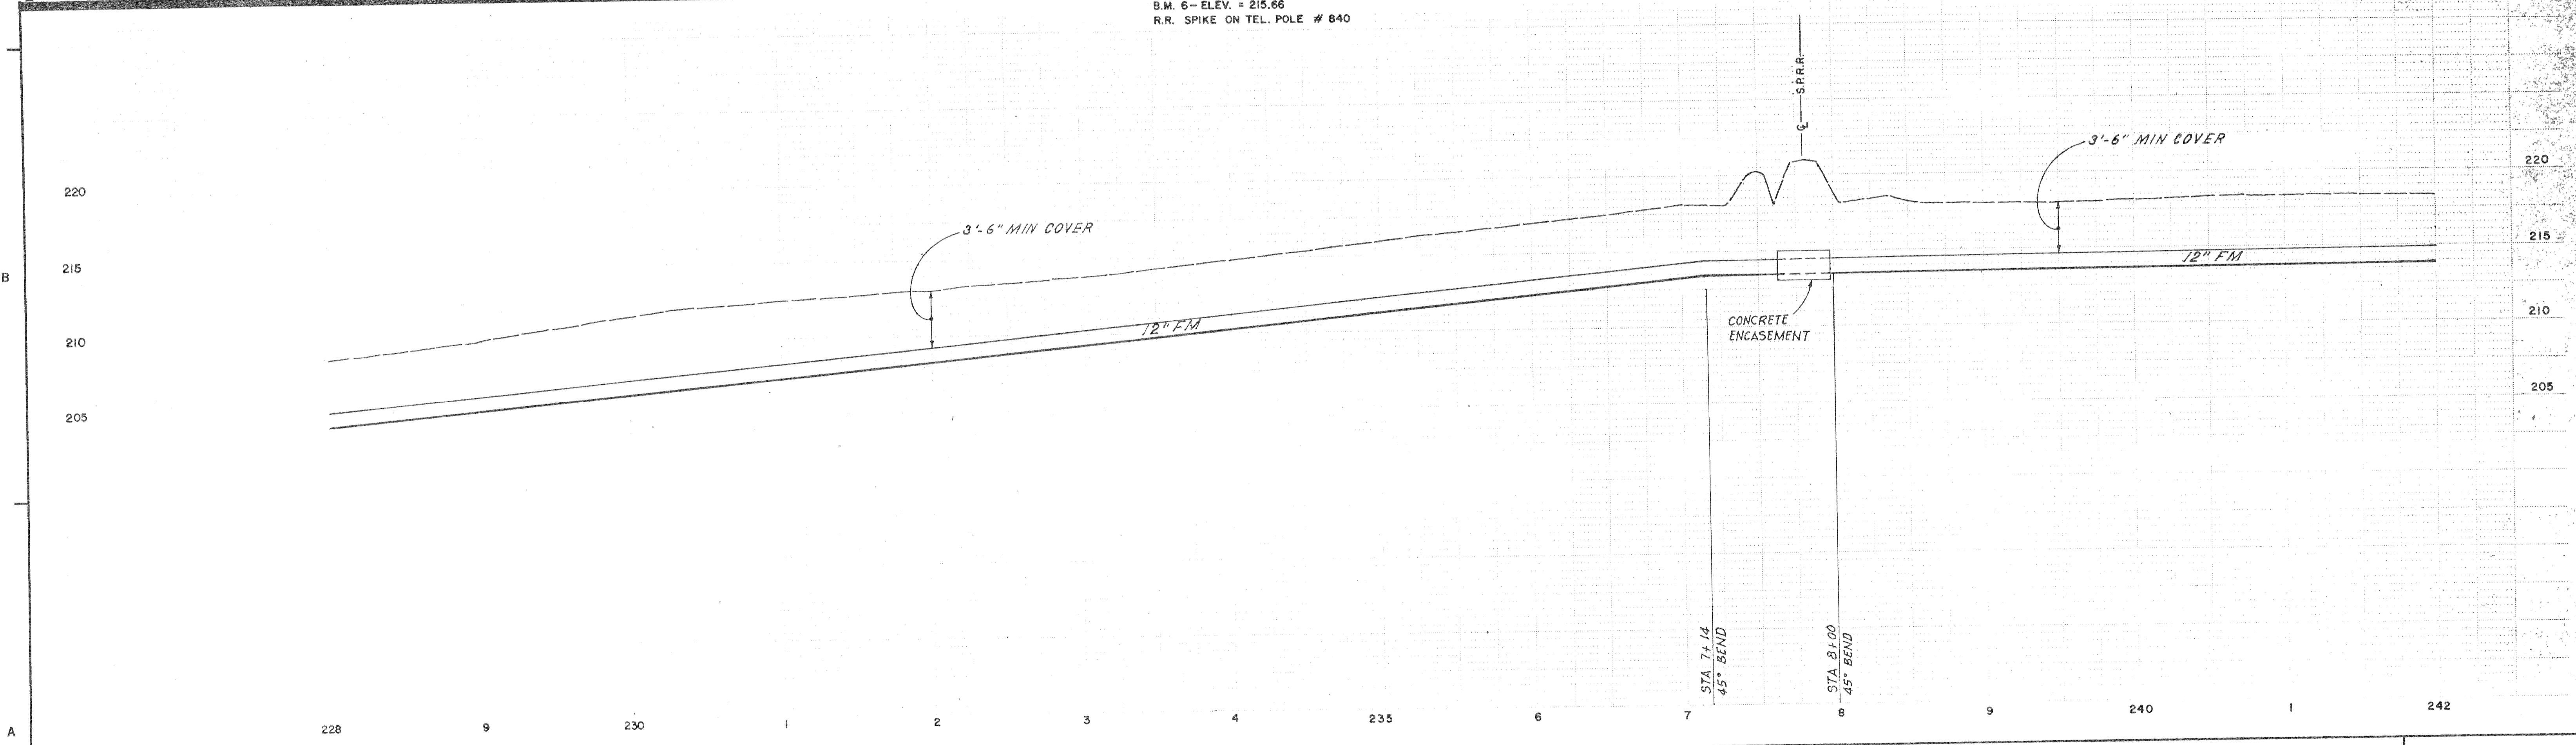

DRAWN BY <i>[Signature]</i> DEPT. CHECK PROJ. CHECK <i>[Signature]</i>				<b>M&amp;E</b> METCALF & EDDY, INC. ENGINEERS BOSTON • NEW YORK • PALO ALTO • CHICAGO		SCALE: HORIZONTAL 1" = 50' VERTICAL 1" = 5'		PACIFIC COAST PRODUCERS GROVILLE, CALIFORNIA INDUSTRIAL WASTEWATER TREATMENT & DISPOSAL FACILITIES FORCE MAIN - PLAN AND PROFILE STA 228+00 TO STA 242+00		JOB: _____ FILE NO. _____ SHEET C-14											
REVISIONS <table border="1"> <thead> <tr> <th>NUMBER</th> <th>DATE</th> <th>MADE BY</th> <th>CHECKED BY</th> <th>DESCRIPTION</th> </tr> </thead> <tbody> <tr> <td> </td> <td> </td> <td> </td> <td> </td> <td> </td> </tr> </tbody> </table>				NUMBER	DATE	MADE BY	CHECKED BY	DESCRIPTION						REG. PROF. ENGR. <i>[Signature]</i> REG. PROF. ENGR.		DATE 8/29/70		UNLESS OTHERWISE NOTED OR CHANGED BY REPRODUCTION		1 55-318	
NUMBER	DATE	MADE BY	CHECKED BY	DESCRIPTION																	