



THE EXISTENCE AND LOCATION OF ALL UTILITIES SHALL BE VERIFIED BY THE CONTRACTOR

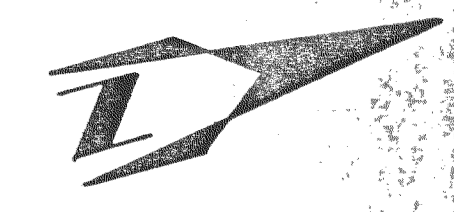

B.M. 7 - ELEV. = 206.61
R.R. SPIKE ON POWER POLE # 25

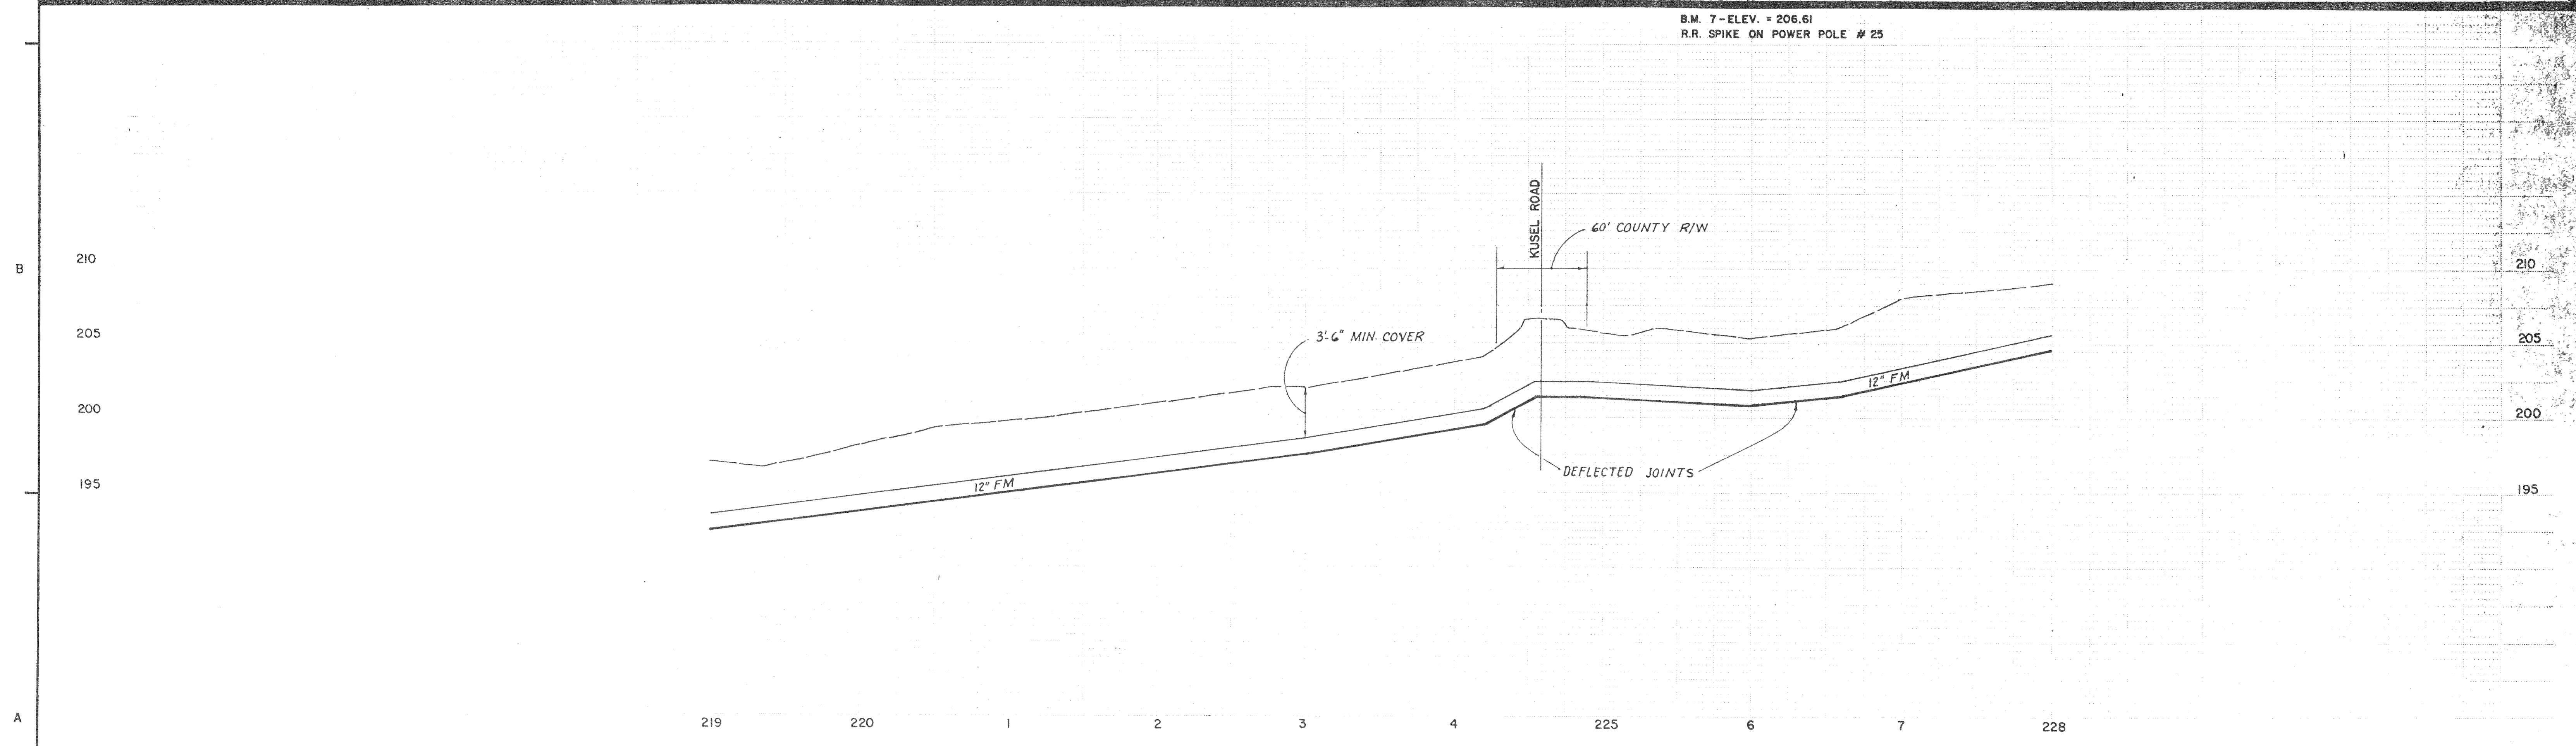


NUMBER	DATE	MADE BY	CHECKED BY	REVISIONS	DESCRIPTION

DRAWN BY
DCC

DEPT. CHECK

PROJ. CHECK
R. Smith

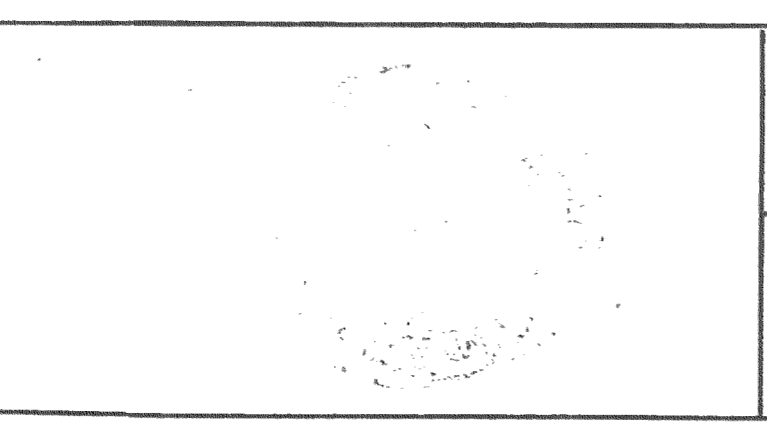

M&E METCALF & EDDY, INC. ENGINEERS
BOSTON • NEW YORK • PALO ALTO • CHICAGO

REG. PROF. ENGR. *Charles E. Powell* DATE *8/30/74*
REG. PROF. ENGR. *DYE*

SCALE:
HORIZONTAL 1" = 50'
VERTICAL 1" = 5'

UNLESS OTHERWISE NOTED OR CHANGED BY REPRODUCTION

PACIFIC COAST PRODUCERS
OROVILLE, CALIFORNIA
INDUSTRIAL WASTEWATER TREATMENT & DISPOSAL FACILITIES

FORCE MAIN - PLAN AND PROFILE
STA 219+00 TO STA 228+00

JOB _____
FILE NO. _____
SHEET C-13