



THE EXISTENCE AND LOCATION OF ALL UTILITIES SHALL BE VERIFIED BY THE CONTRACTOR

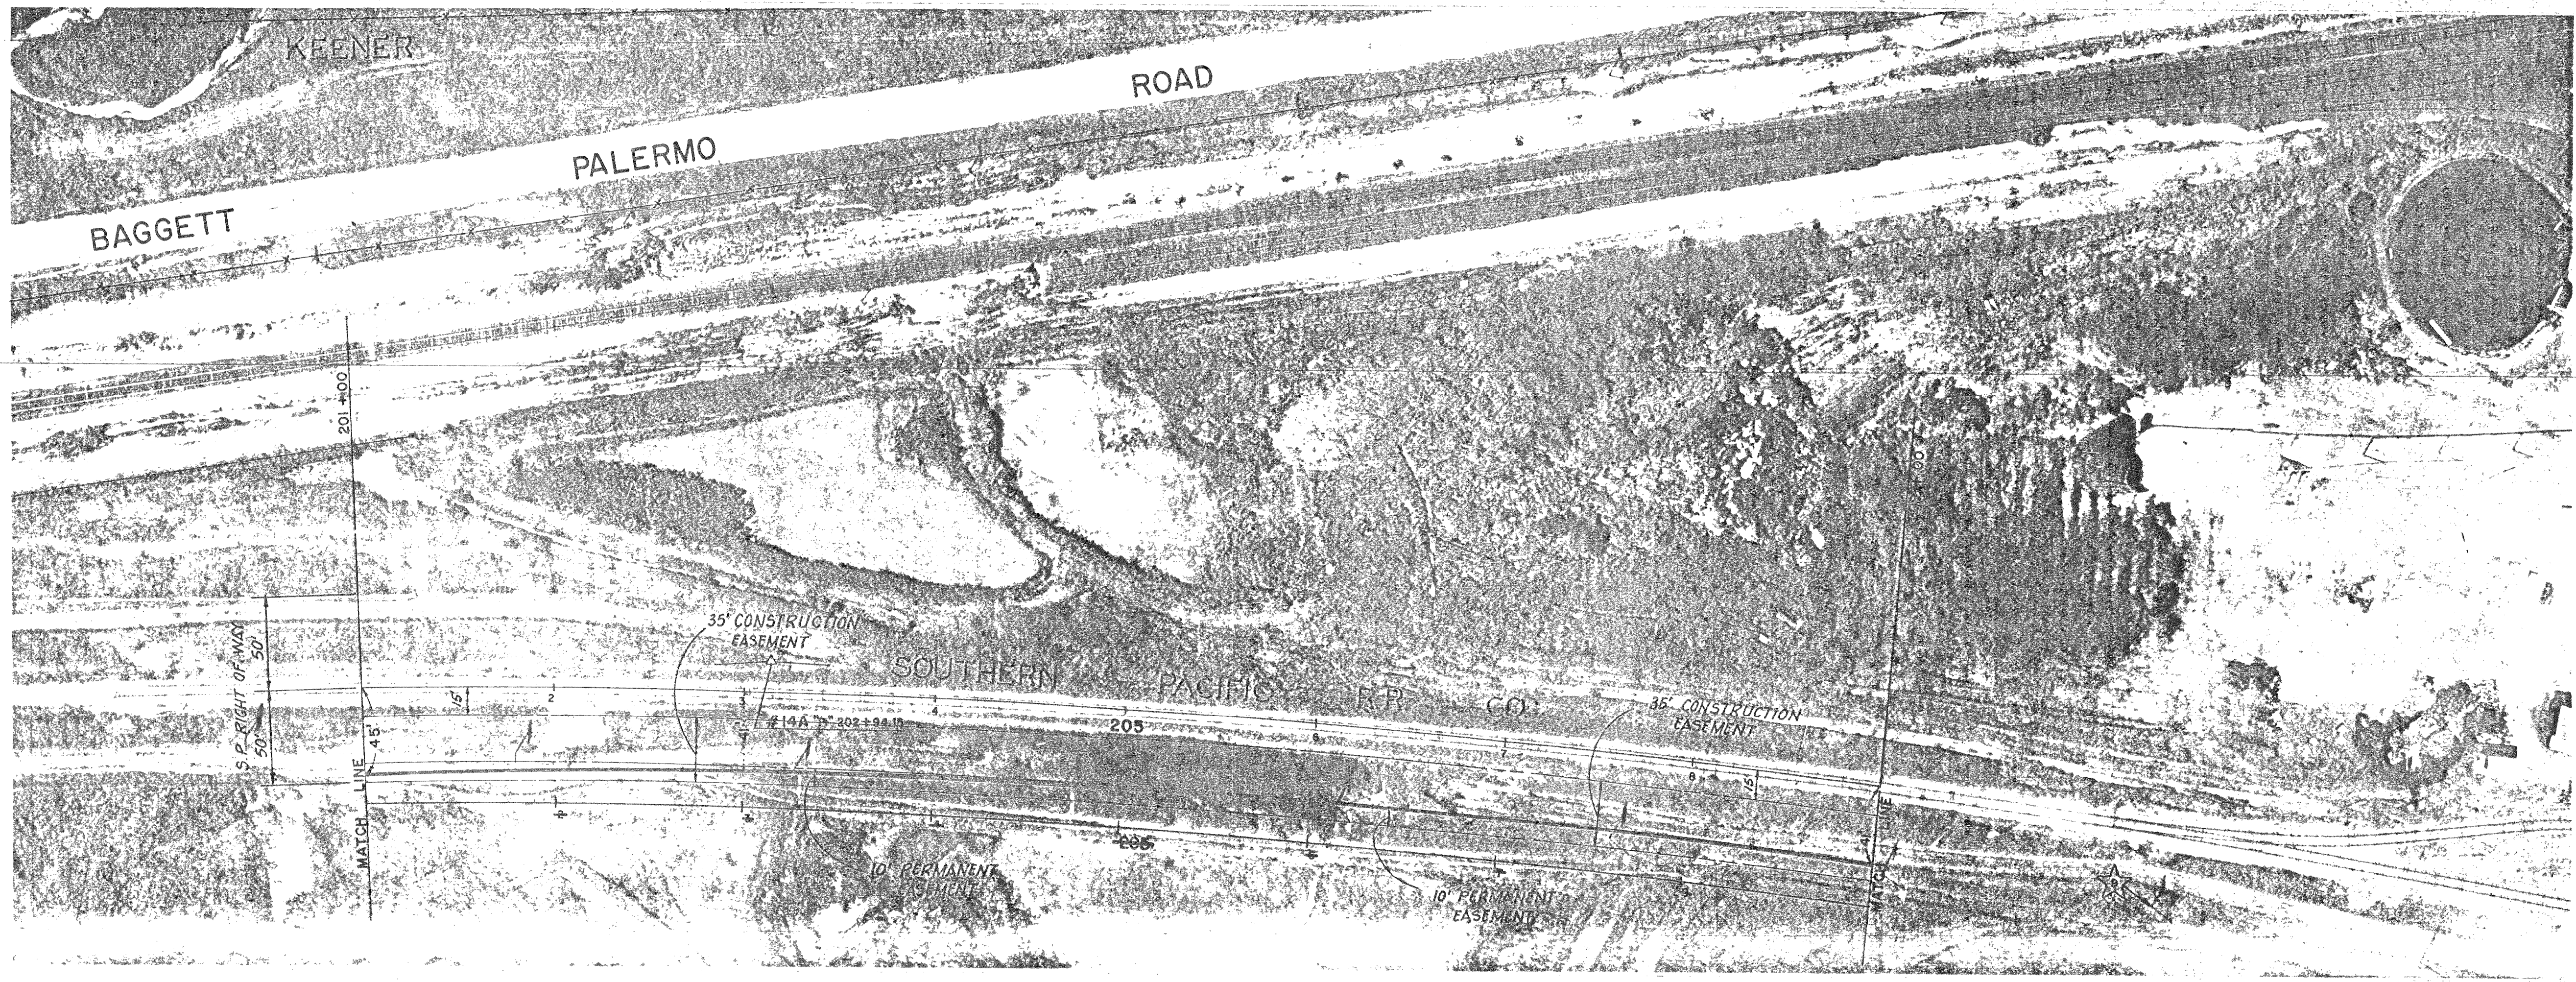

B.M. 9 - ELEV. = 193.60
R.R. SPIKE ON TEL. POLE #823

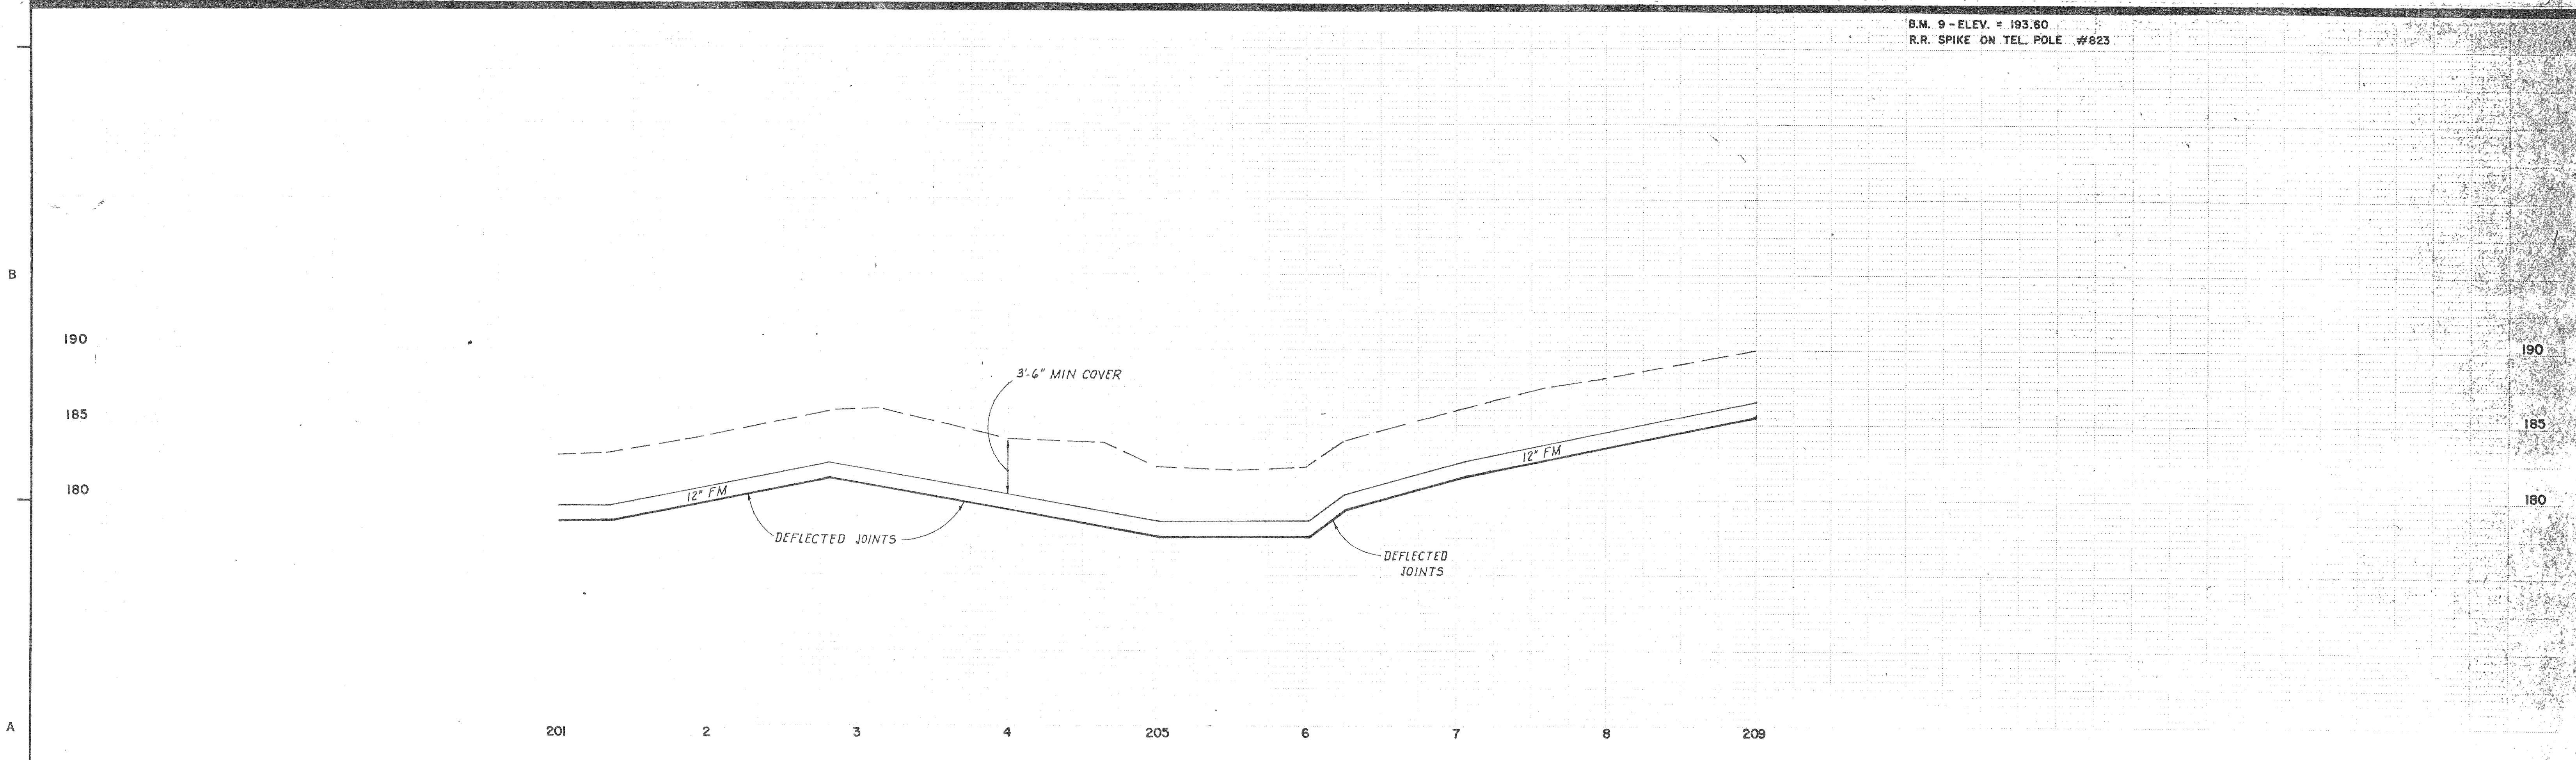


NUMBER	DATE	MADE BY	CHECKED BY	DESCRIPTION

DRAWN BY
W. Cantimban

DEPT. CHECK

PROJ. CHECK
R. Smith

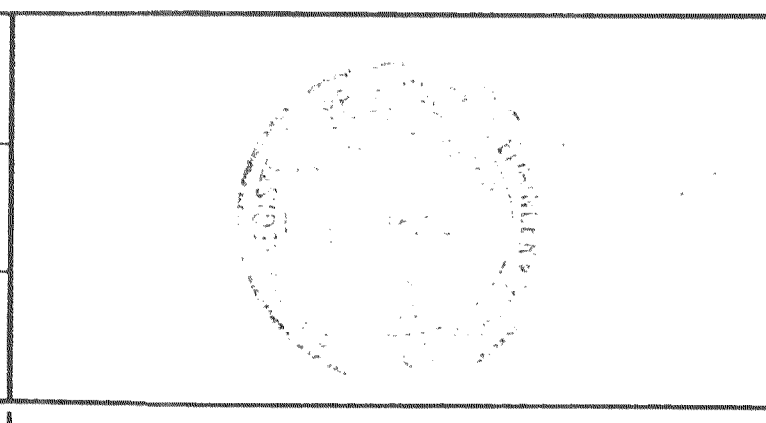

M&E METCALF & EDDY, INC. | ENGINEERS
BOSTON • NEW YORK • PALO ALTO • CHICAGO

REG. PROF. ENGR.
Charles E. Howard
REG. PROF. ENGR.

DATE
8/30/74
DATE

SCALE:

HORIZONTAL 1" = 50'

VERTICAL 1" = 5'

UNLESS OTHERWISE NOTED OR CHANGED BY REPRODUCTION

PACIFIC COAST PRODUCERS
ORVILLE, CALIFORNIA
INDUSTRIAL WASTEWATER TREATMENT & DISPOSAL FACILITIES

FORCE MAIN - PLAN AND PROFILE
STA 201+00 TO STA 209+00

JOB _____

FILE NO. _____

SHEET C-11