

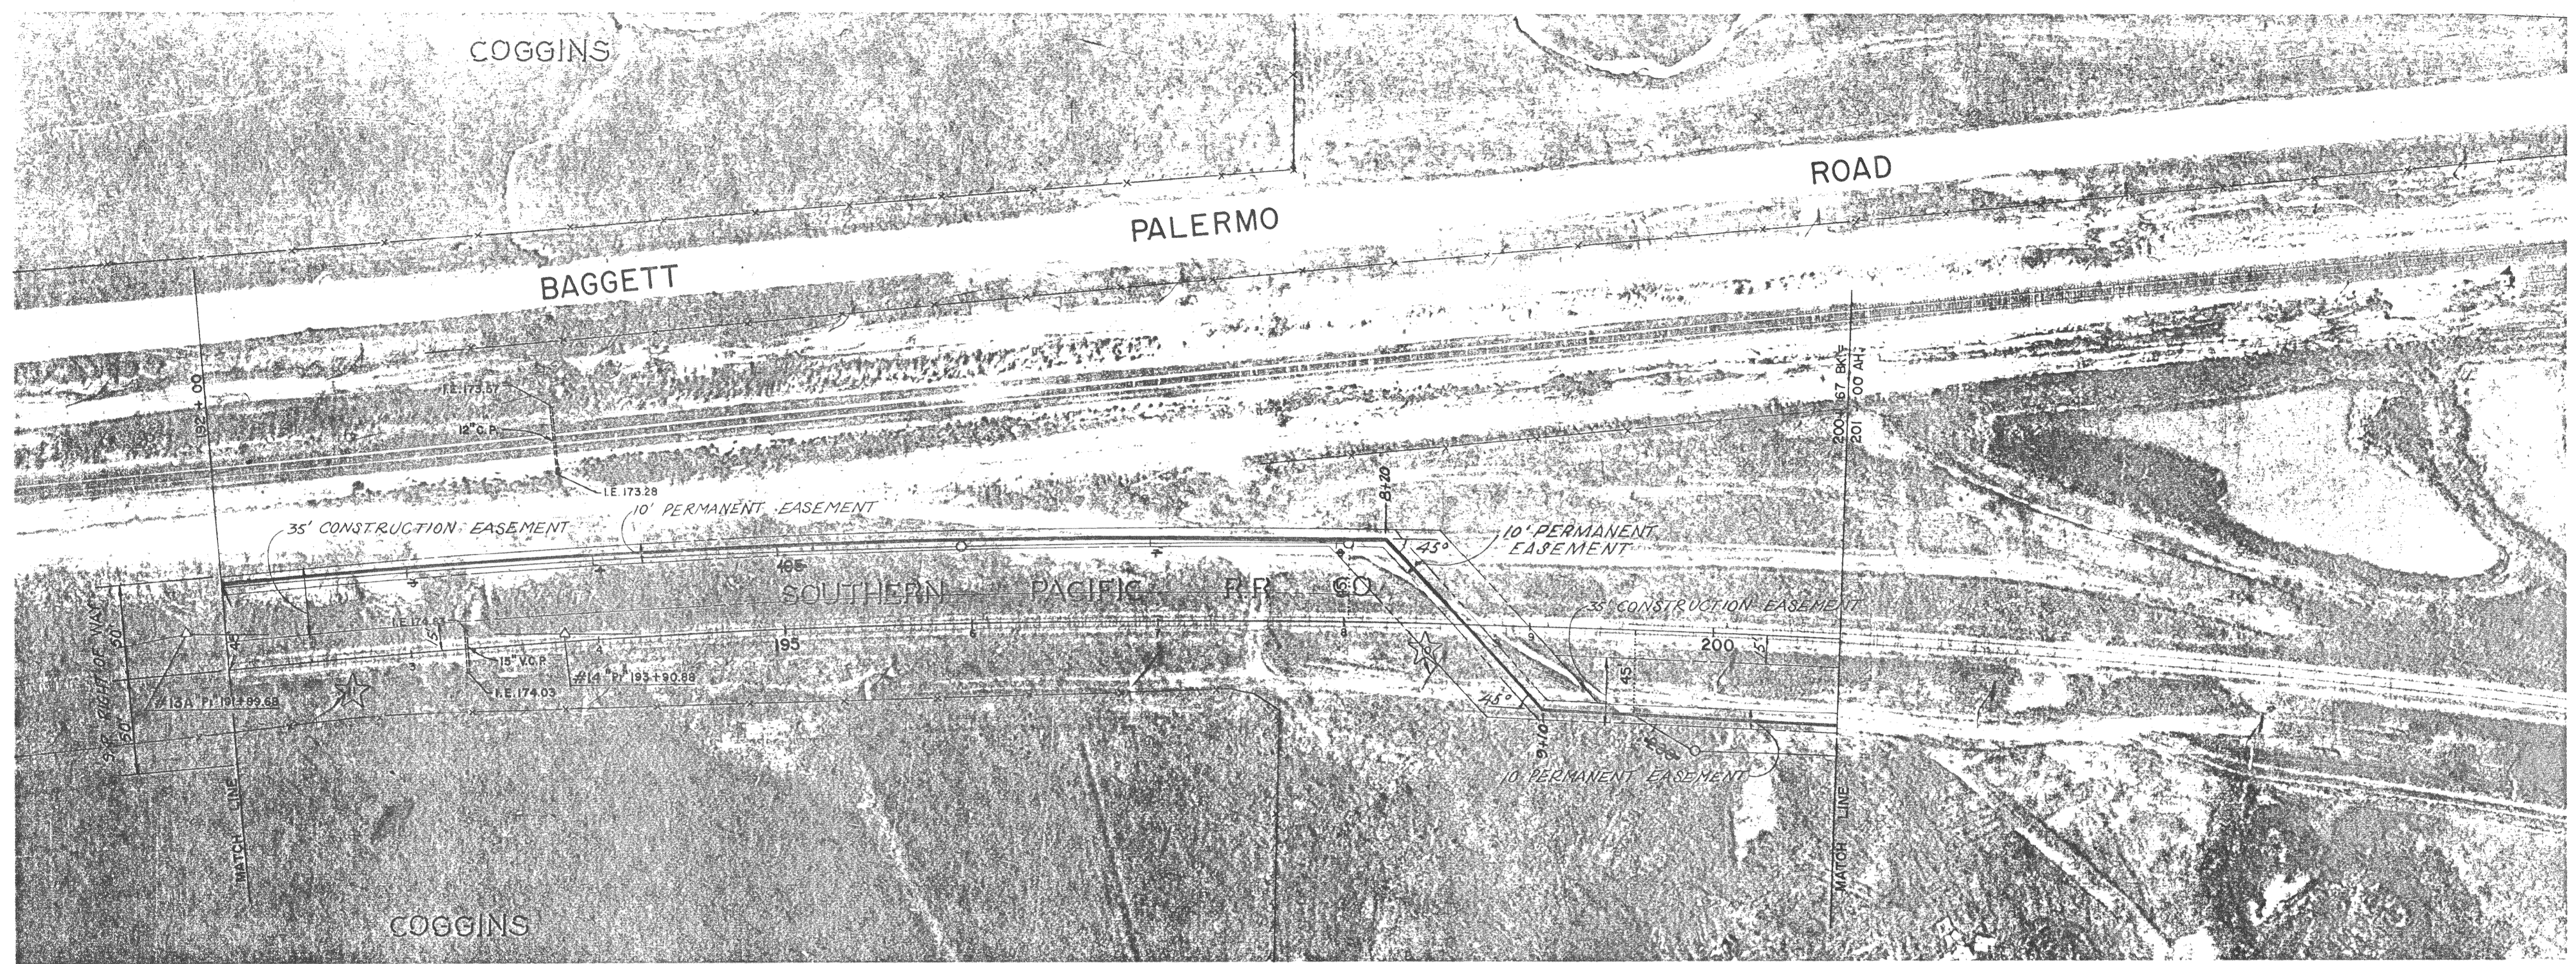


THE EXISTENCE AND LOCATION OF ALL UTILITIES SHALL BE VERIFIED BY THE CONTRACTOR.

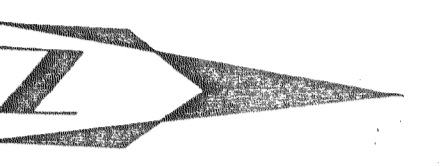


B.M. 11 - ELEV. = 179.63
R.R. SPIKE ON TEL. POLE #811

B.M. 10 - ELEV. = 183.43
R.R. SPIKE ON TEL. POLE #815

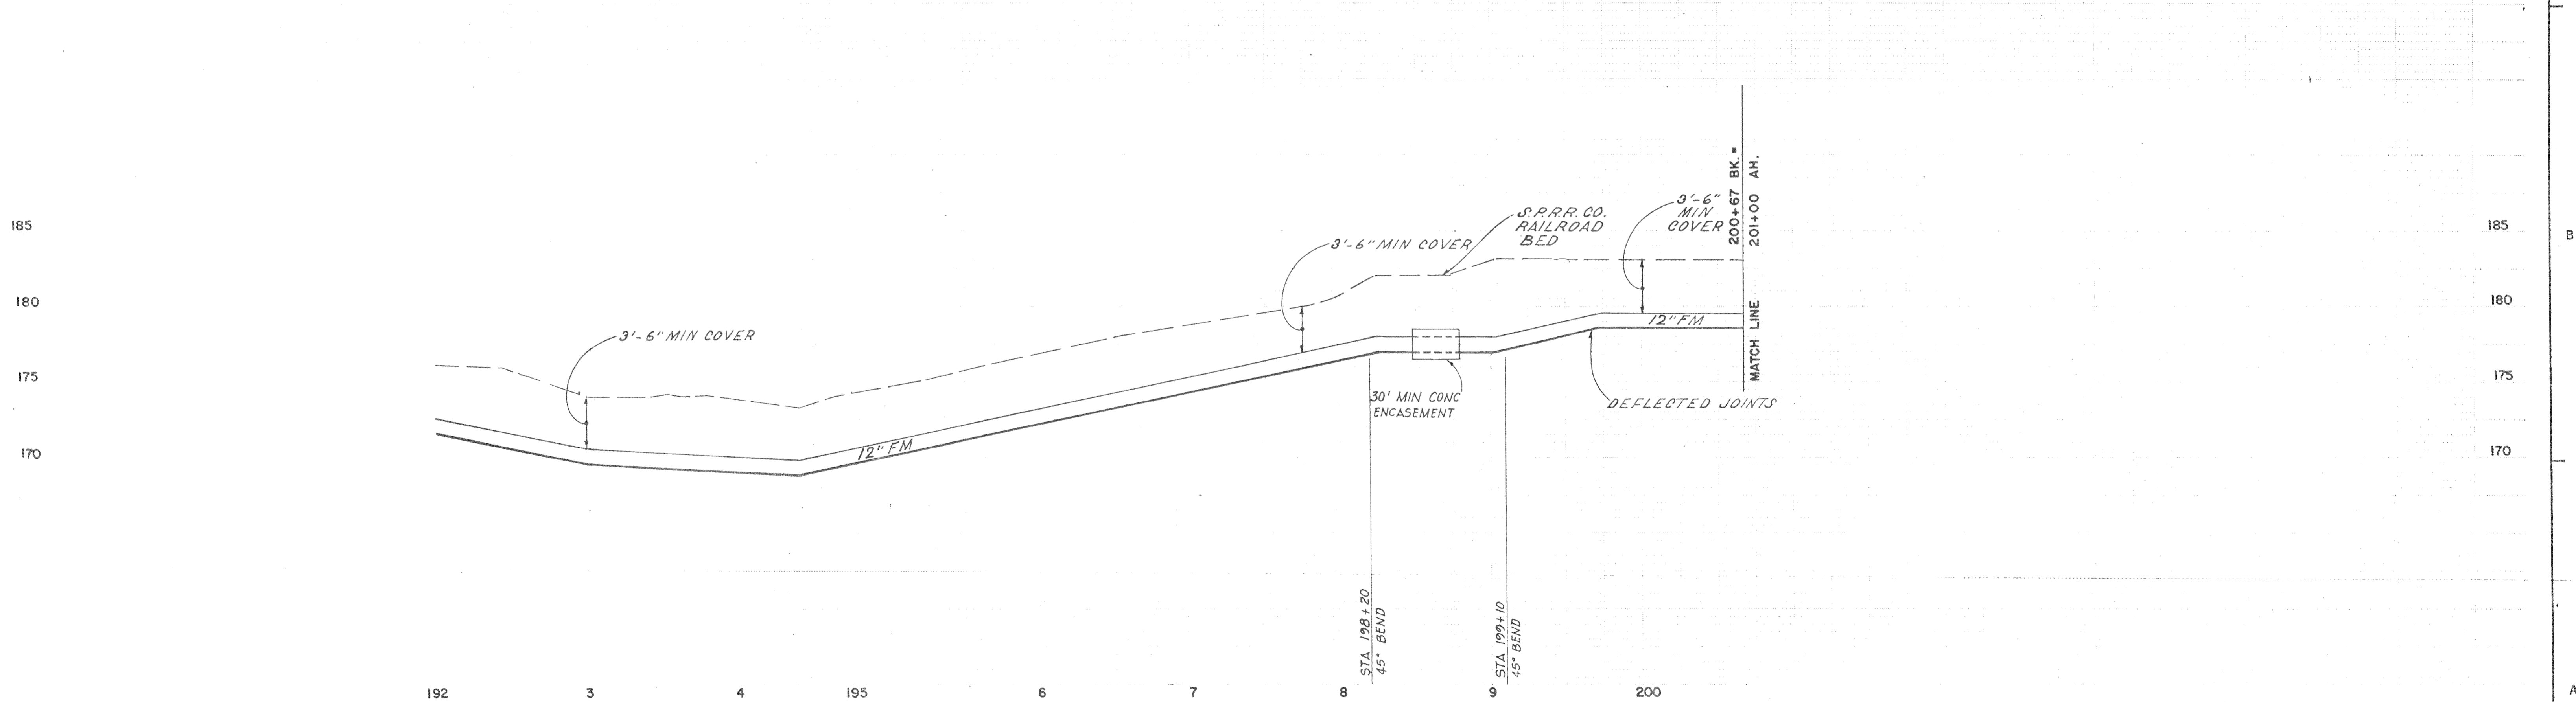

NUMBER	DATE	MADE BY	CHECKED BY	DESCRIPTION

DRAWN BY
[Signature]
DEPT. CHECK
PROJ. CHECK
[Signature]

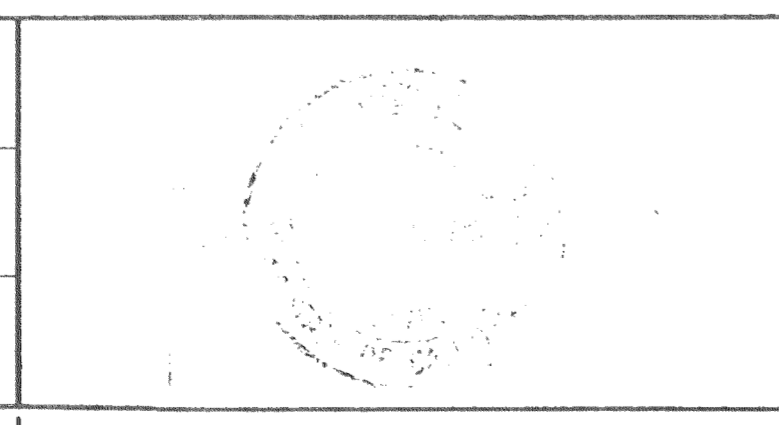

M&E METCALF & EDDY, INC. ENGINEERS
BOSTON • NEW YORK • PALO ALTO • CHICAGO

REG. PROF. ENGR. *[Signature]* DATE *9/30/74*
REG. PROF. ENGR. DATE

SCALE:
HORIZONTAL 1" = 50'
VERTICAL 1" = 5'

UNLESS OTHERWISE NOTED OR CHANGED BY REPRODUCTION

PACIFIC COAST PRODUCERS
DROVILLE, CALIFORNIA
INDUSTRIAL WASTEWATER TREATMENT & DISPOSAL FACILITIES
FORCE MAIN - PLAN AND PROFILE
STA 192+00 TO STA 201+00

JOB _____
FILE NO. _____
SHEET C-10