


WITCH - ELEV = 185.41 B.M. JUNKIE ELEV. = 194.79 HAZEL - ELEV = 189.20 PATTY - ELEV = 193.67
 R.R. SPIKE IN PP.

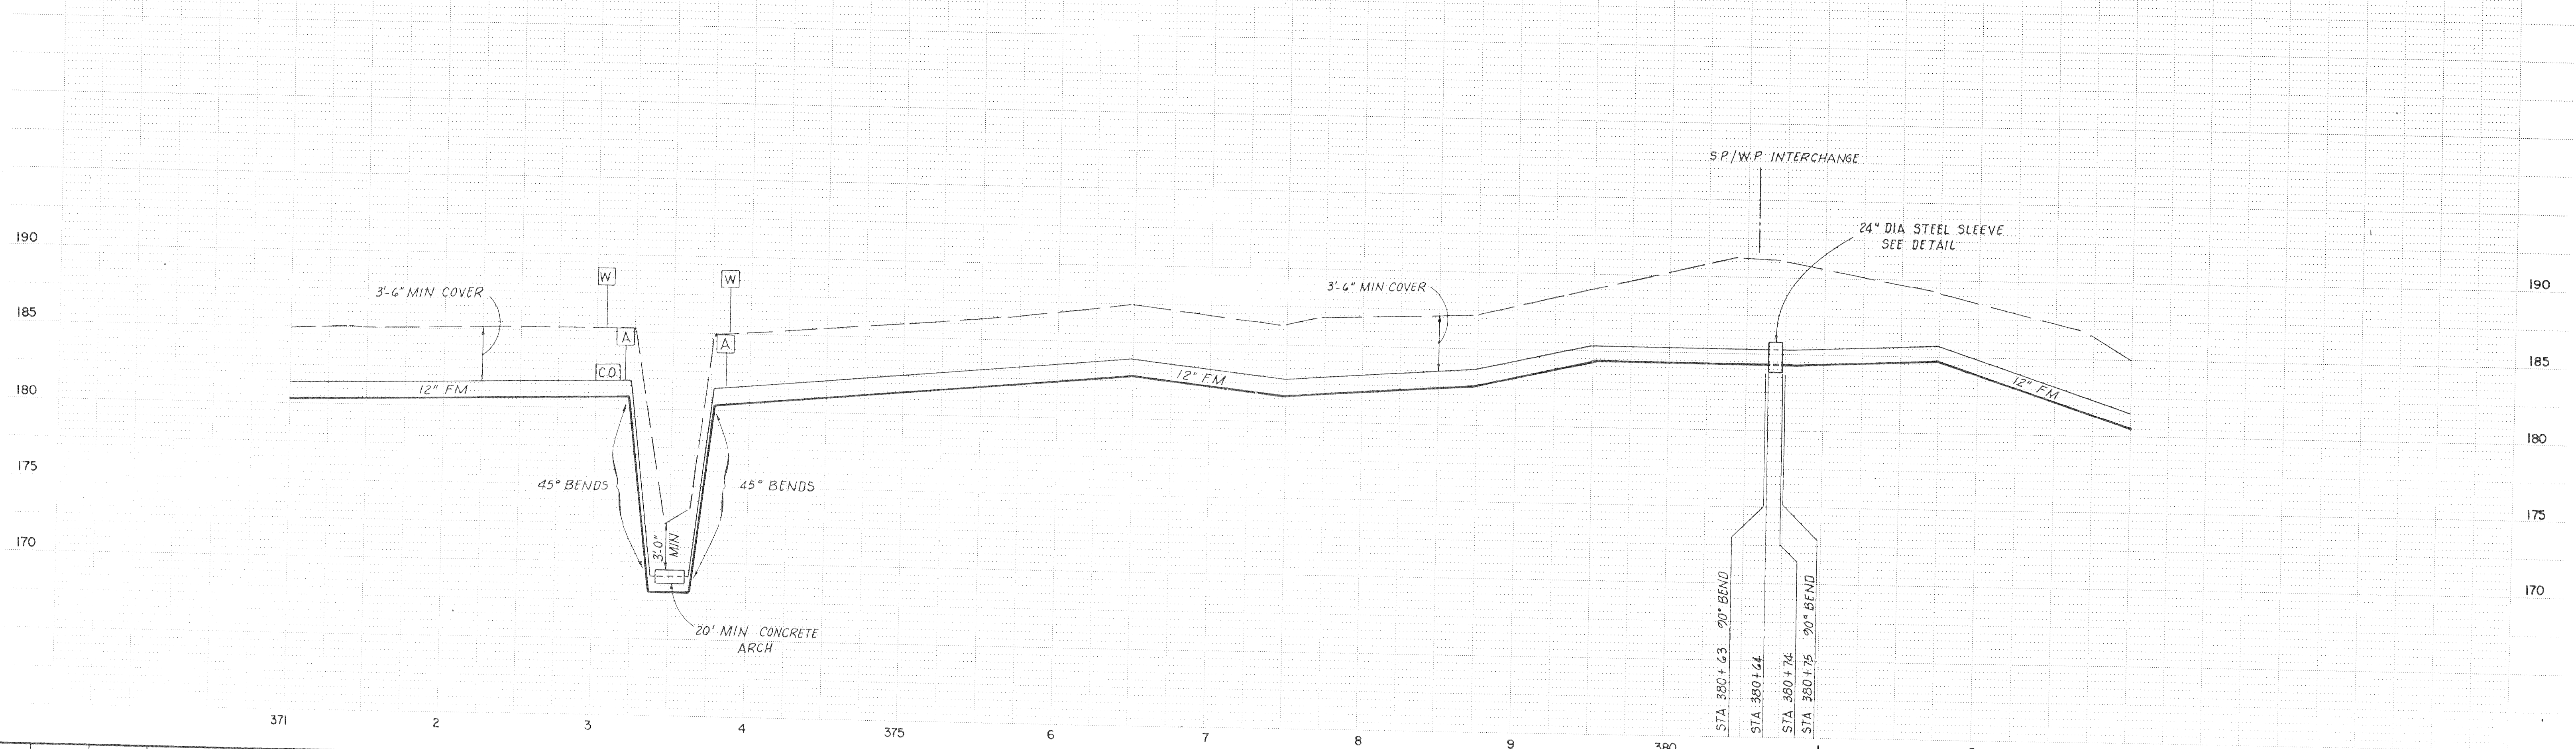

NUMBER	DATE	MADE BY	CHECKED BY	DESCRIPTION
REVISIONS				

DRAWN BY
R. Cantimbuhan
 DEPT. CHECK
 PROJ. CHECK
R. Smith

M&E METCALF & EDDY, INC. ENGINEERS
 BOSTON • NEW YORK • PALO ALTO • CHICAGO

REG. PROF. ENGR. *Charles E. Paul* DATE 8/20/14
 REG. PROF. ENGR. DATE

SCALE:
 HORIZONTAL 1" = 50'
 VERTICAL 1" = 5'

PACIFIC COAST PRODUCERS
 OROVILLE, CALIFORNIA
 INDUSTRIAL WASTEWATER TREATMENT & DISPOSAL FACILITIES
 FORCE MAIN - PLAN AND PROFILE
 STA 371+00 TO STA 383+00

JOB: _____
 FILE NO. _____
 SHEET C-26