


SUE - ELEV. = 179.37

WITCH - ELEV. = 185.41

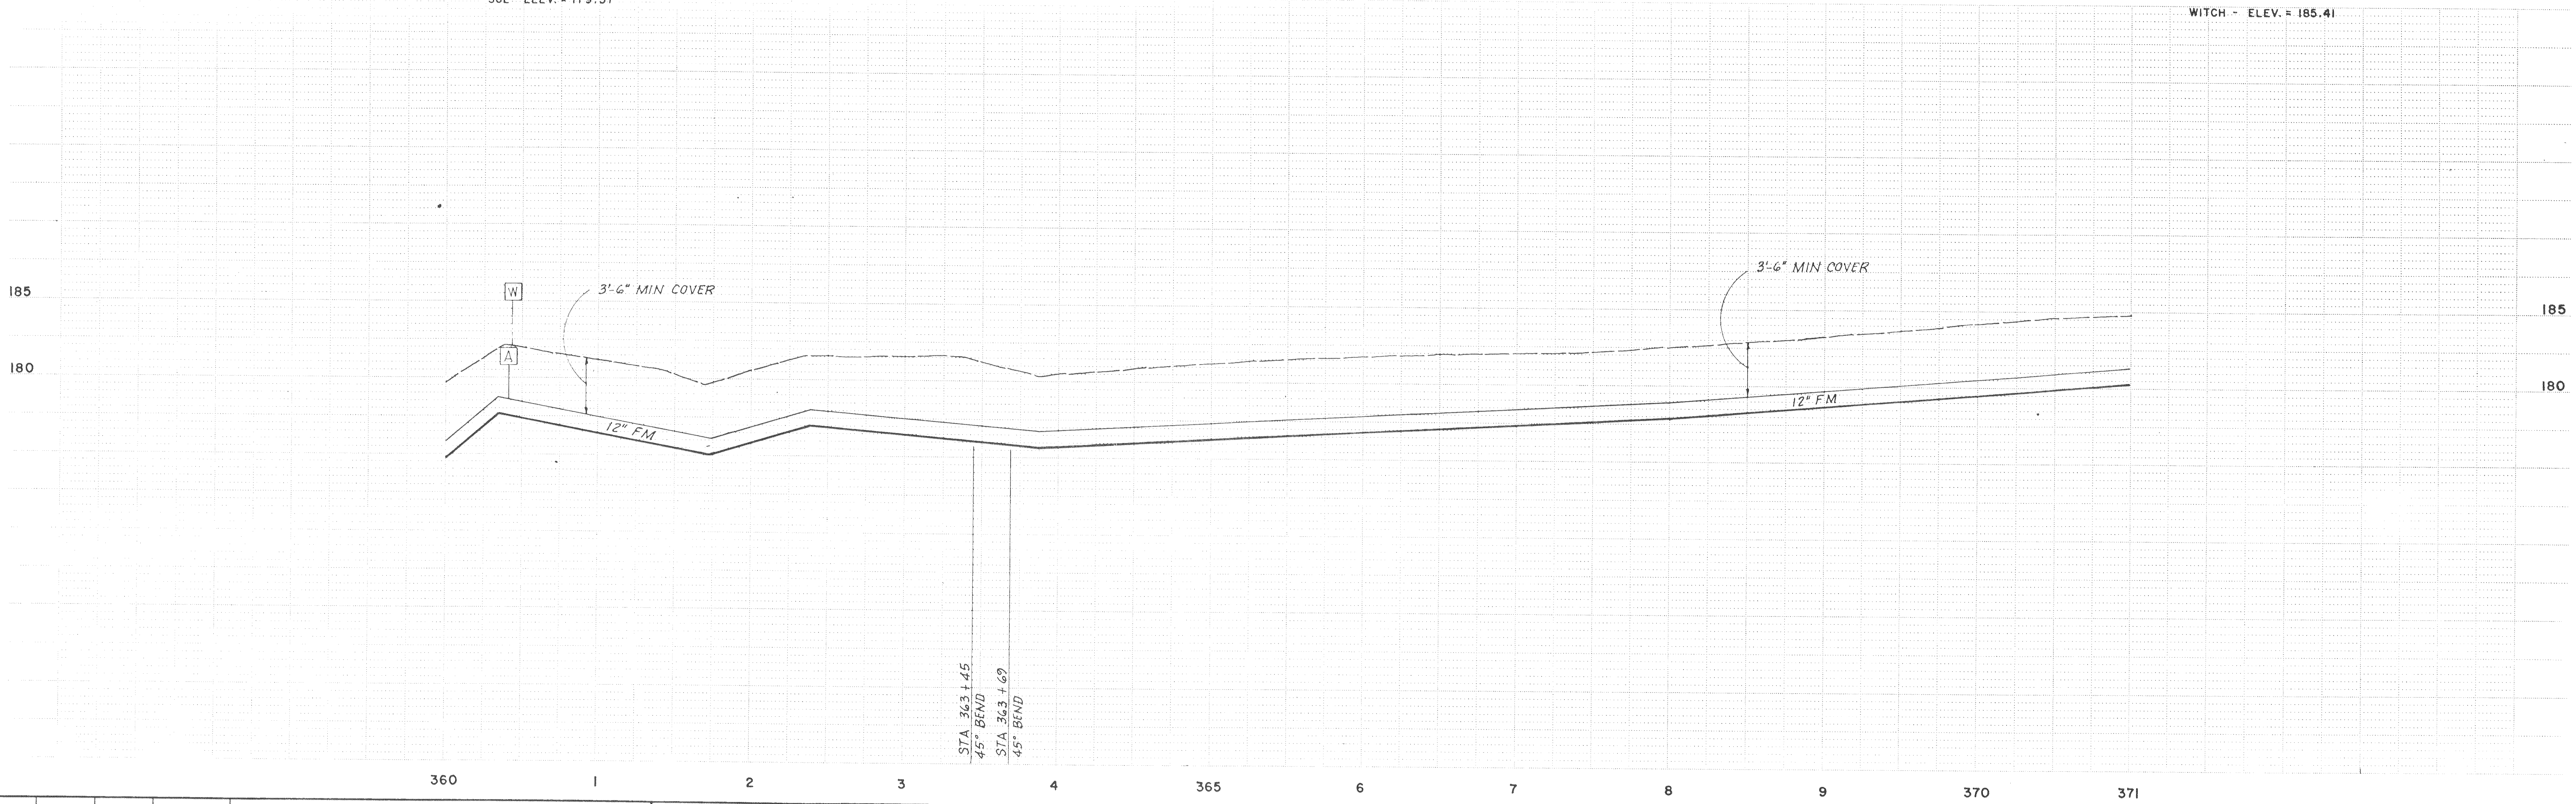


STA 363.45
45° BEND
STA 363.69
45° BEND

NUMBER	DATE	MADE BY	CHECKED BY	DESCRIPTION

DRAWN BY
DCCanluban

DEPT. CHECK

PROJ. CHECK
[Signature]

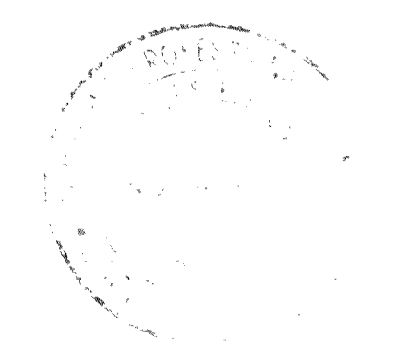

M&E METCALF & EDDY, INC. | ENGINEERS
BOSTON • NEW YORK • PALO ALTO • CHICAGO

REG. PROF. ENGR.
Charles E. Pared

DATE
8/30/14

SCALE:

UNLESS OTHERWISE NOTED OR CHANGED BY REPRODUCTION

PACIFIC COAST PRODUCERS
ORVILLE, CALIFORNIA

INDUSTRIAL WASTEWATER TREATMENT & DISPOSAL FACILITIES

FORCE MAIN - PLAN AND PROFILE
STA 360+00 TO STA 371+00

JOB: _____

FILE NO: _____

SHEET C-25

55-316