


OLIVE GLEN LIFT STATION

City of Oroville


FOR TECHNICAL INFORMATION CONTACT THE FOLLOWING:

CIVIL/GENERAL	COOK ASSOCIATES, OROVILLE (916) 533-6457	TOM KUYKENDALL
ELECTRICAL	ED FARMER & ASSOC., SACRAMENTO (916) 443-8842	DAVE ARCHANGELO

SHEET INDEX	
No.	Sheet Title
1	TITLE SHEET
2	GENERAL ARRANGEMENT
3	PLAN AT BASE OF WET & DRY PITS
4	GENERAL SECTION
5	SECTION THRU WET WELL
6	MISCELLANEOUS DETAILS
7	PUMP & PIPING ARRANGEMENT
8	E1 ELECTRICAL DETAILS
9	E2 CONTROL BUILDING
10	E3 GENERATOR & SYMBOLS
11	E4 WIRING DETAILS

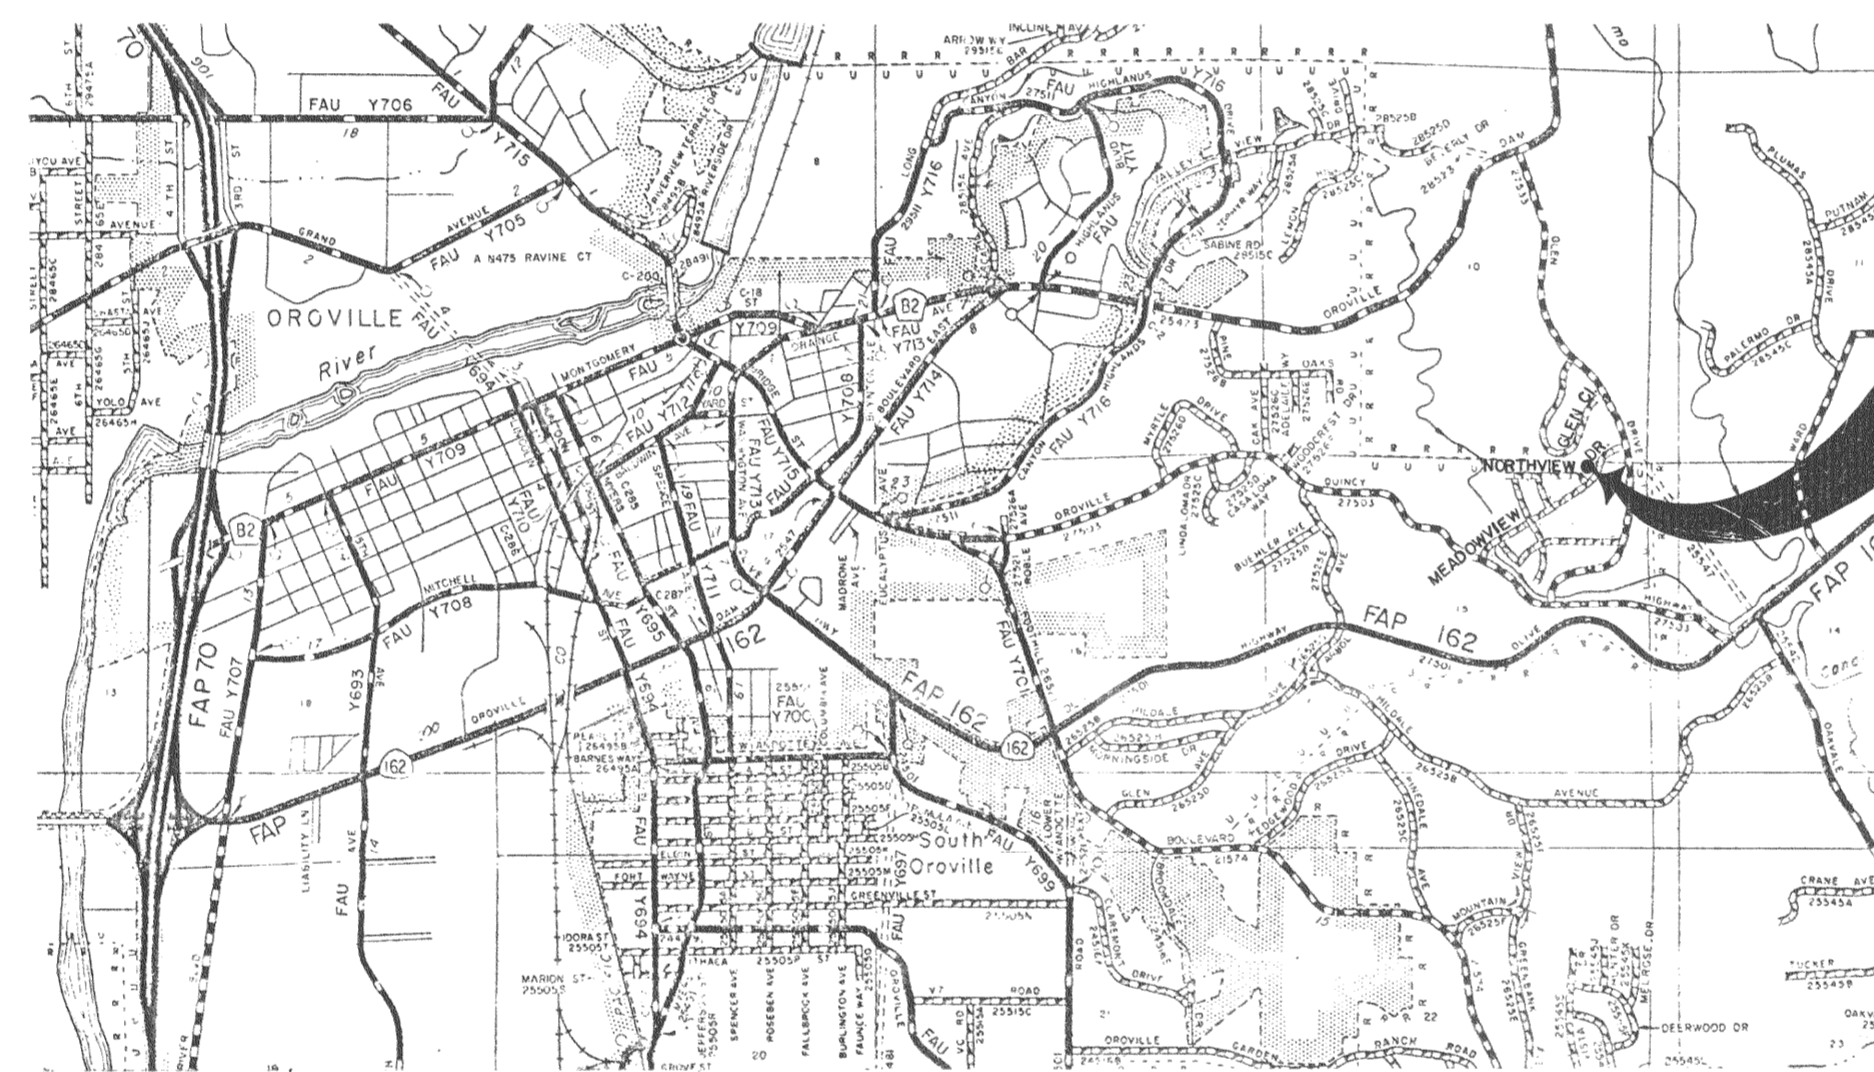

(A) LOCATION MAP CITY OF OROVILLE
NO. SCALE

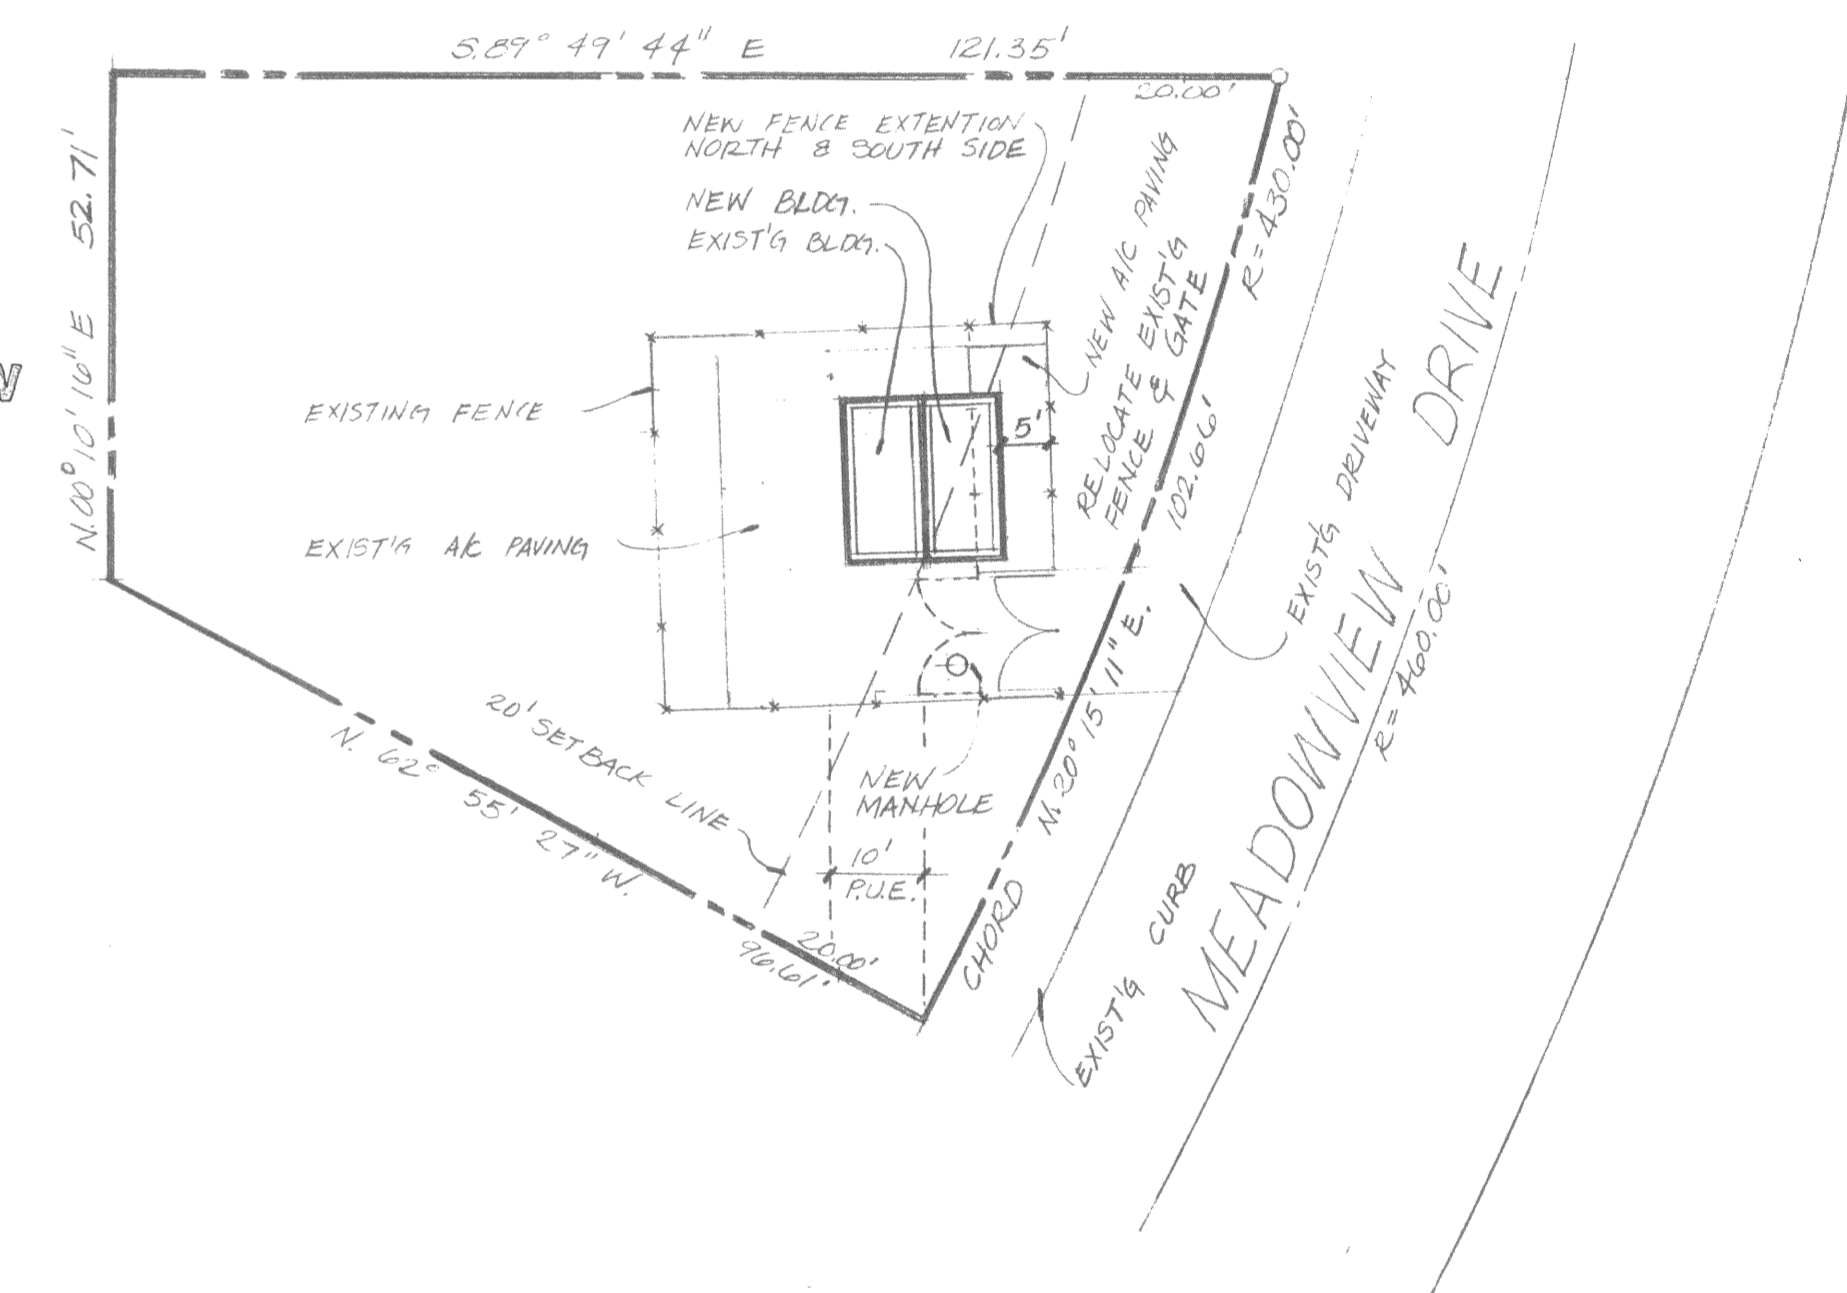

(B) SITE PLAN
1" = 20'-0"

SUBMITTED:


Dan J. Cook
DAN J. COOK R.C.E. 13062
8-26-81

APPROVED:

Kirt M. Hunter
Kirt M. Hunter R.C.E. 21762
9-16-81




RECEIVED JULY 81
 JULY 81
 AUG 81
 11
 82465
 55-295

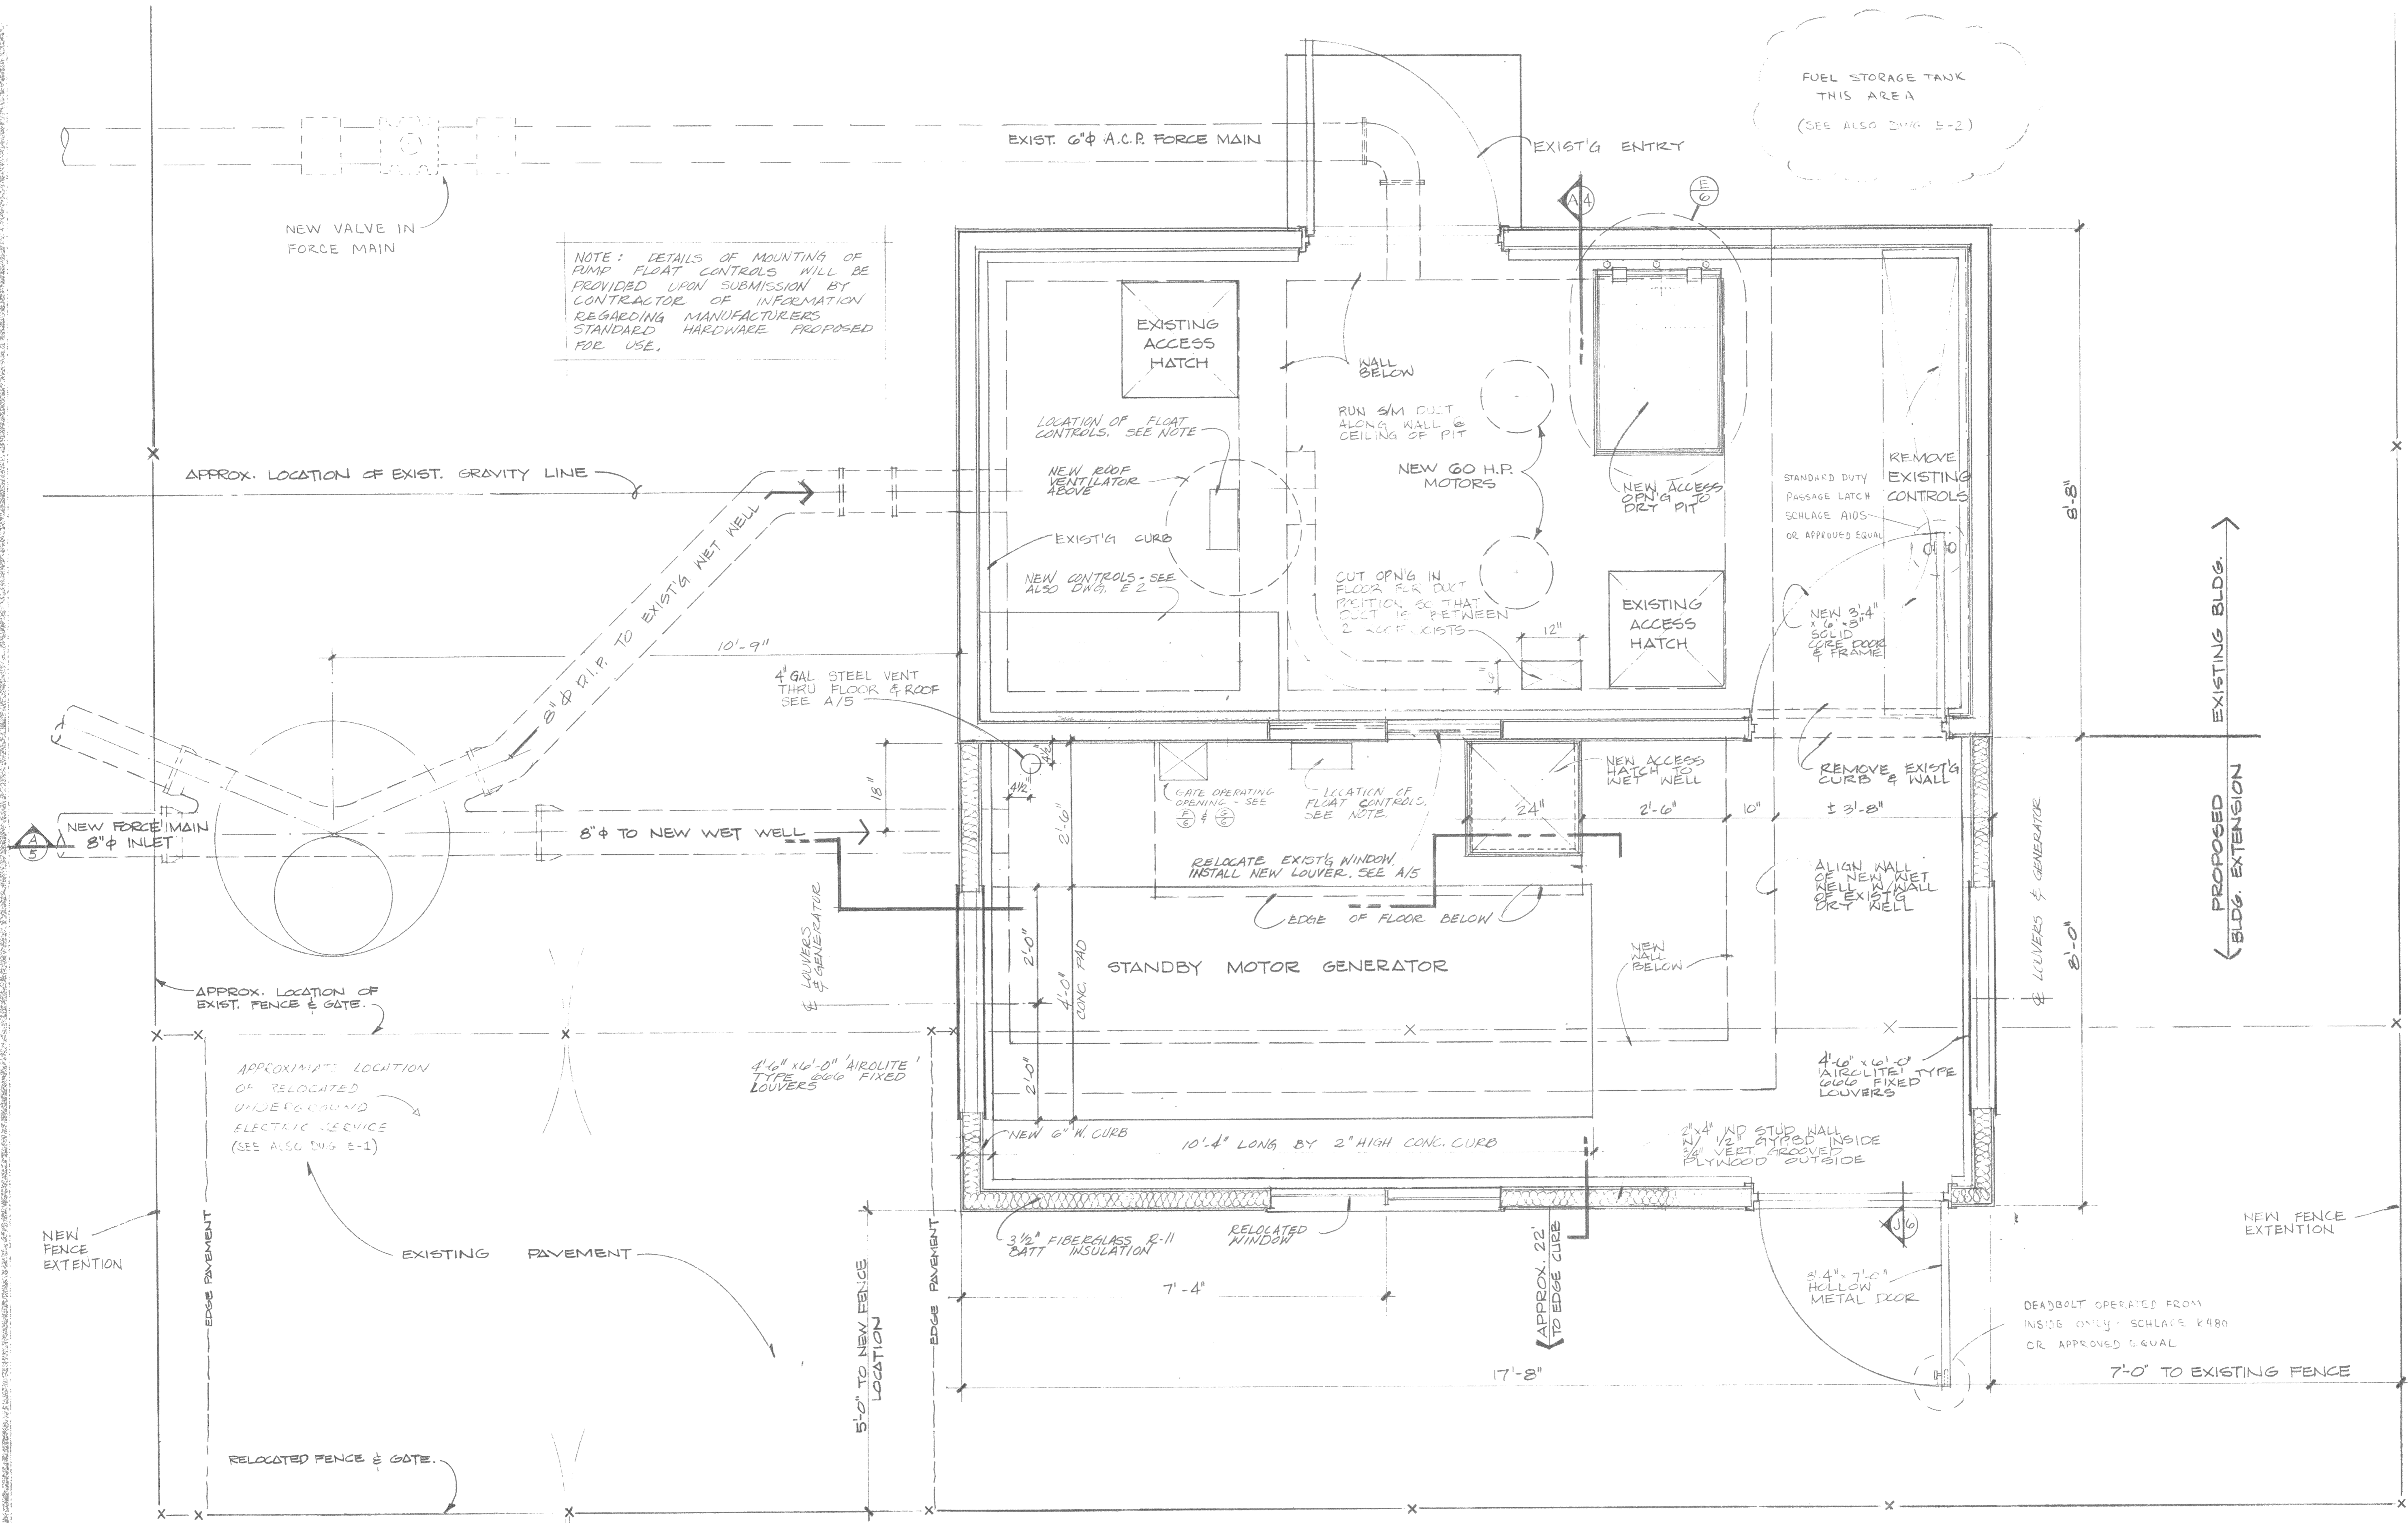

NOTE: DETAILS OF MOUNTING OF PUMP FLOAT CONTROLS WILL BE PROVIDED UPON SUBMISSION BY CONTRACTOR OF INFORMATION REGARDING MANUFACTURERS STANDARD HARDWARE PROPOSED FOR USE.


FUEL STORAGE TANK THIS AREA (SEE ALSO DWG E-2)

1 LIFT STATION PLAN VIEW
2 3/4" = 1'-0"



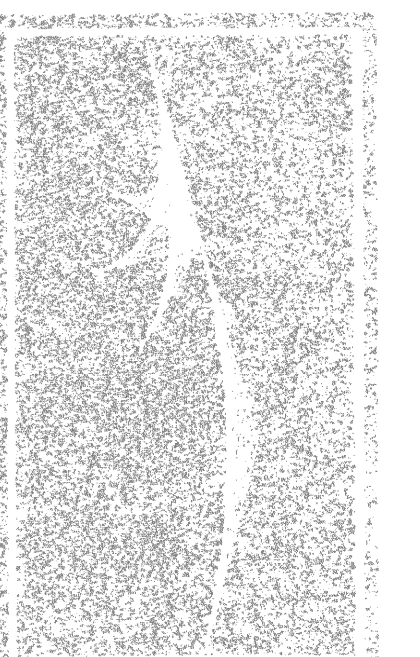


COOK ASSOCIATES, INC.
ENGINEERING CONSULTANTS
3810 MARK AVENUE, SUITE 100, CHICAGO, ILL. 60641

CITY OF OROVILLE
OLIVE GLEN LIFT STATION
GENERAL ARRANGEMENT

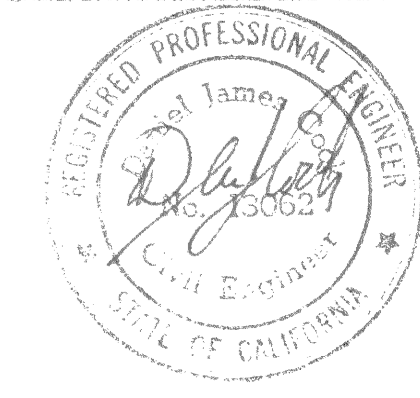

DATE: JULY 21
SCALE: AS SHOWN
PROJECT: AX-E-1
DRAWING: A-452
SHEET NO. 2
80465

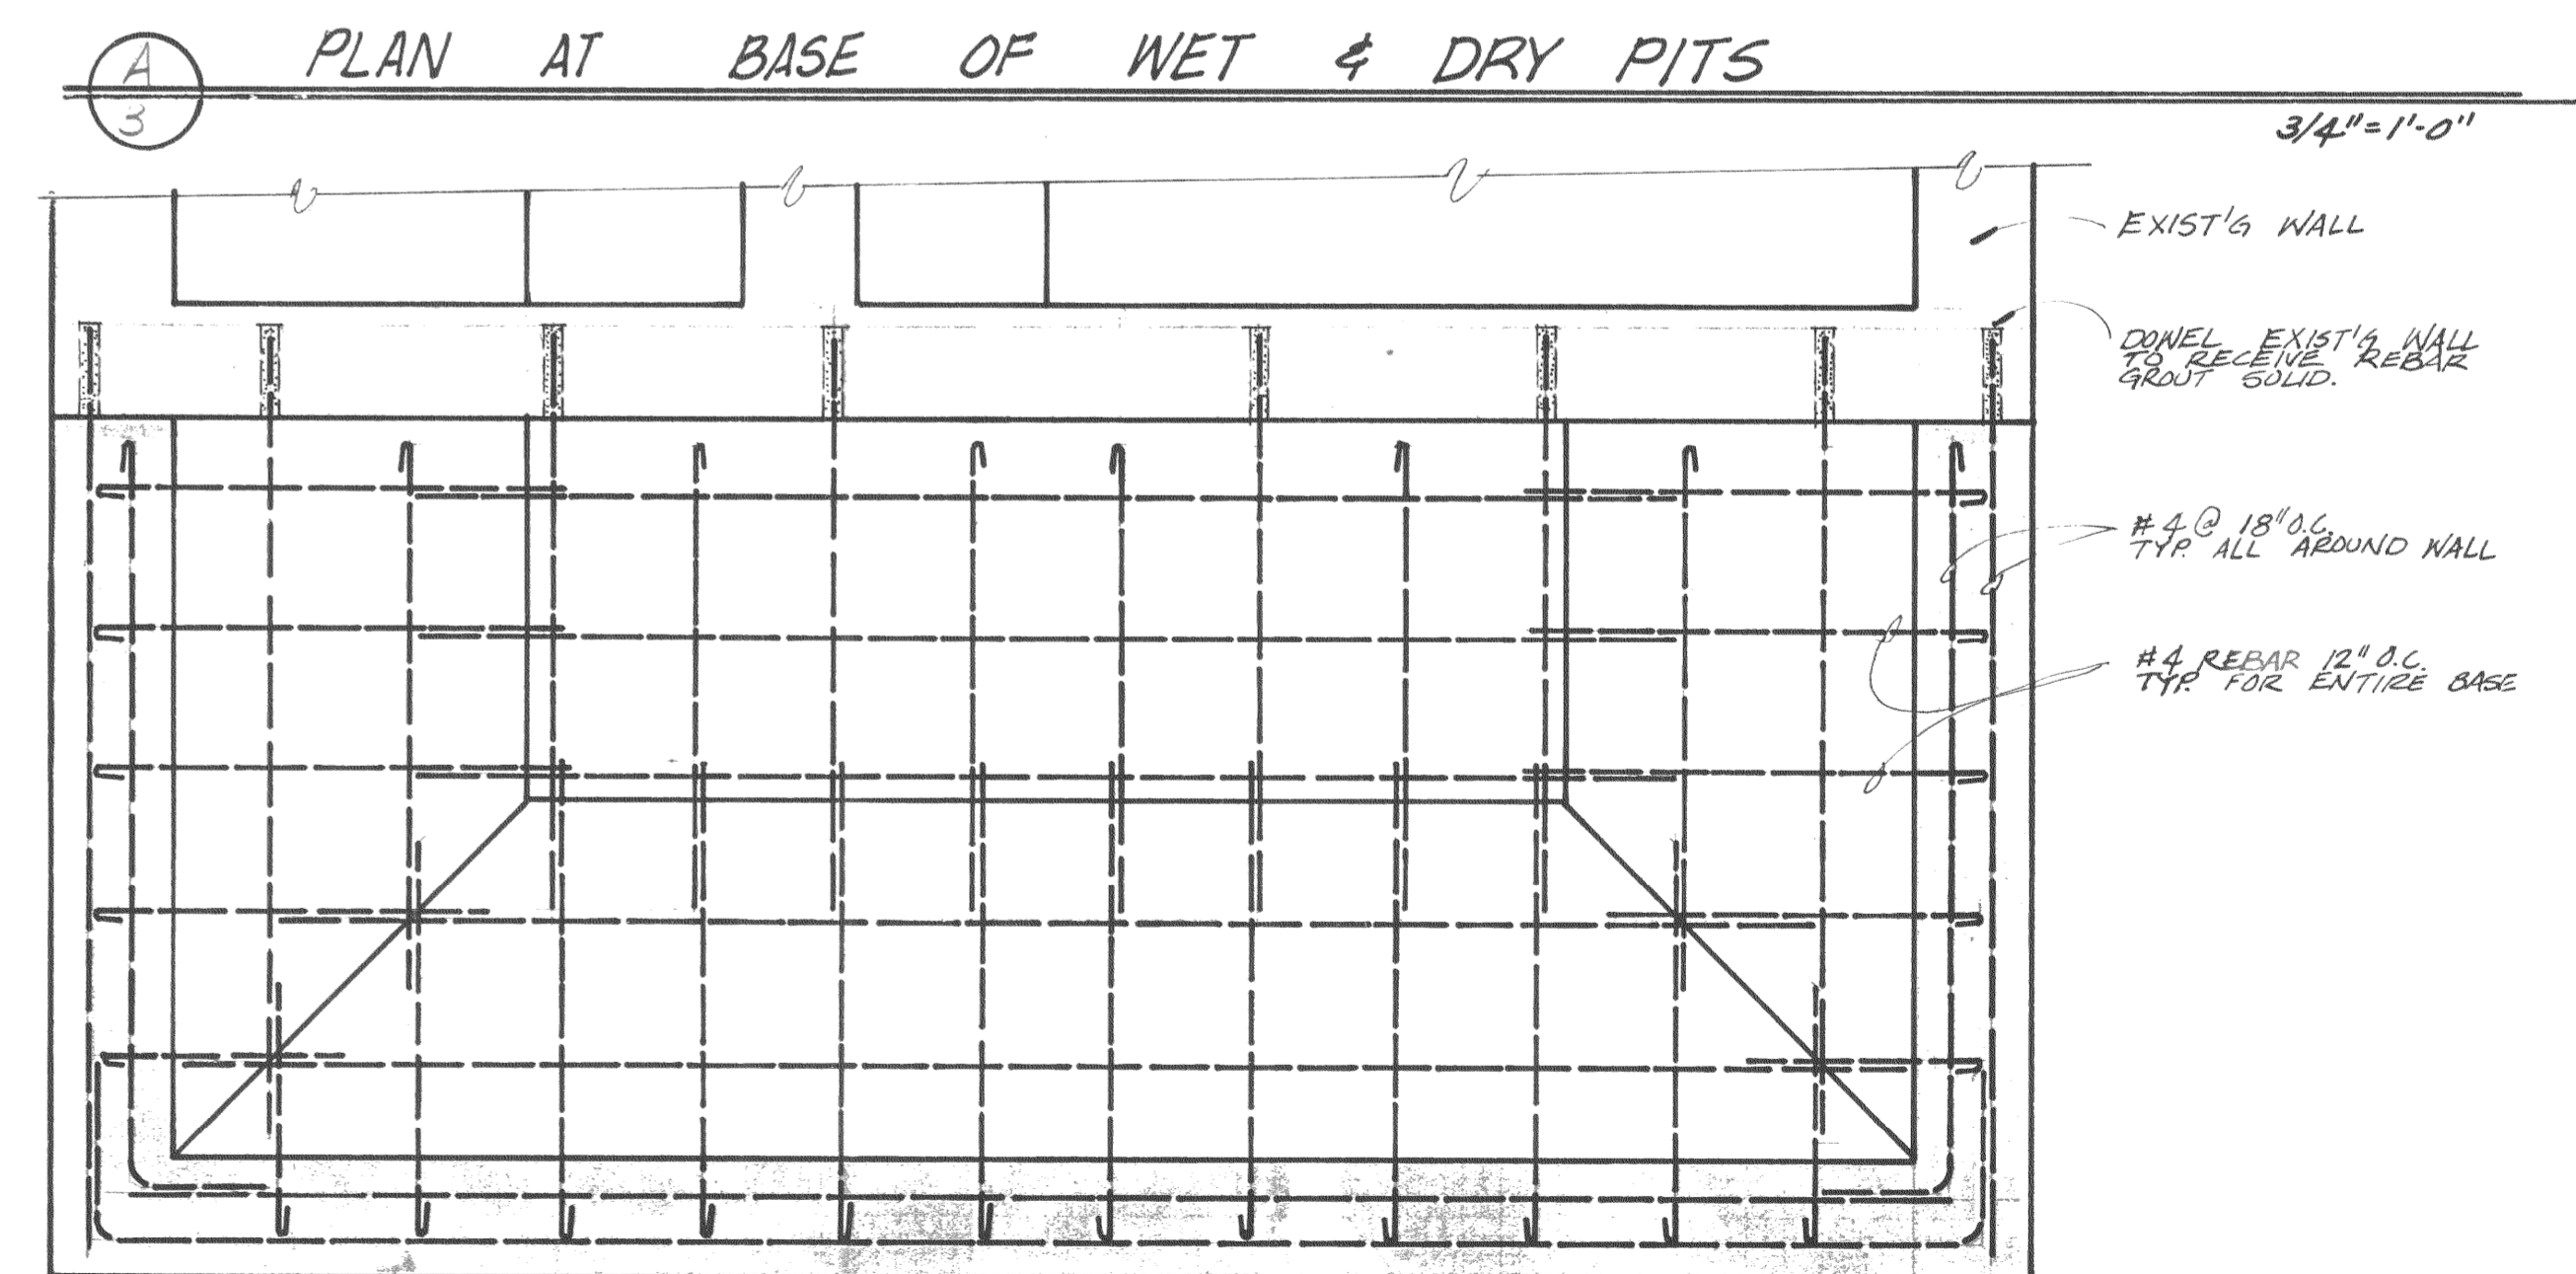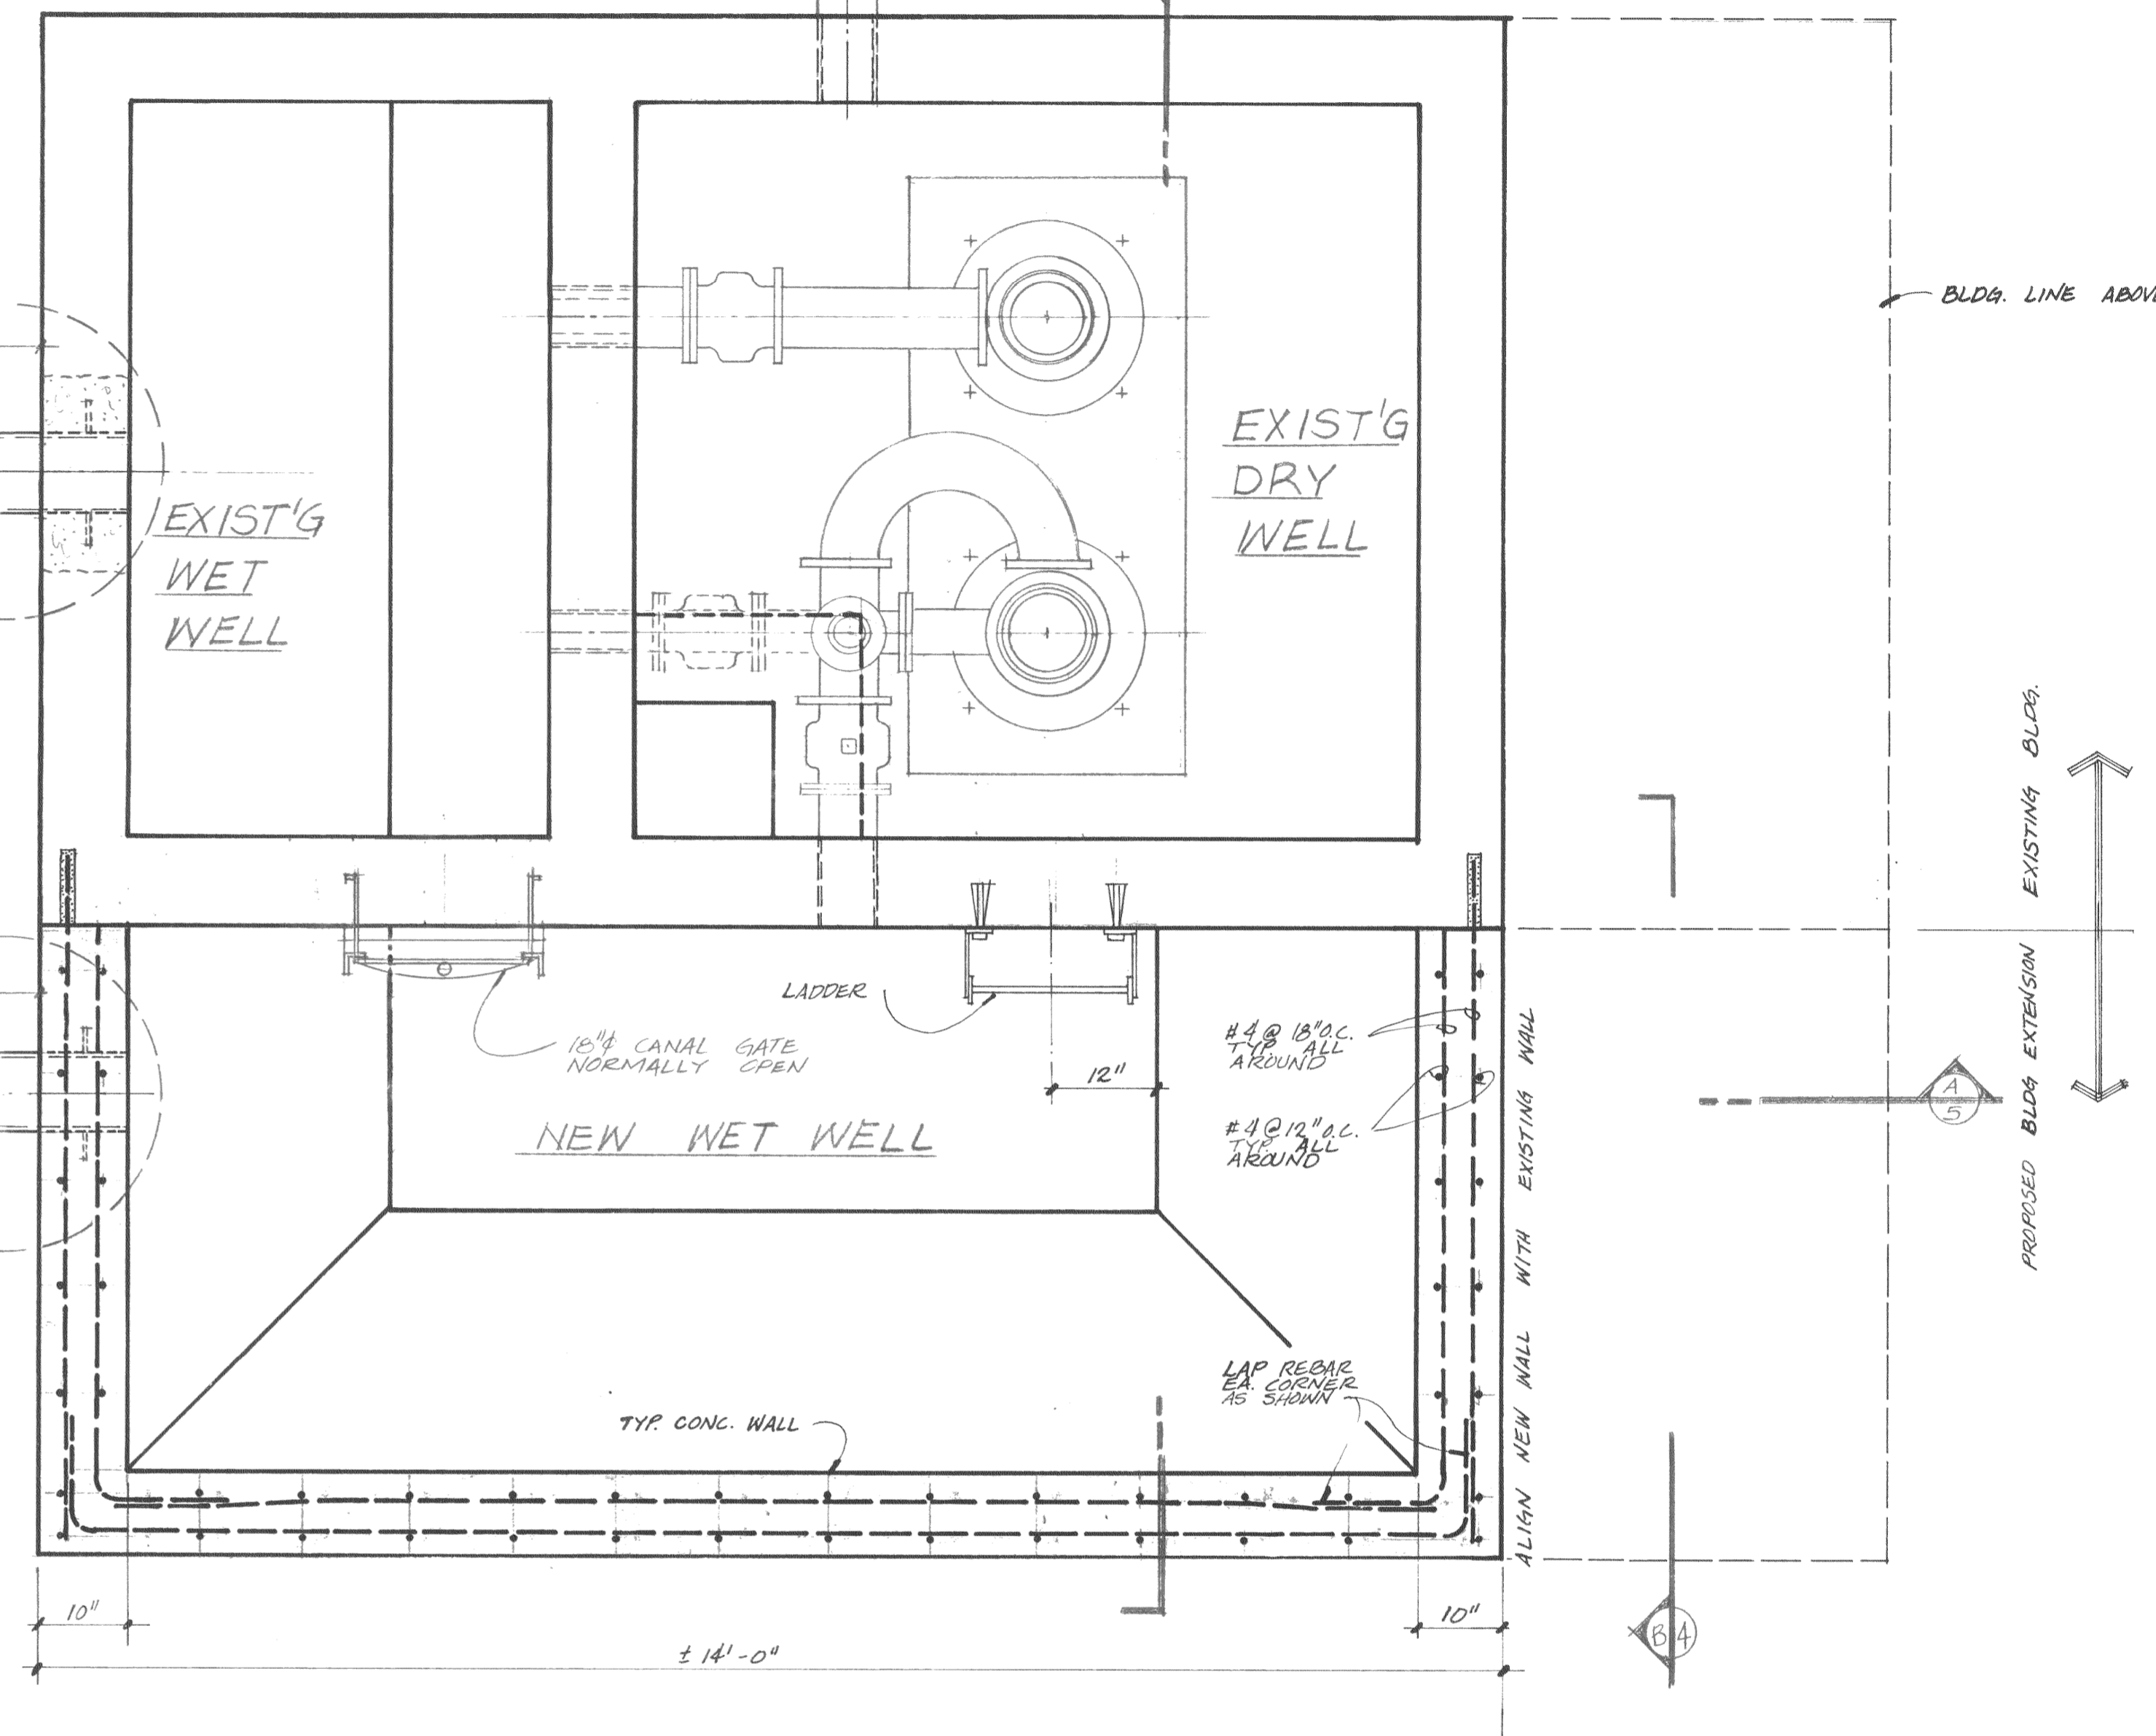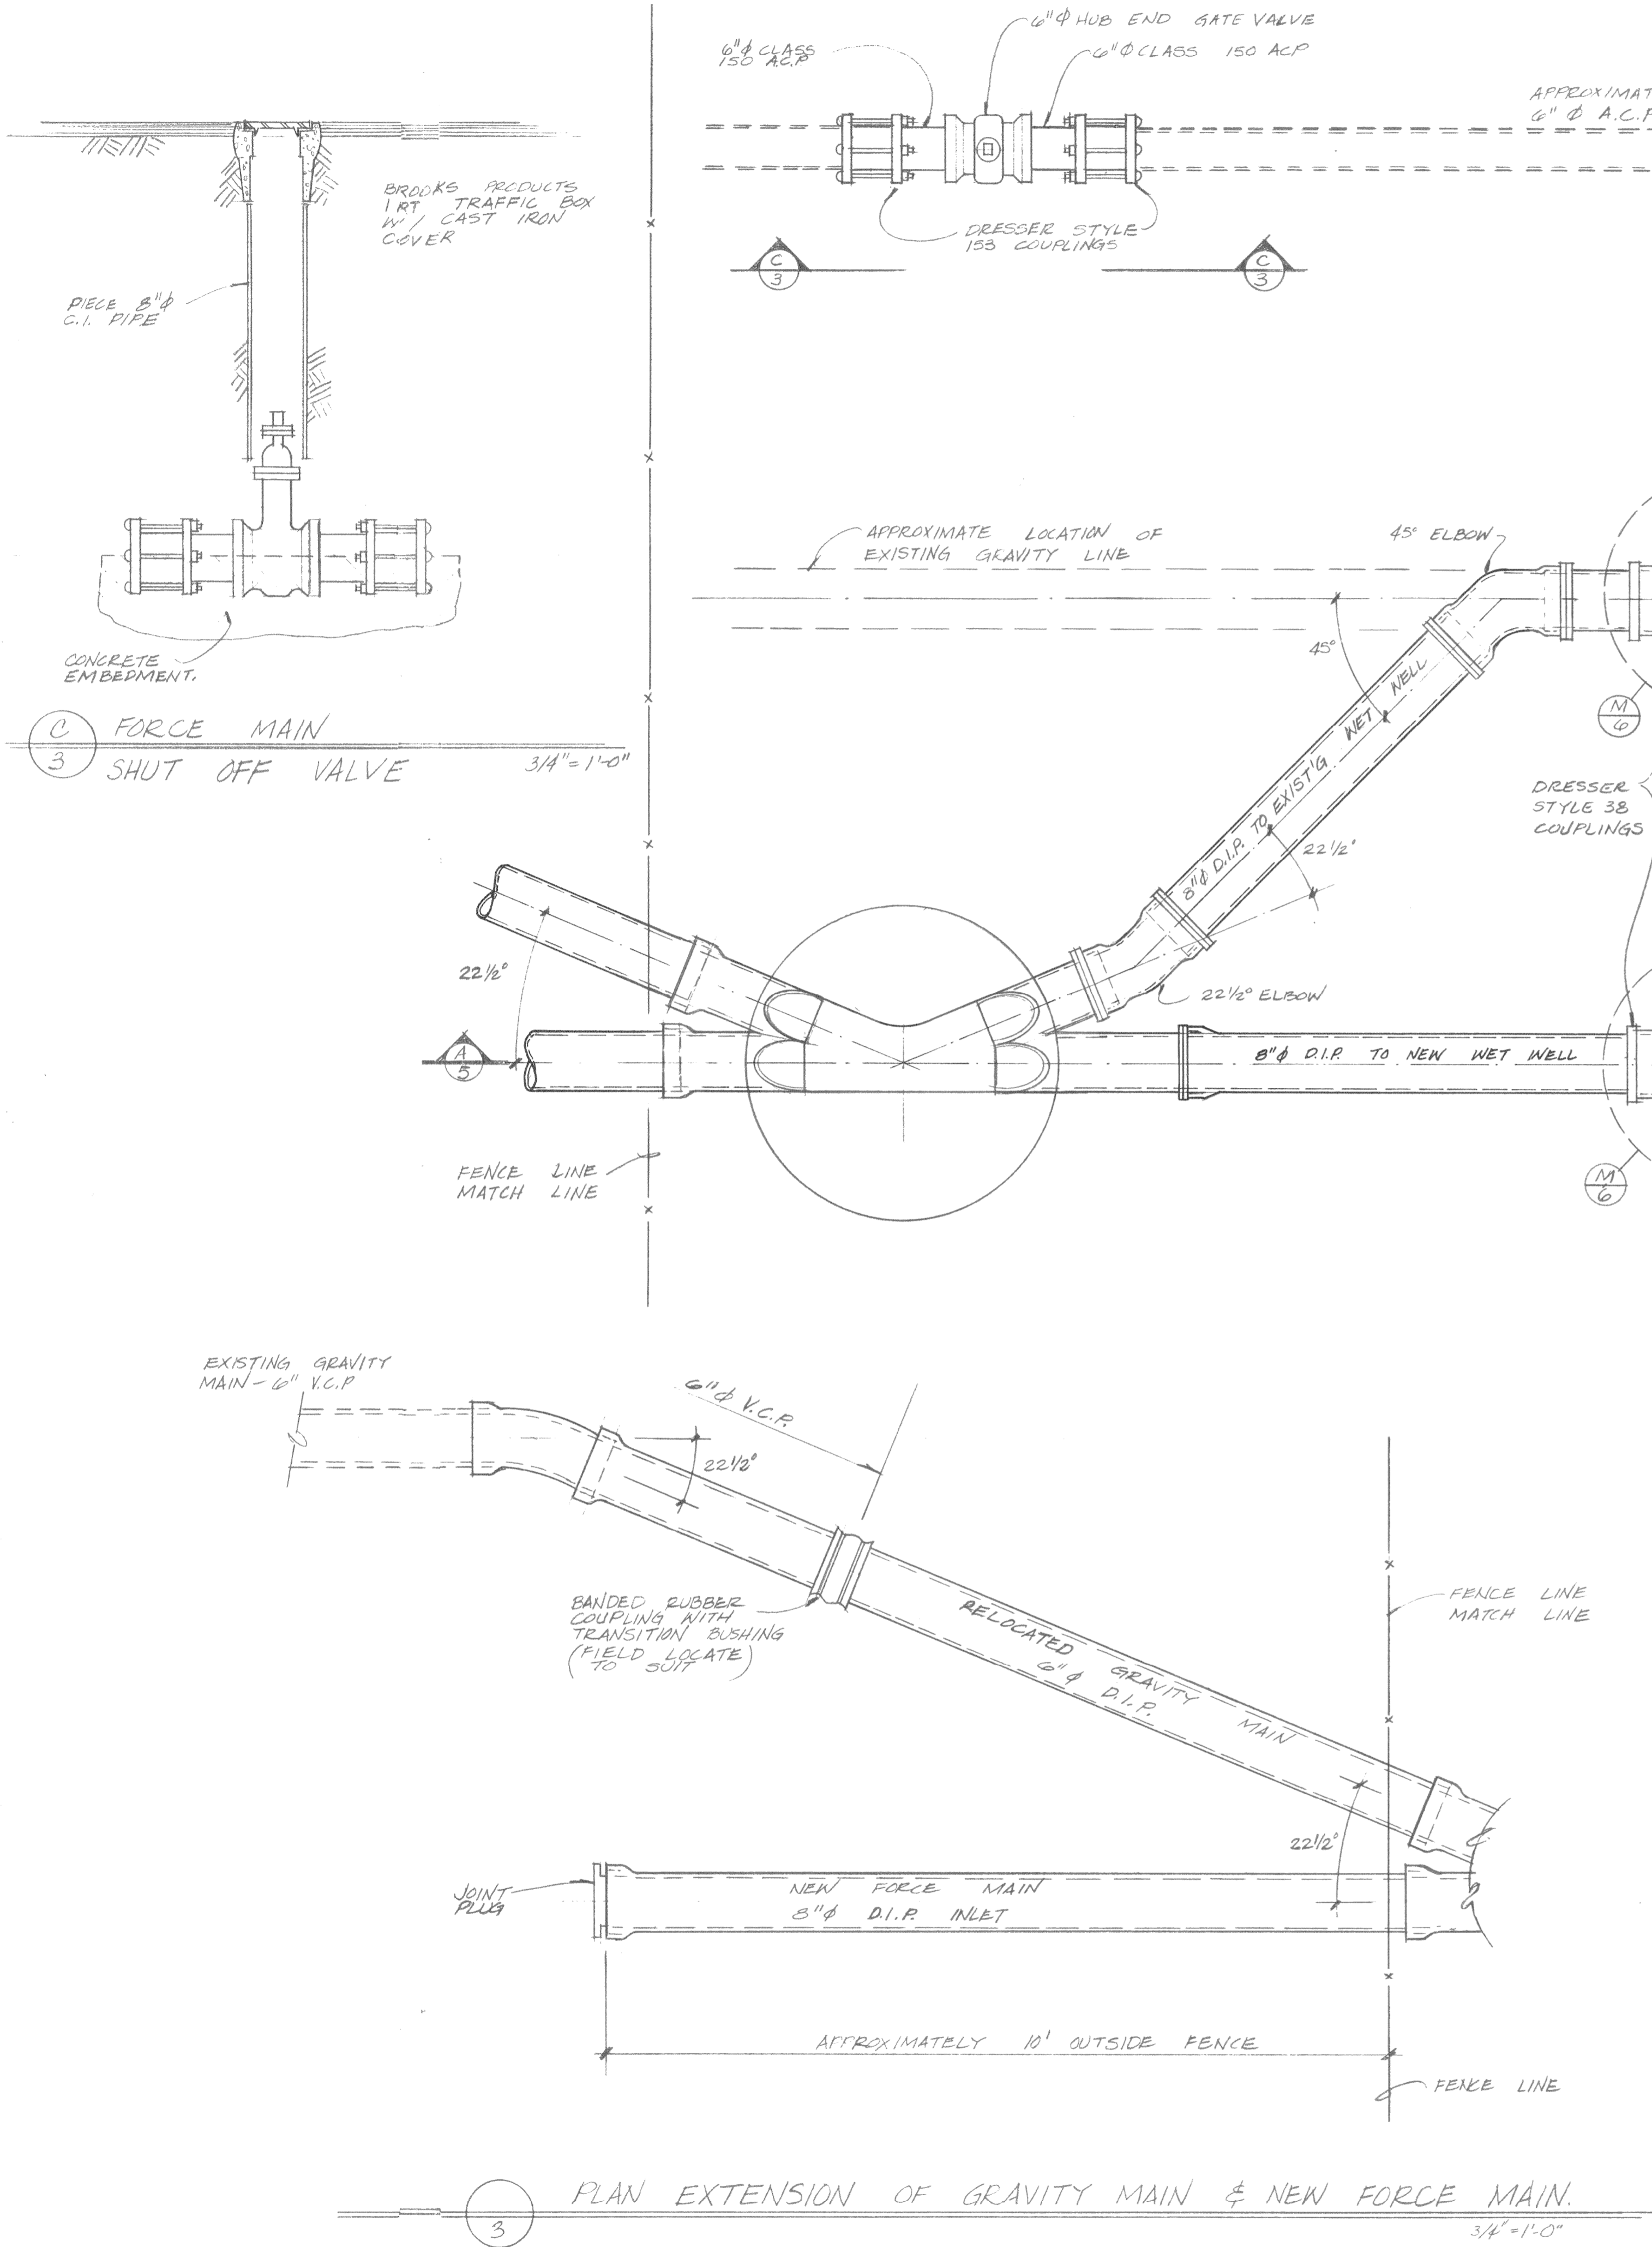

3
3/4" = 1'-0"



COOK ASSOCIATES
ENGINEERING CONSULTANTS

CITY OF ORVILLE
OLIVE GLEN LIFT STATION
PLAN AT BASE OF WET & DRY PITS



REVISION	DATE

DRAWN DATE
 JULY 81
 AL-51
 APPROVED DATE
 1/4/82
 FILE NO.
 SHEET NO.
3
 OF 11 SHTS
 B0405

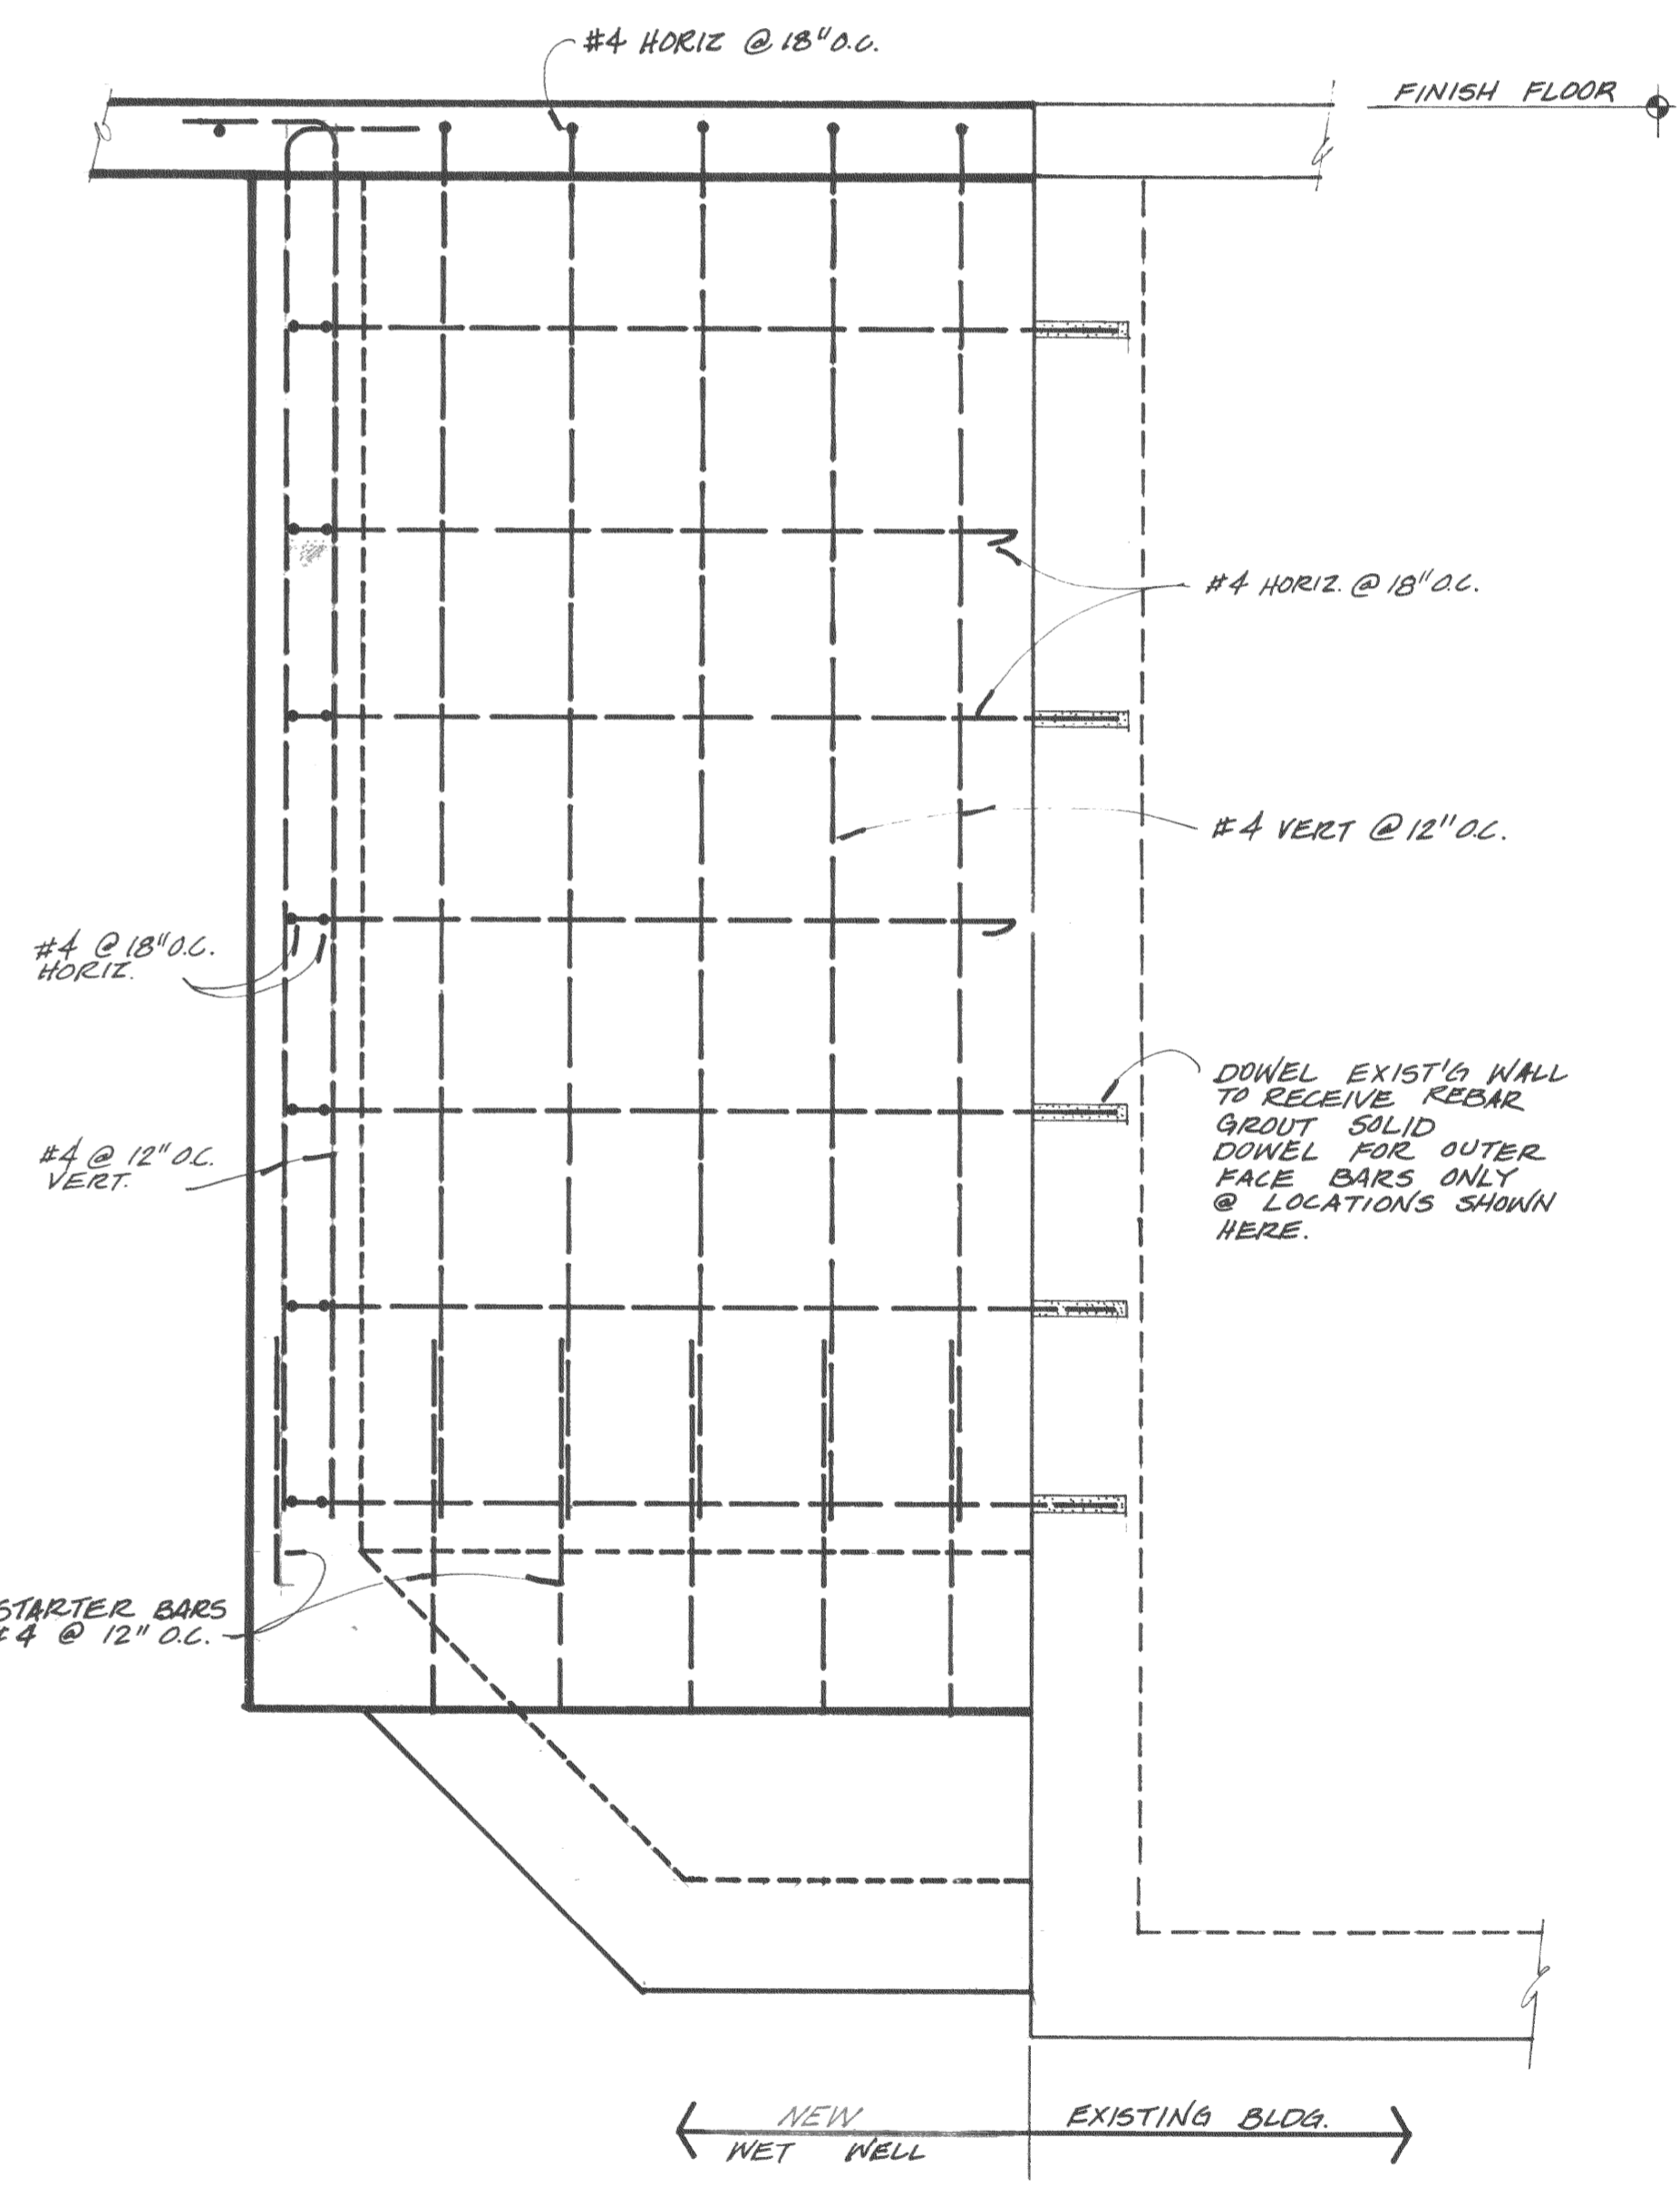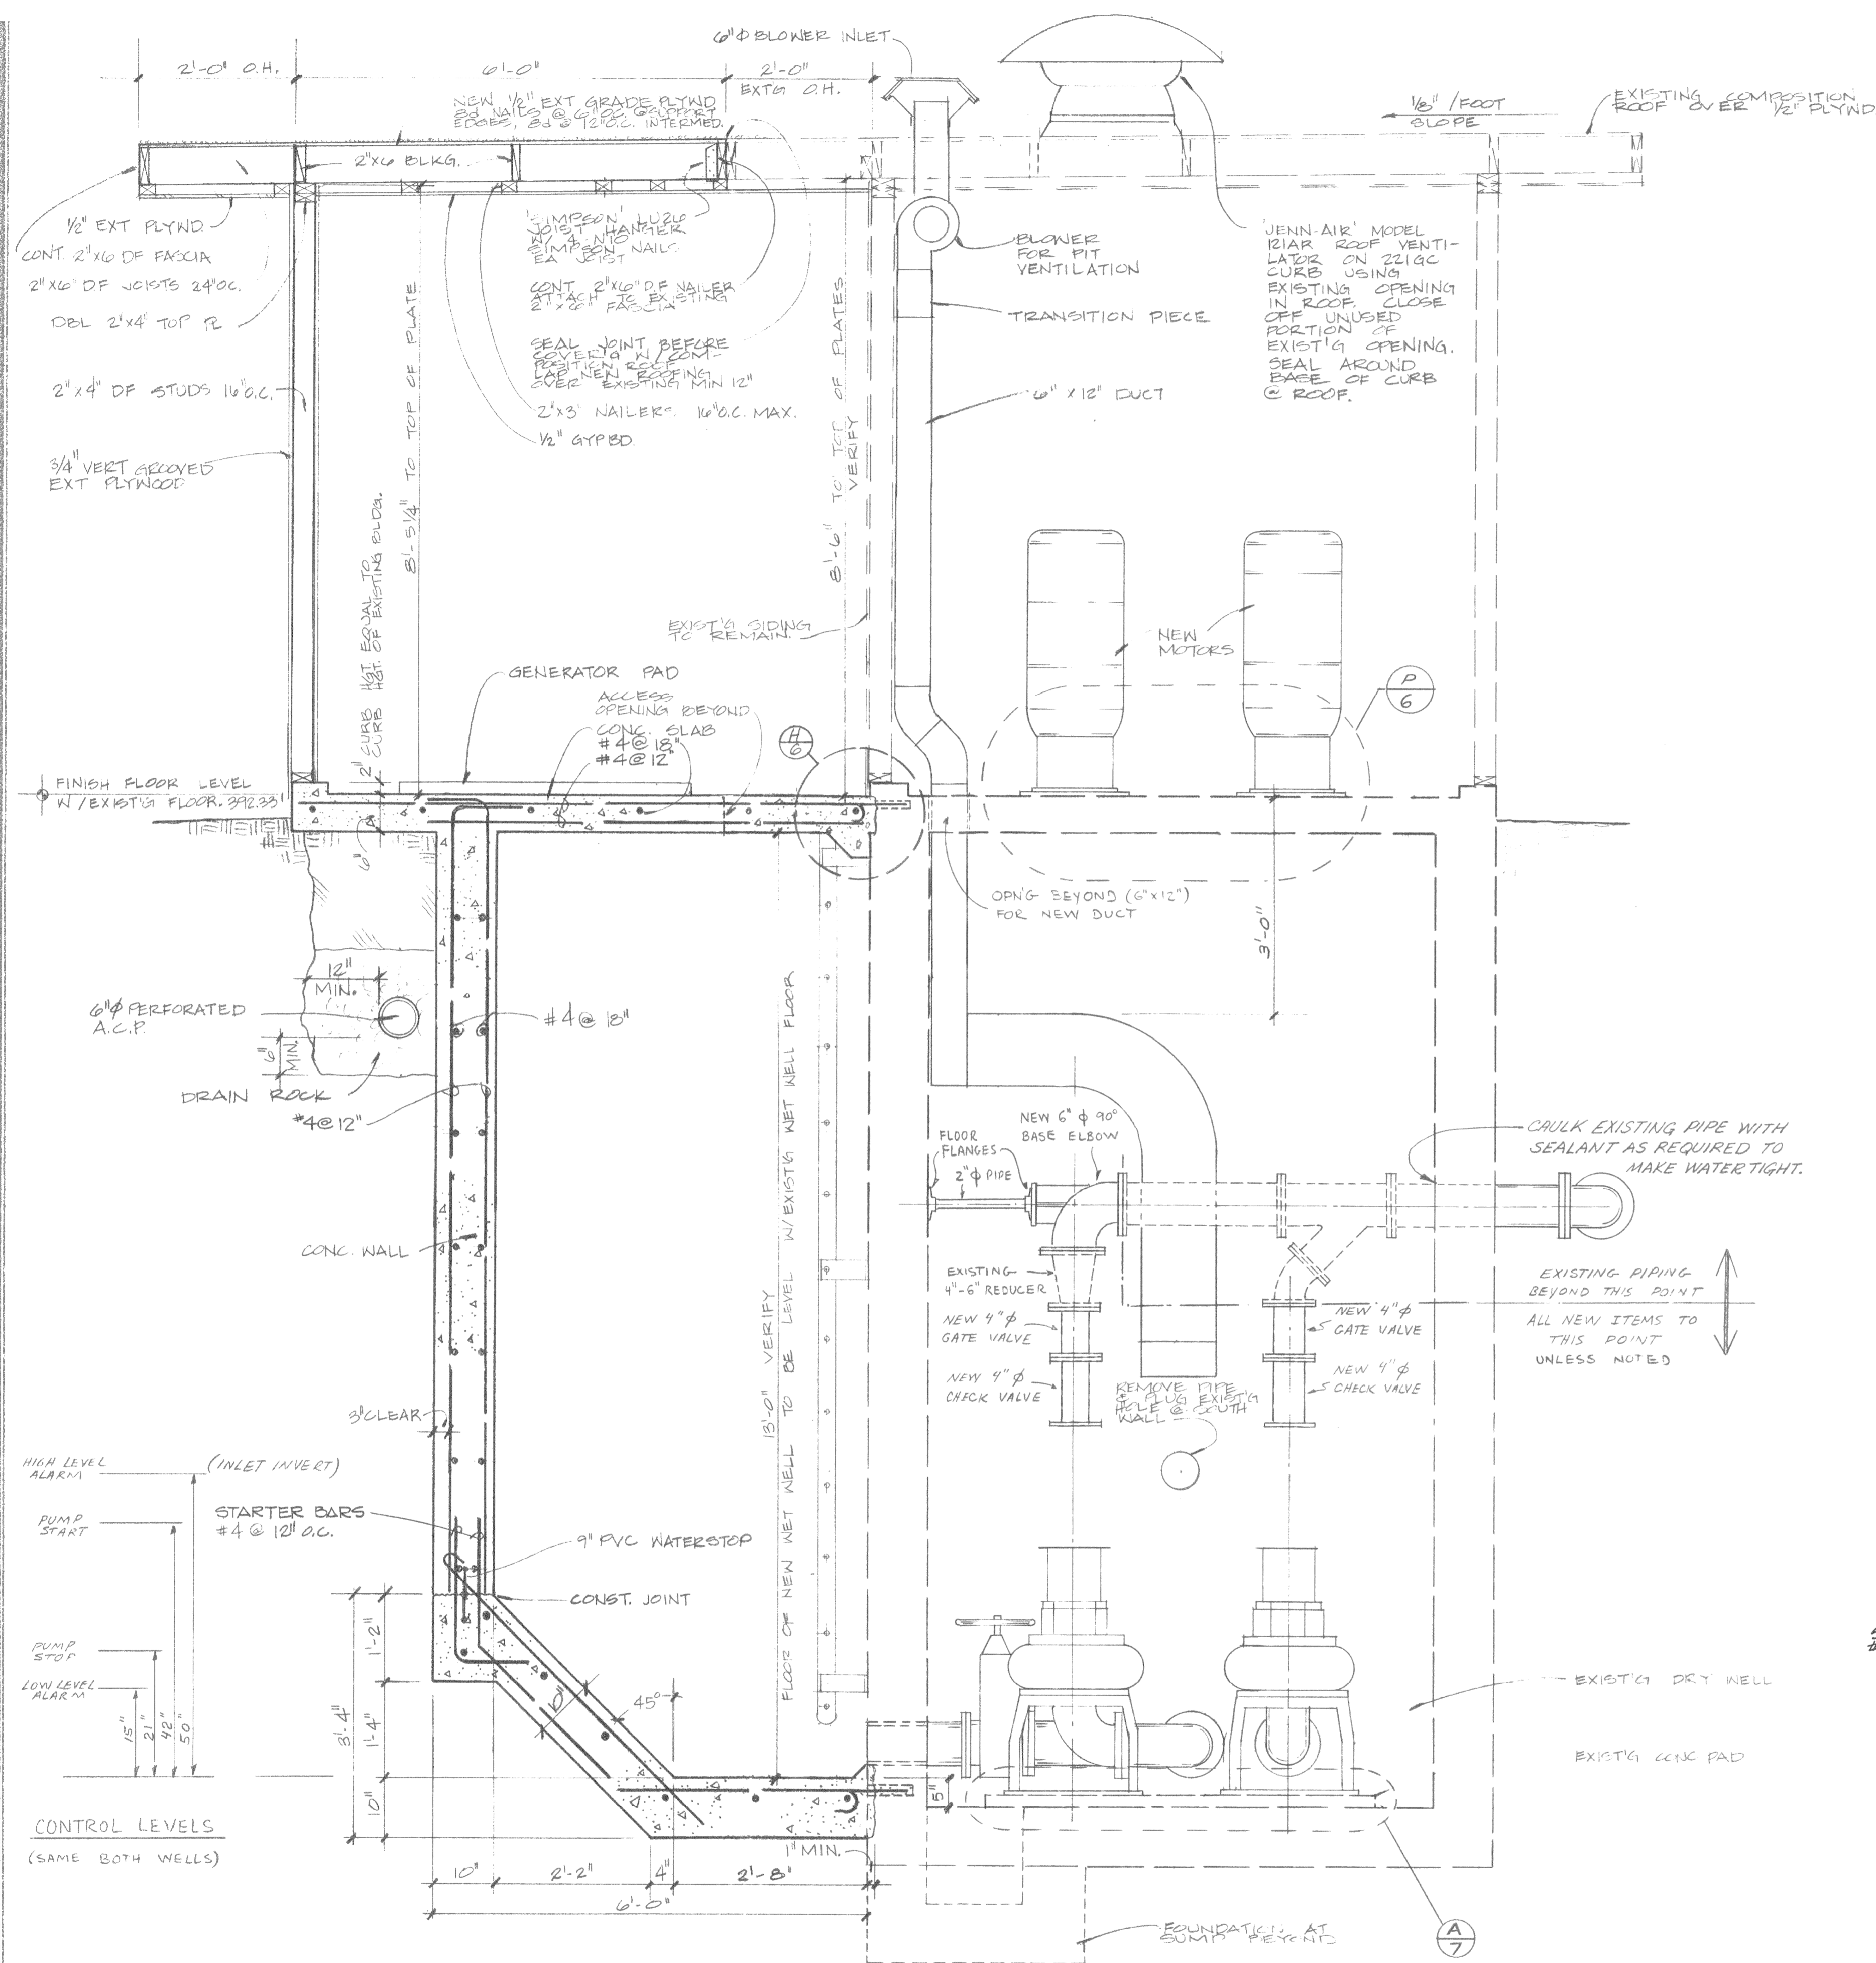

A
SECTION
3/4" = 1'-0"

B
REINFORCEMENT LAYOUT - END WALLS
OF NEW WET WELL. 3/4" = 1'-0"


COOK ASSOCIATES
ENGINEERING CONSULTANTS
2080 PARK AVENUE, OROVILLE, CALIFORNIA 95965

CITY OF OROVILLE
OLIVE GLEN LIFT STATION
GENERAL SECTION



REVISION	DATE

JOYCE JULY 01
DRAWN DATE
APPROVED DATE
FILE NO.
SHEET NO. **4**
OF 11 SHEETS
JOB NO. 80465

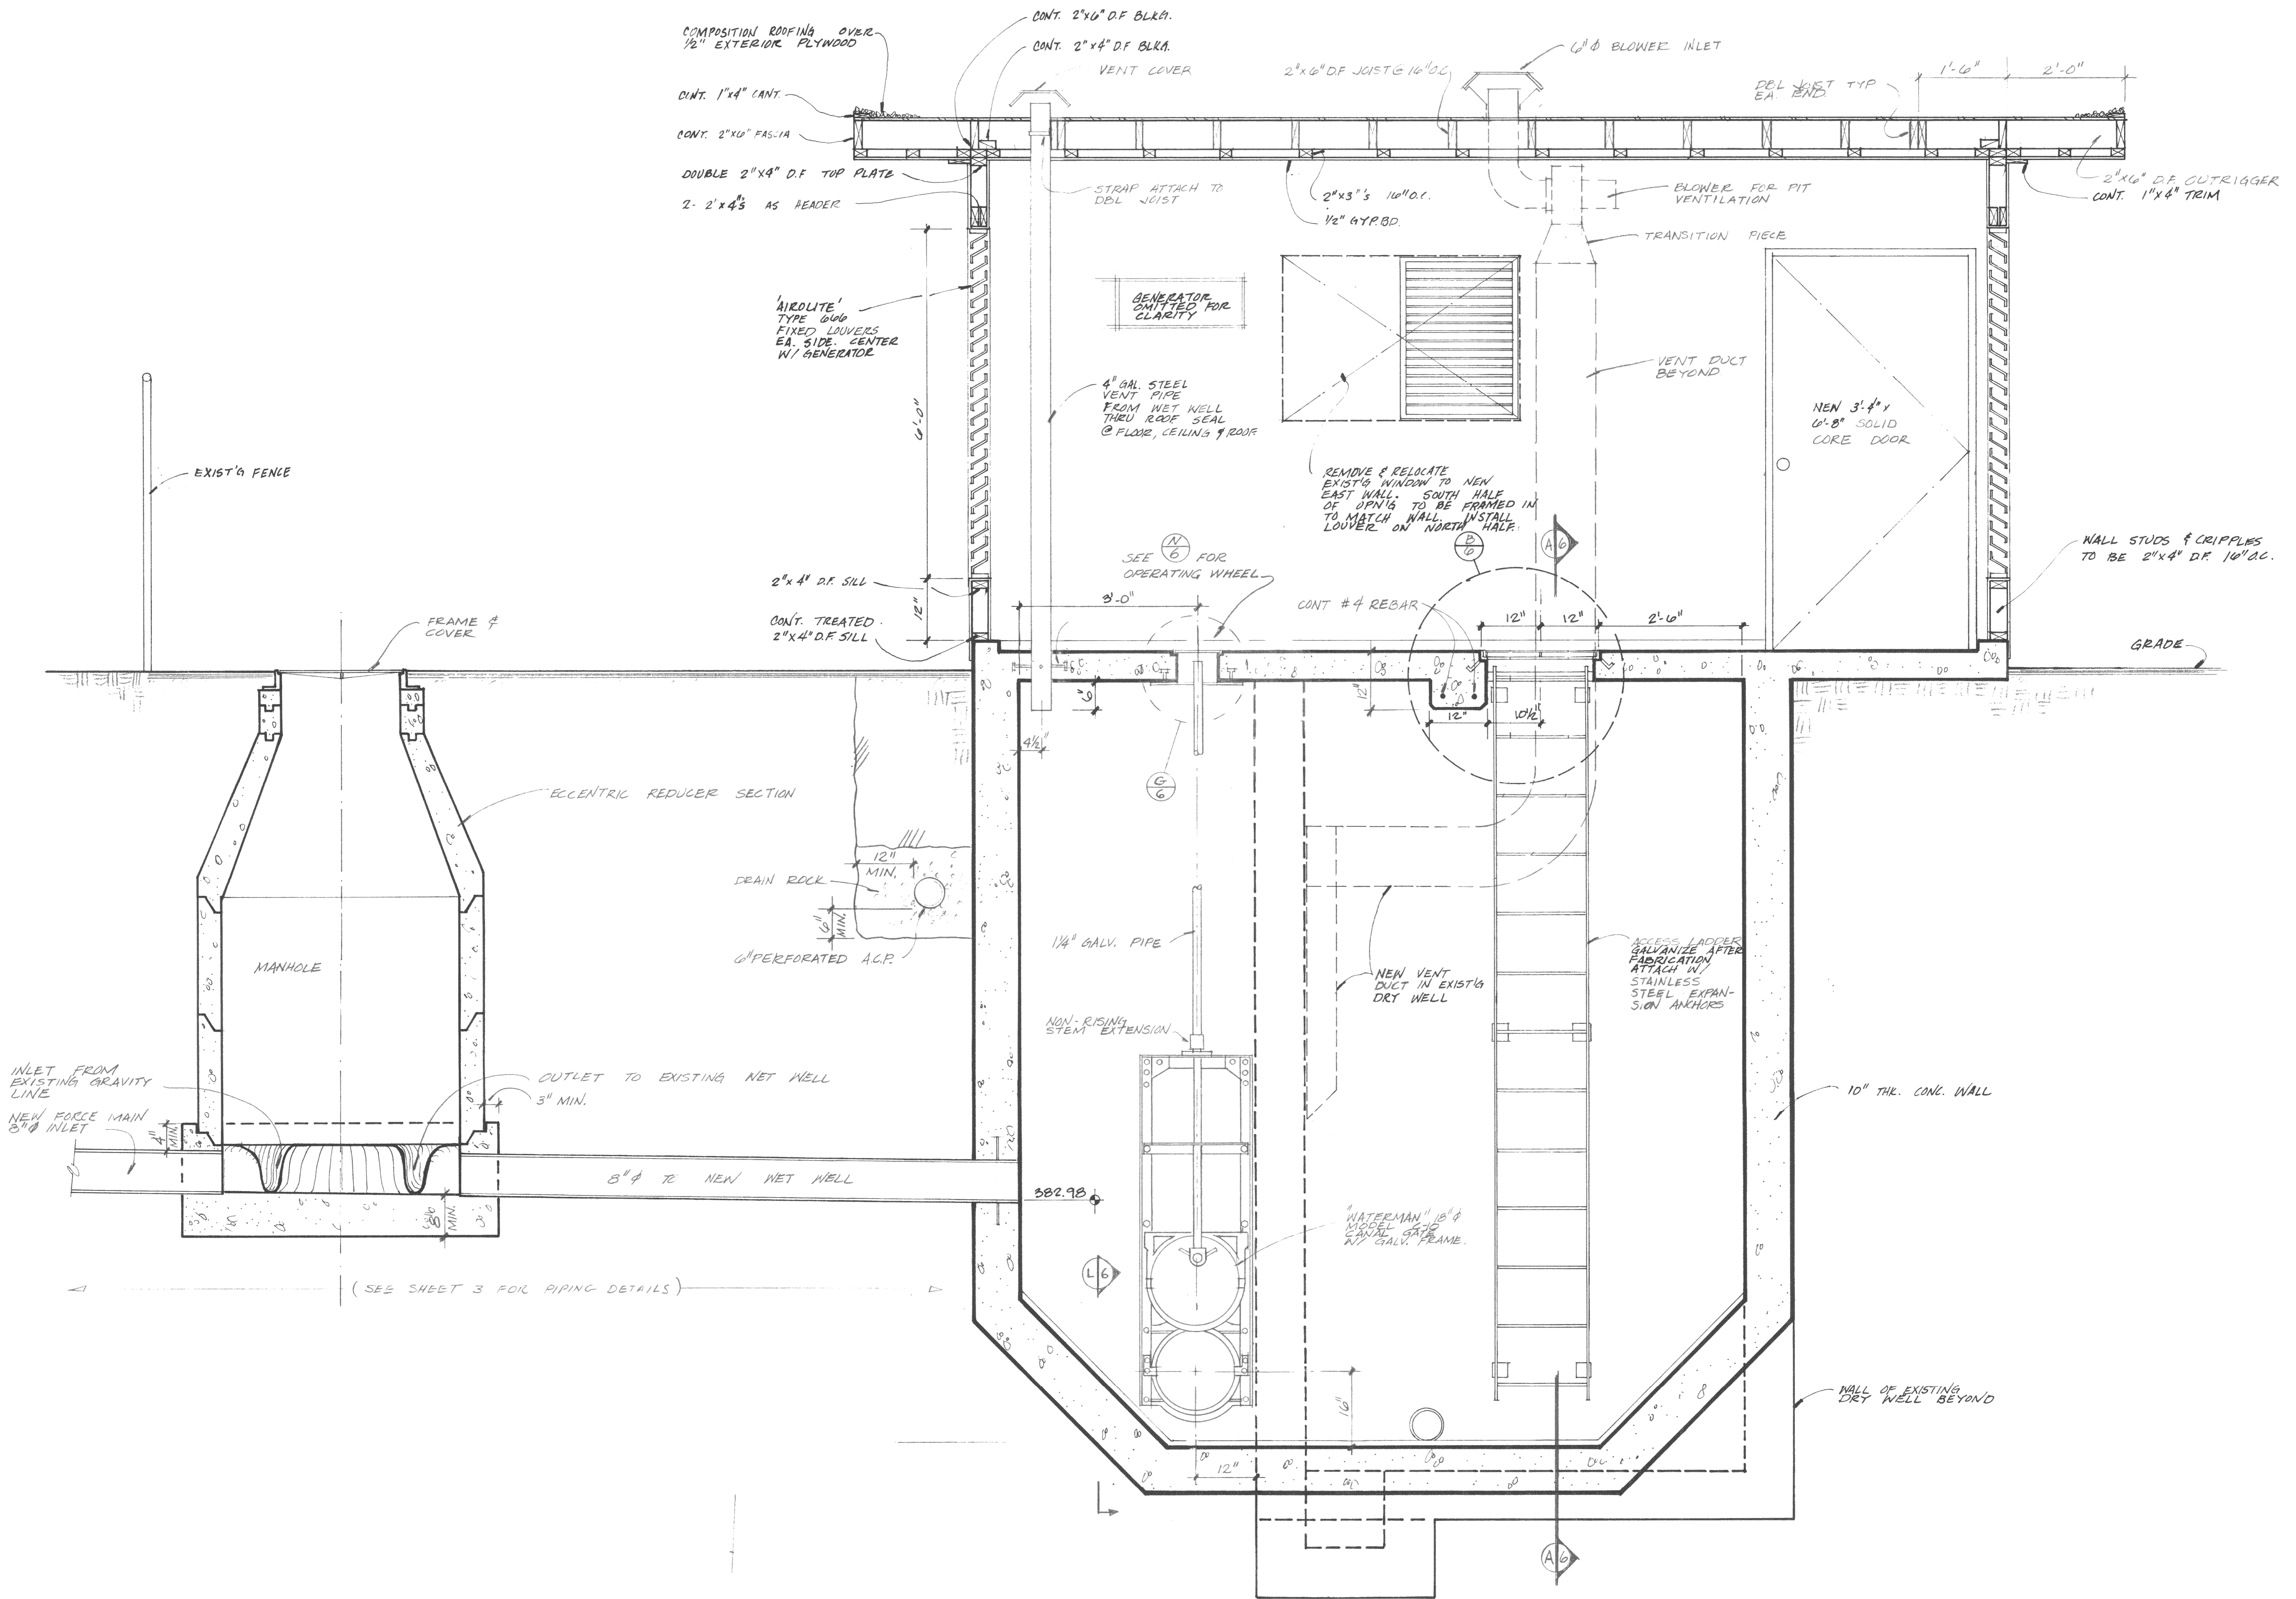


A SECTION THRU NEW WET WELL & MANHOLE
 3/4" = 1'-0"

COOK ASSOCIATES
 ENGINEERING CONSULTANTS
 2080 PARK AVENUE, ORVILLE, CALIFORNIA 95961


CITY OF ORVILLE
 OLIVE GLEN LIFT STATION
 SECTION THRU NET WELL




REVISION	DATE
JOYCE	JULY 01
DRAWN	DATE
APPROVED	DATE
FILE NO.	
SHEET NO.	
5	
OF 11 SHEETS	

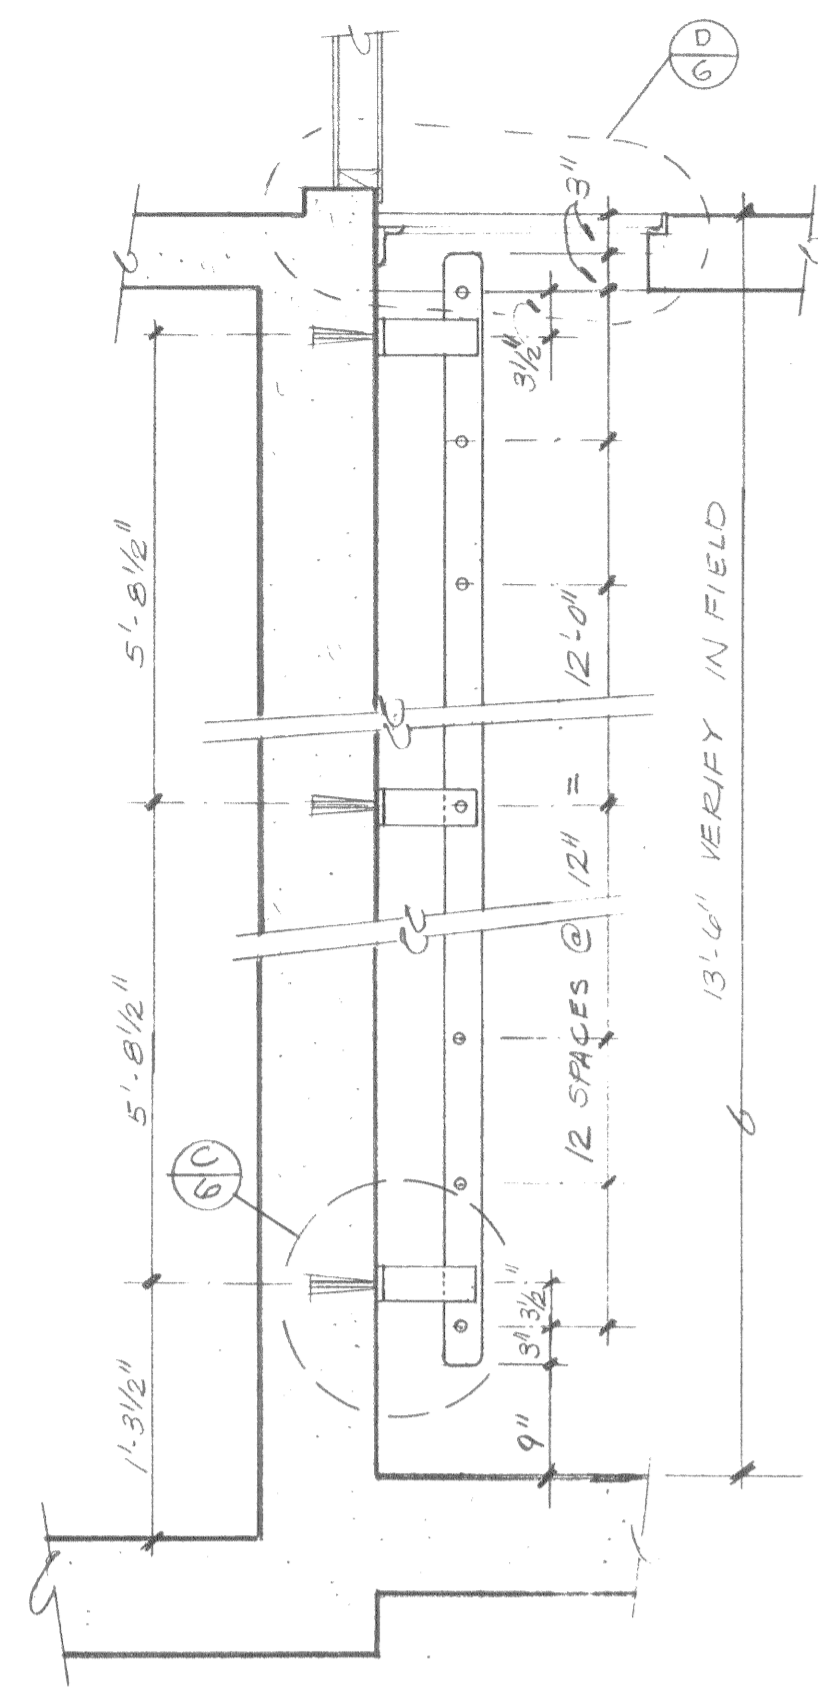


(A) ACCESS LADDER
3/4" = 1'-0"

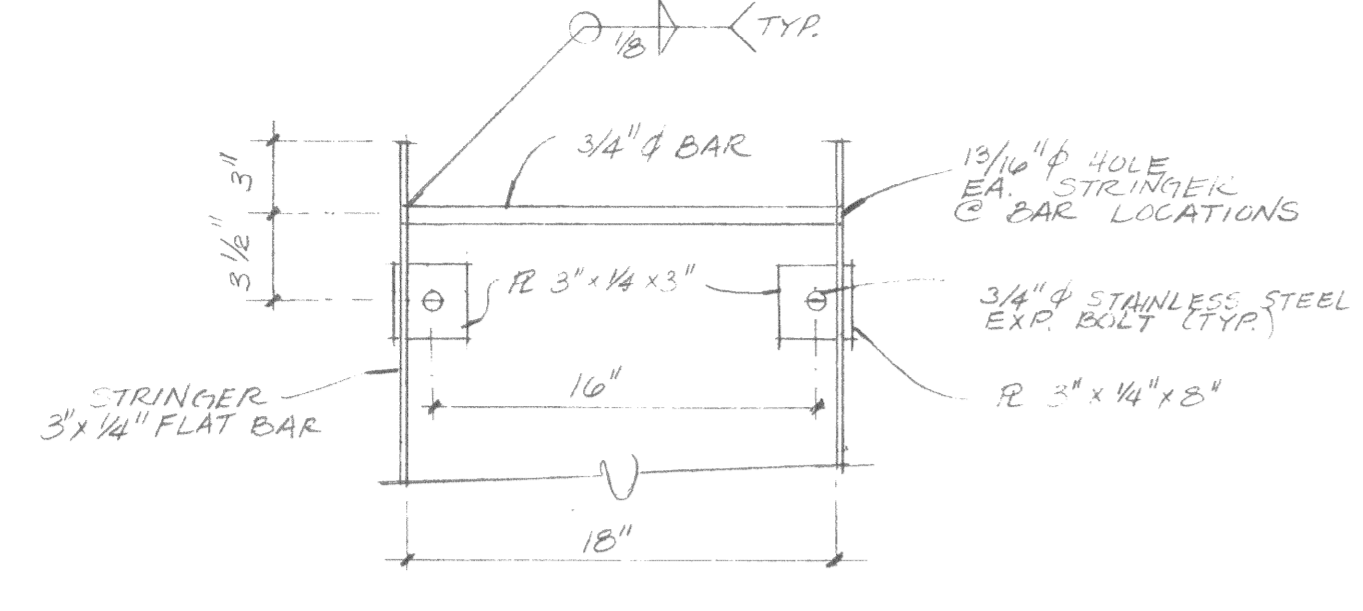


(B) LADDER DETAIL
1/2" = 1'-0"

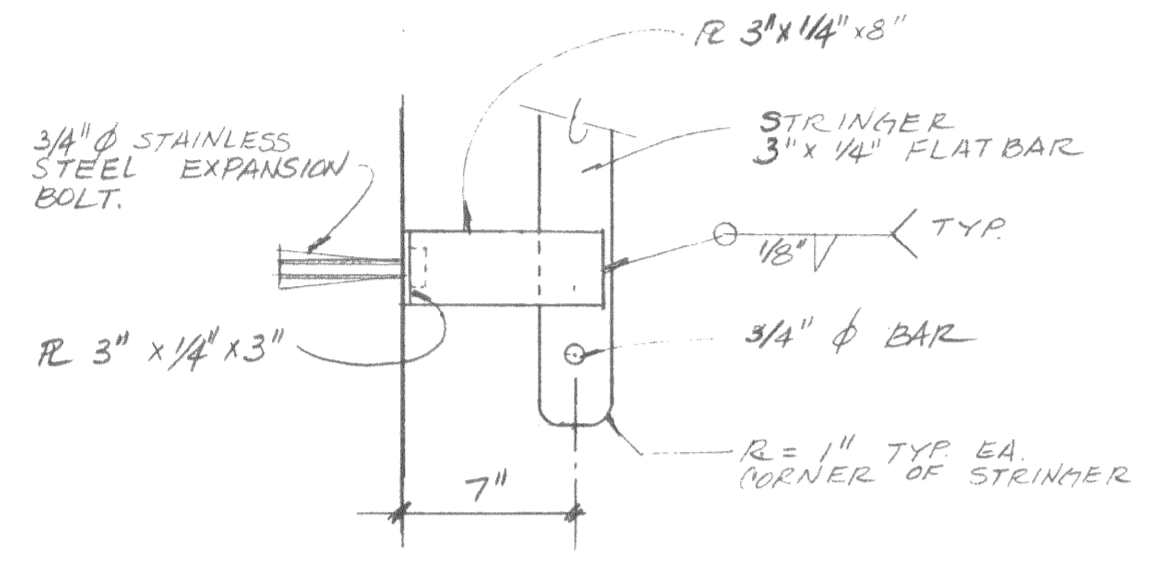


(C) LADDER DETAIL
1/2" = 1'-0"

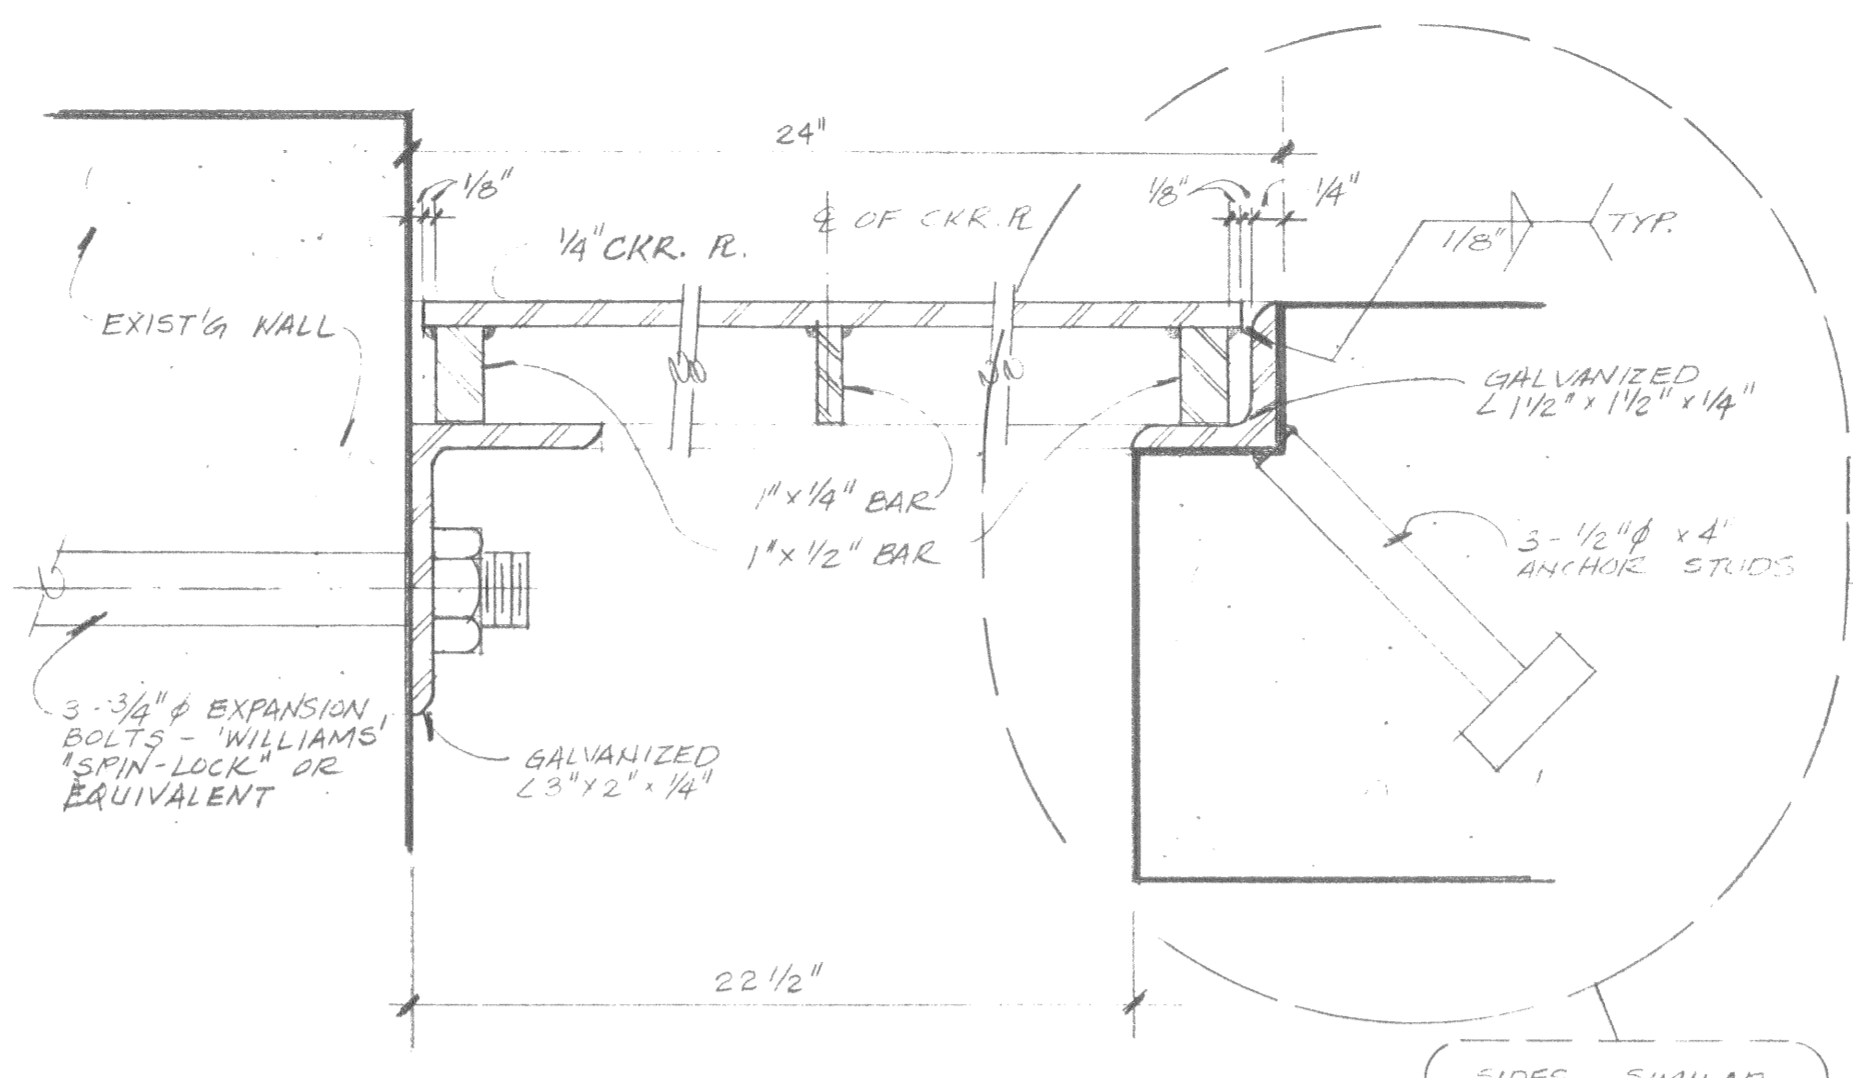


(D) ACCESS HATCH TO NEW WET WELL
HALF SIZE

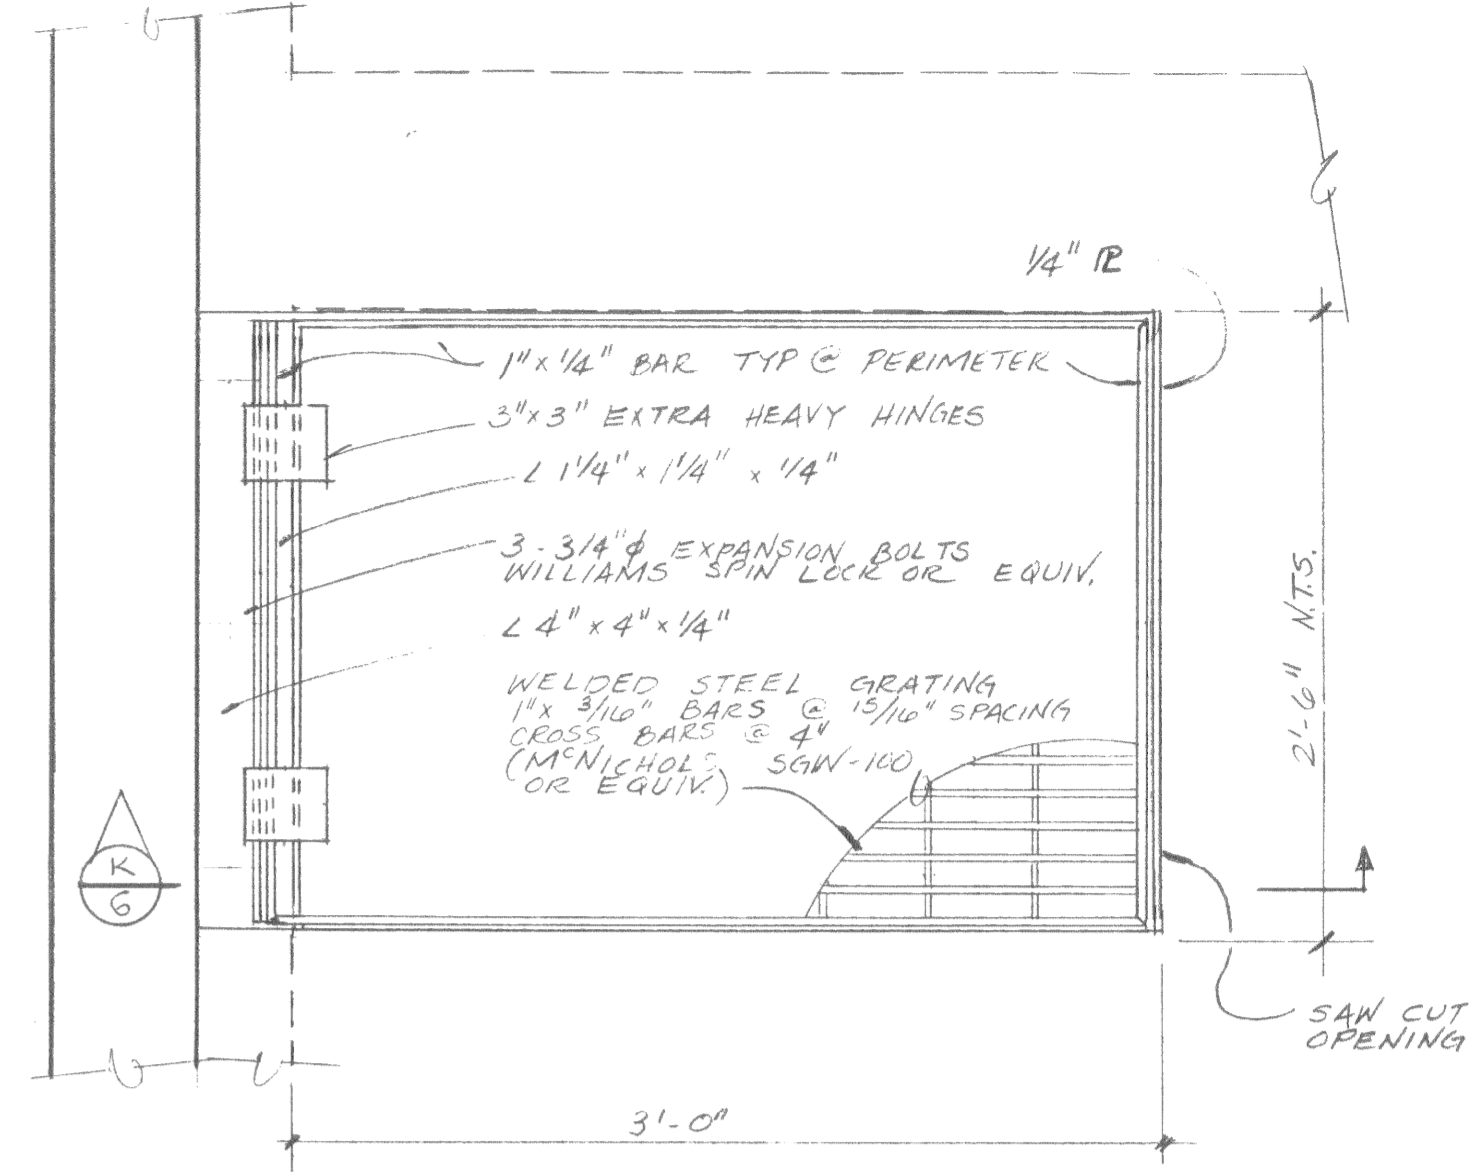


(E) NEW DRY-PIT ACCESS HATCH
HALF SIZE

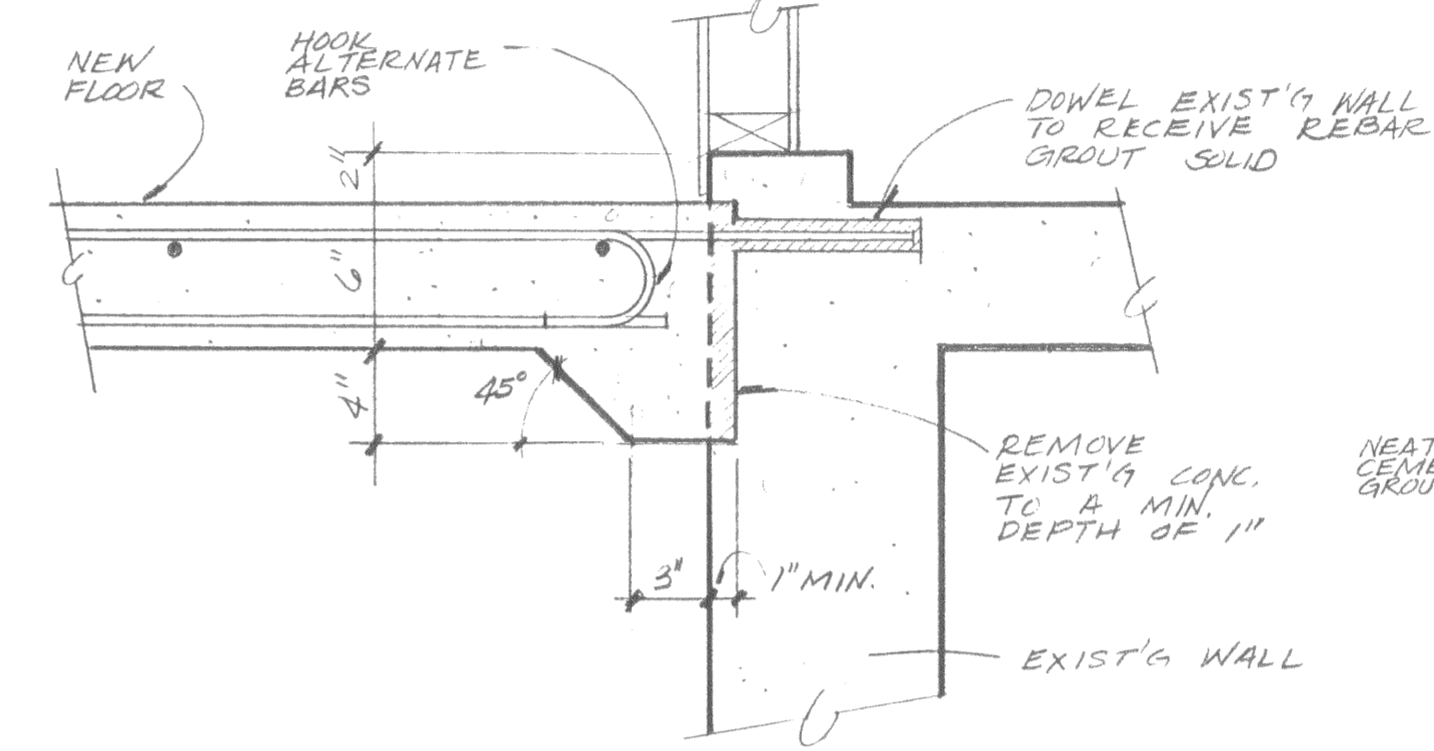


(H) JOINT @ NEW FLR. TO EXIST'G WALL
1/2" = 1'-0"

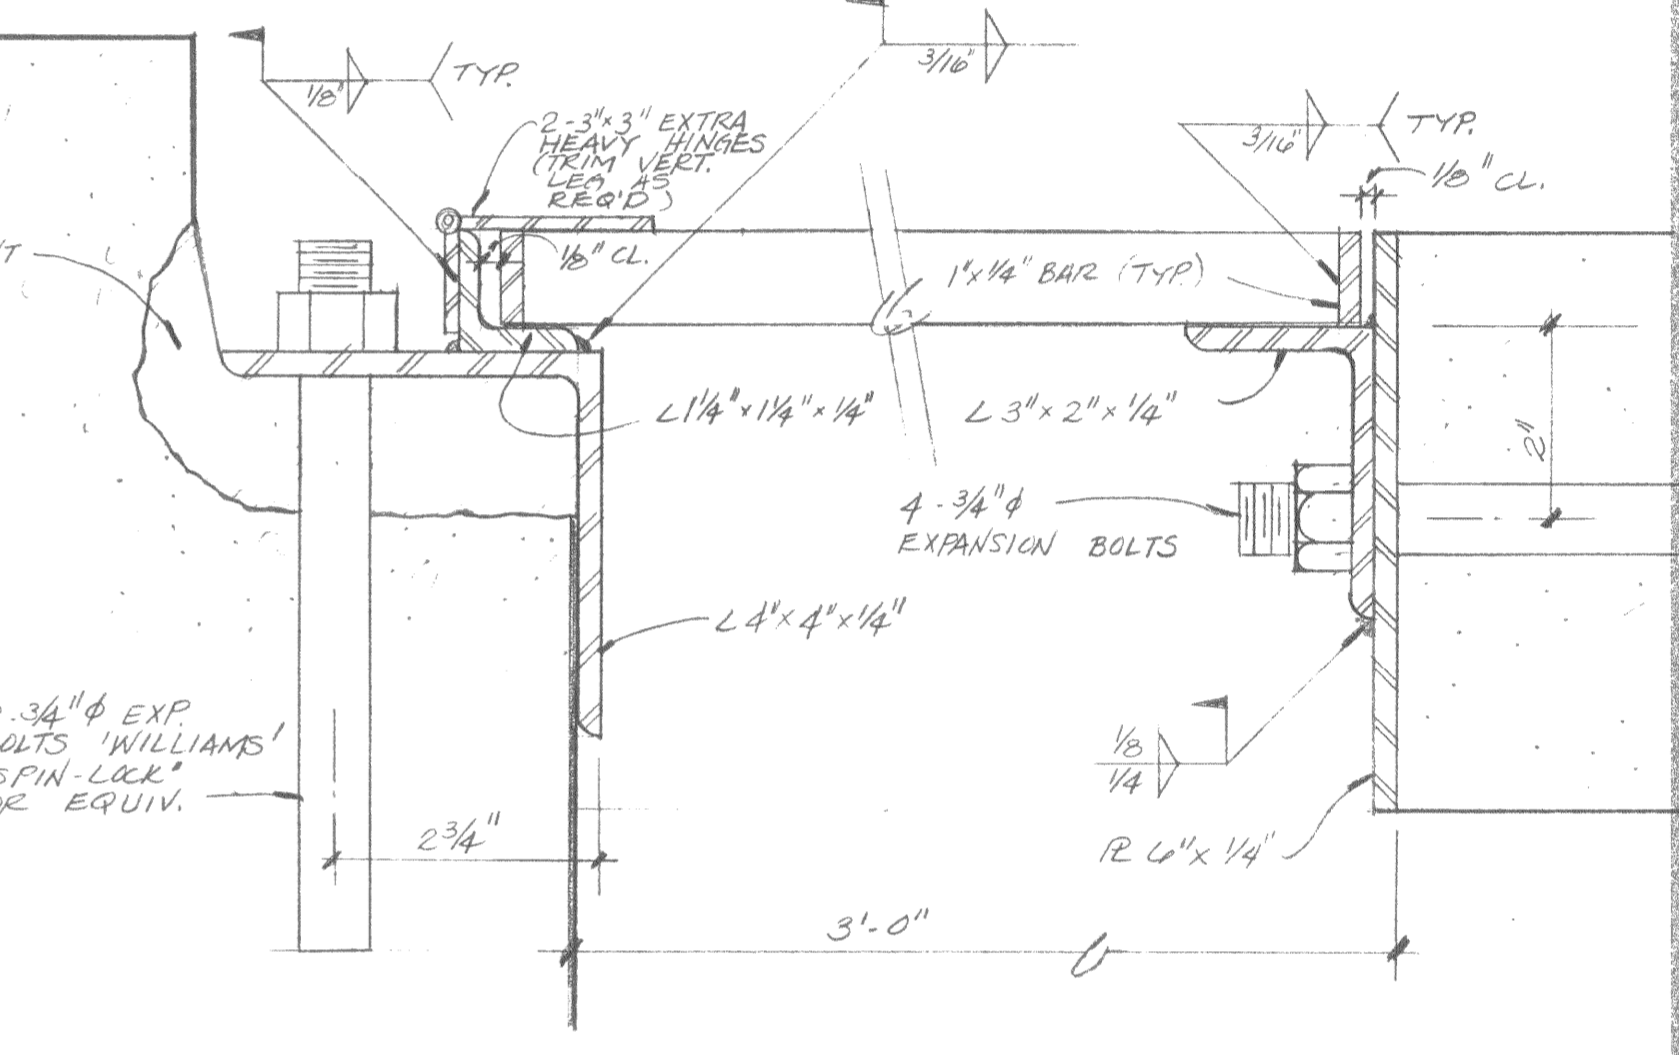


(K) NEW DRY-PIT ACCESS HATCH
HALF-SIZE

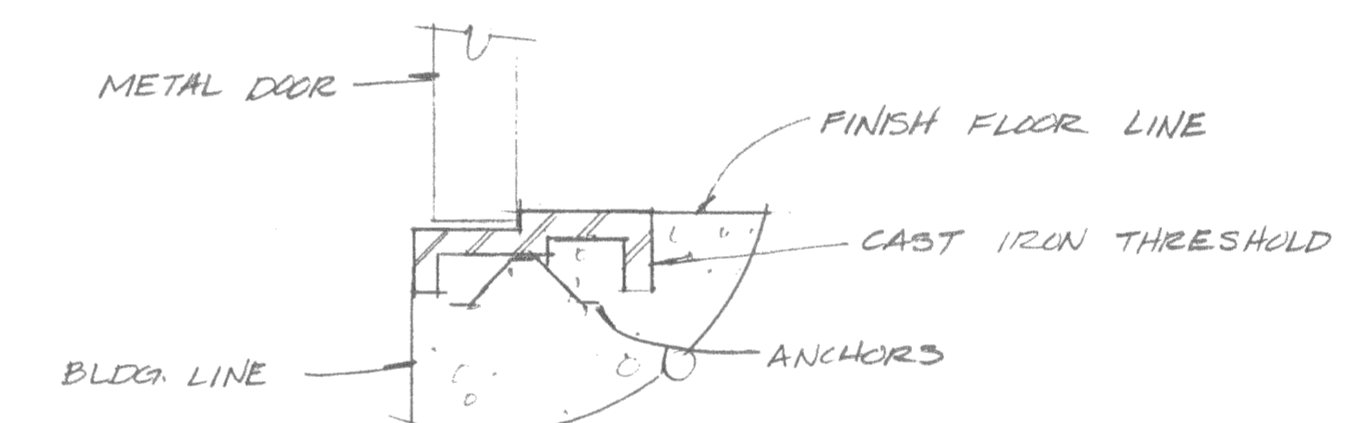


(J) THRESHOLD

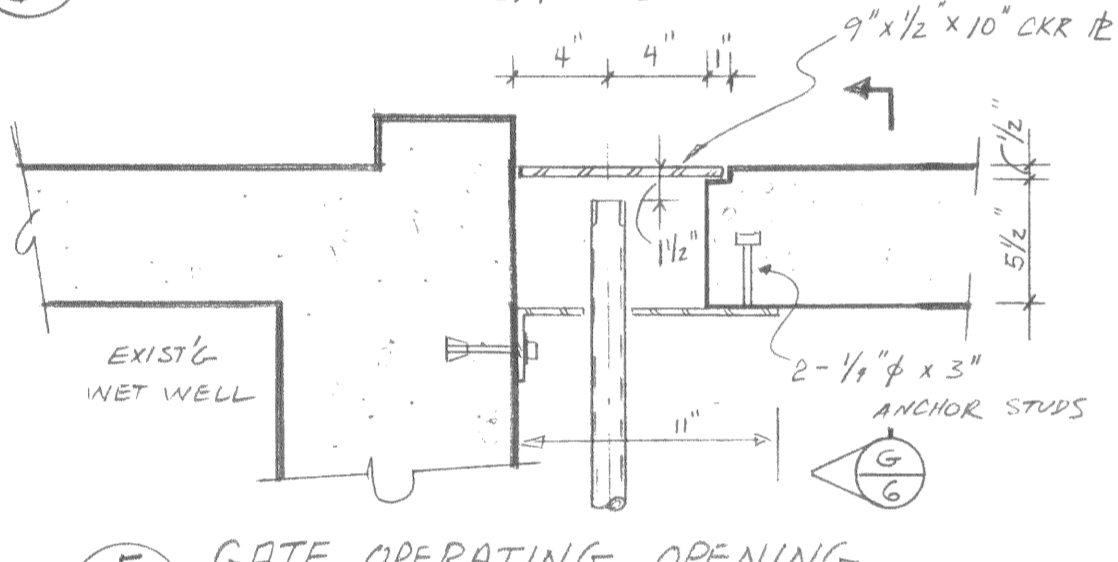


(F) GATE OPERATING OPENING
1 1/2" = 1'-0"

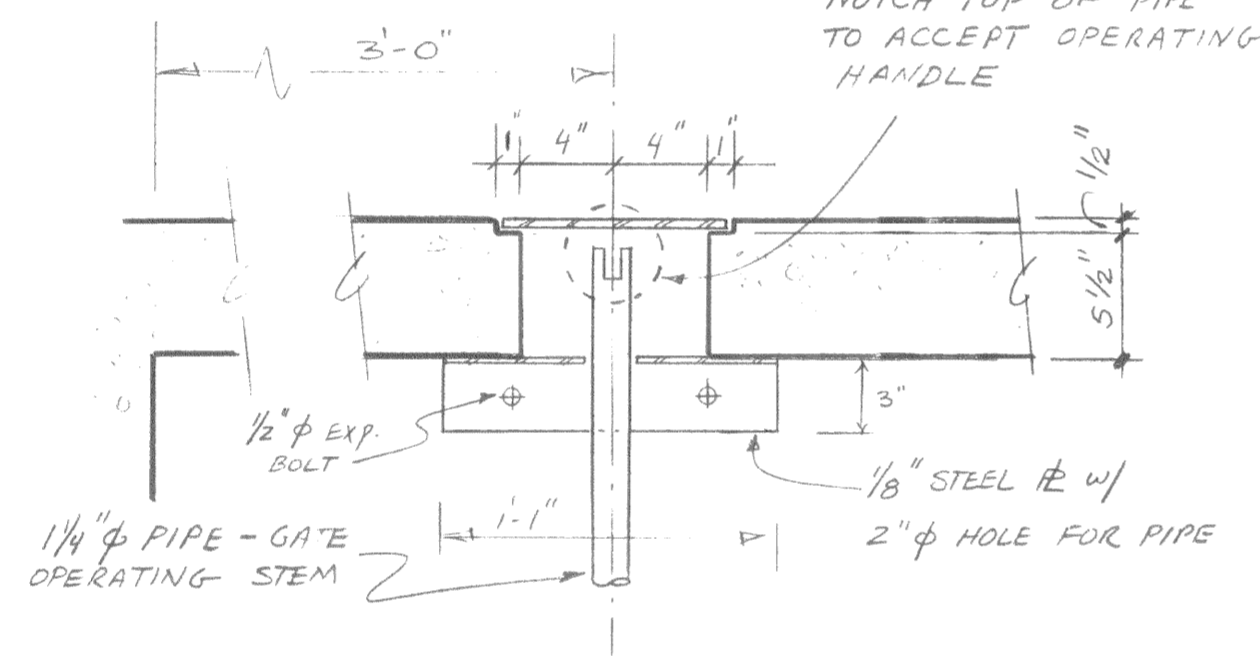


(G) GATE OPERATING OPENING
1 1/2" = 1'-0"

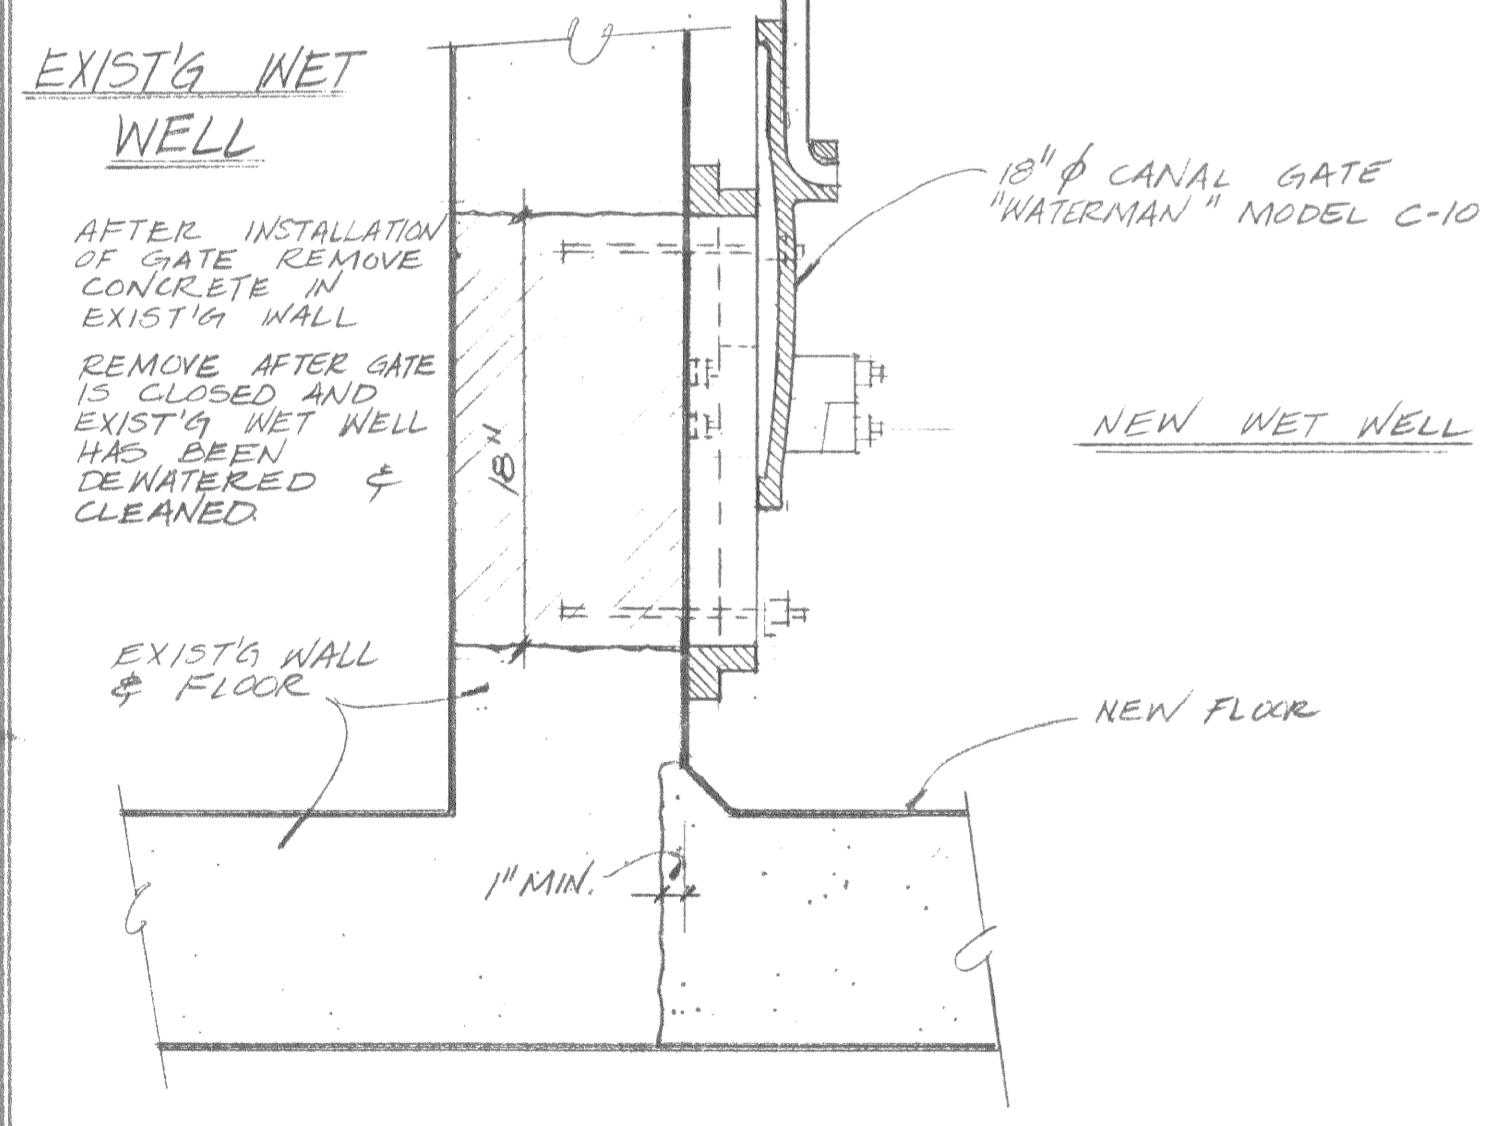


(L) CANAL GATE SECTION
1 1/2" = 1'-0"

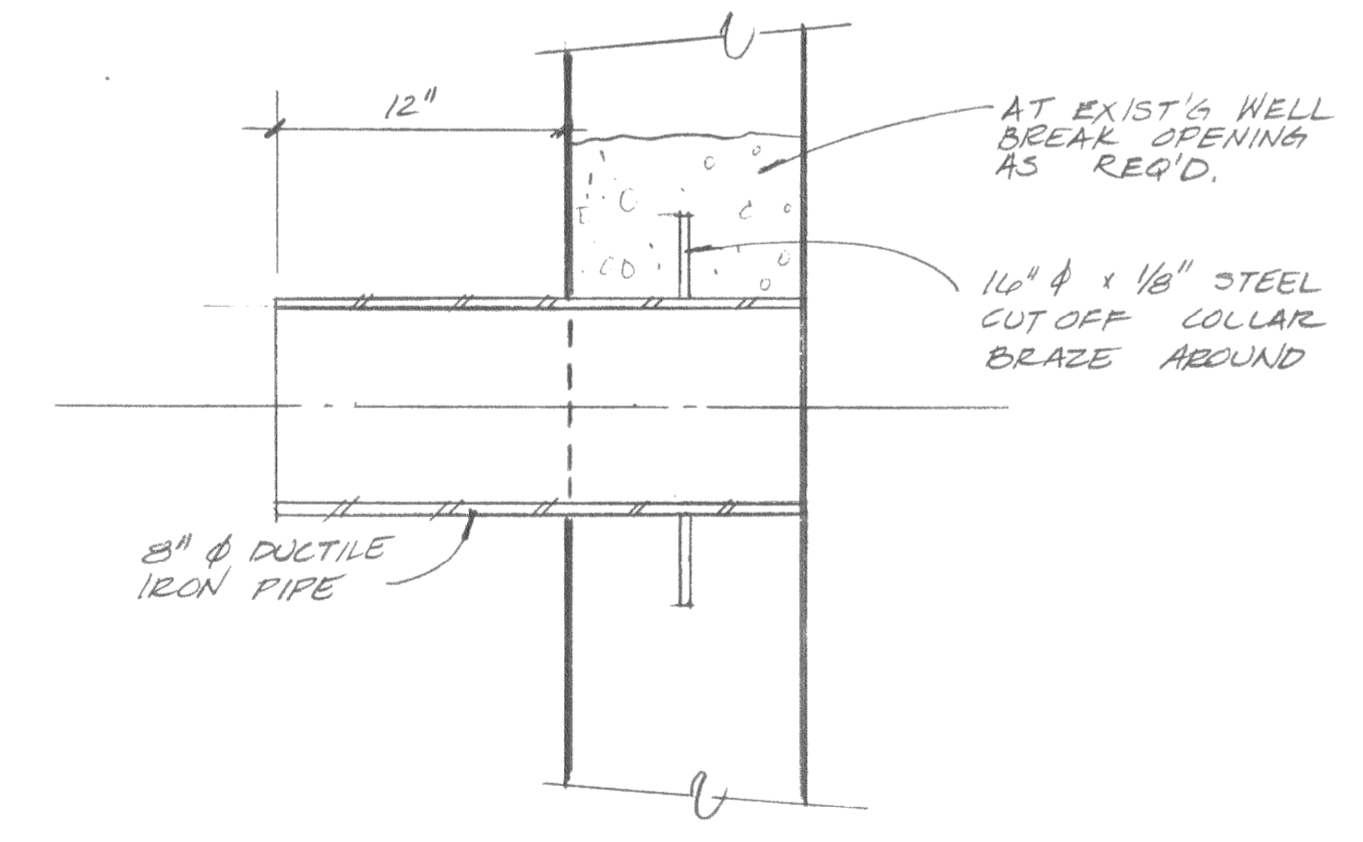

(M) WET WELL INLETS
1 1/2" = 1'-0"

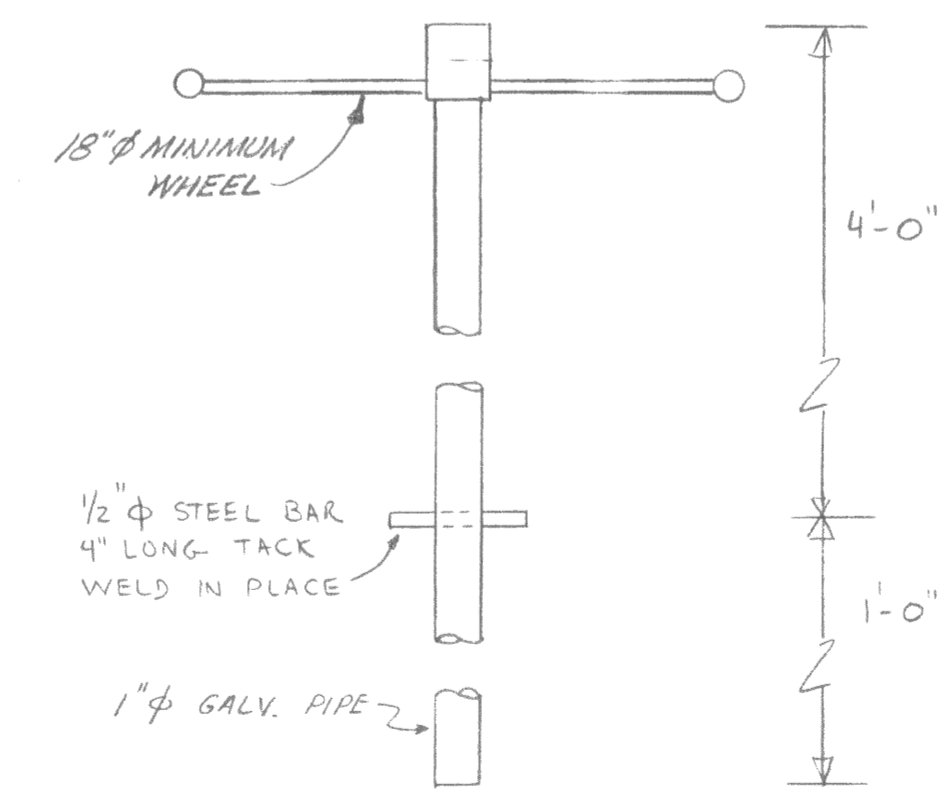

(N) GATE OPERATING WHEEL
ONE REQUIRED 3" = 1'-0"

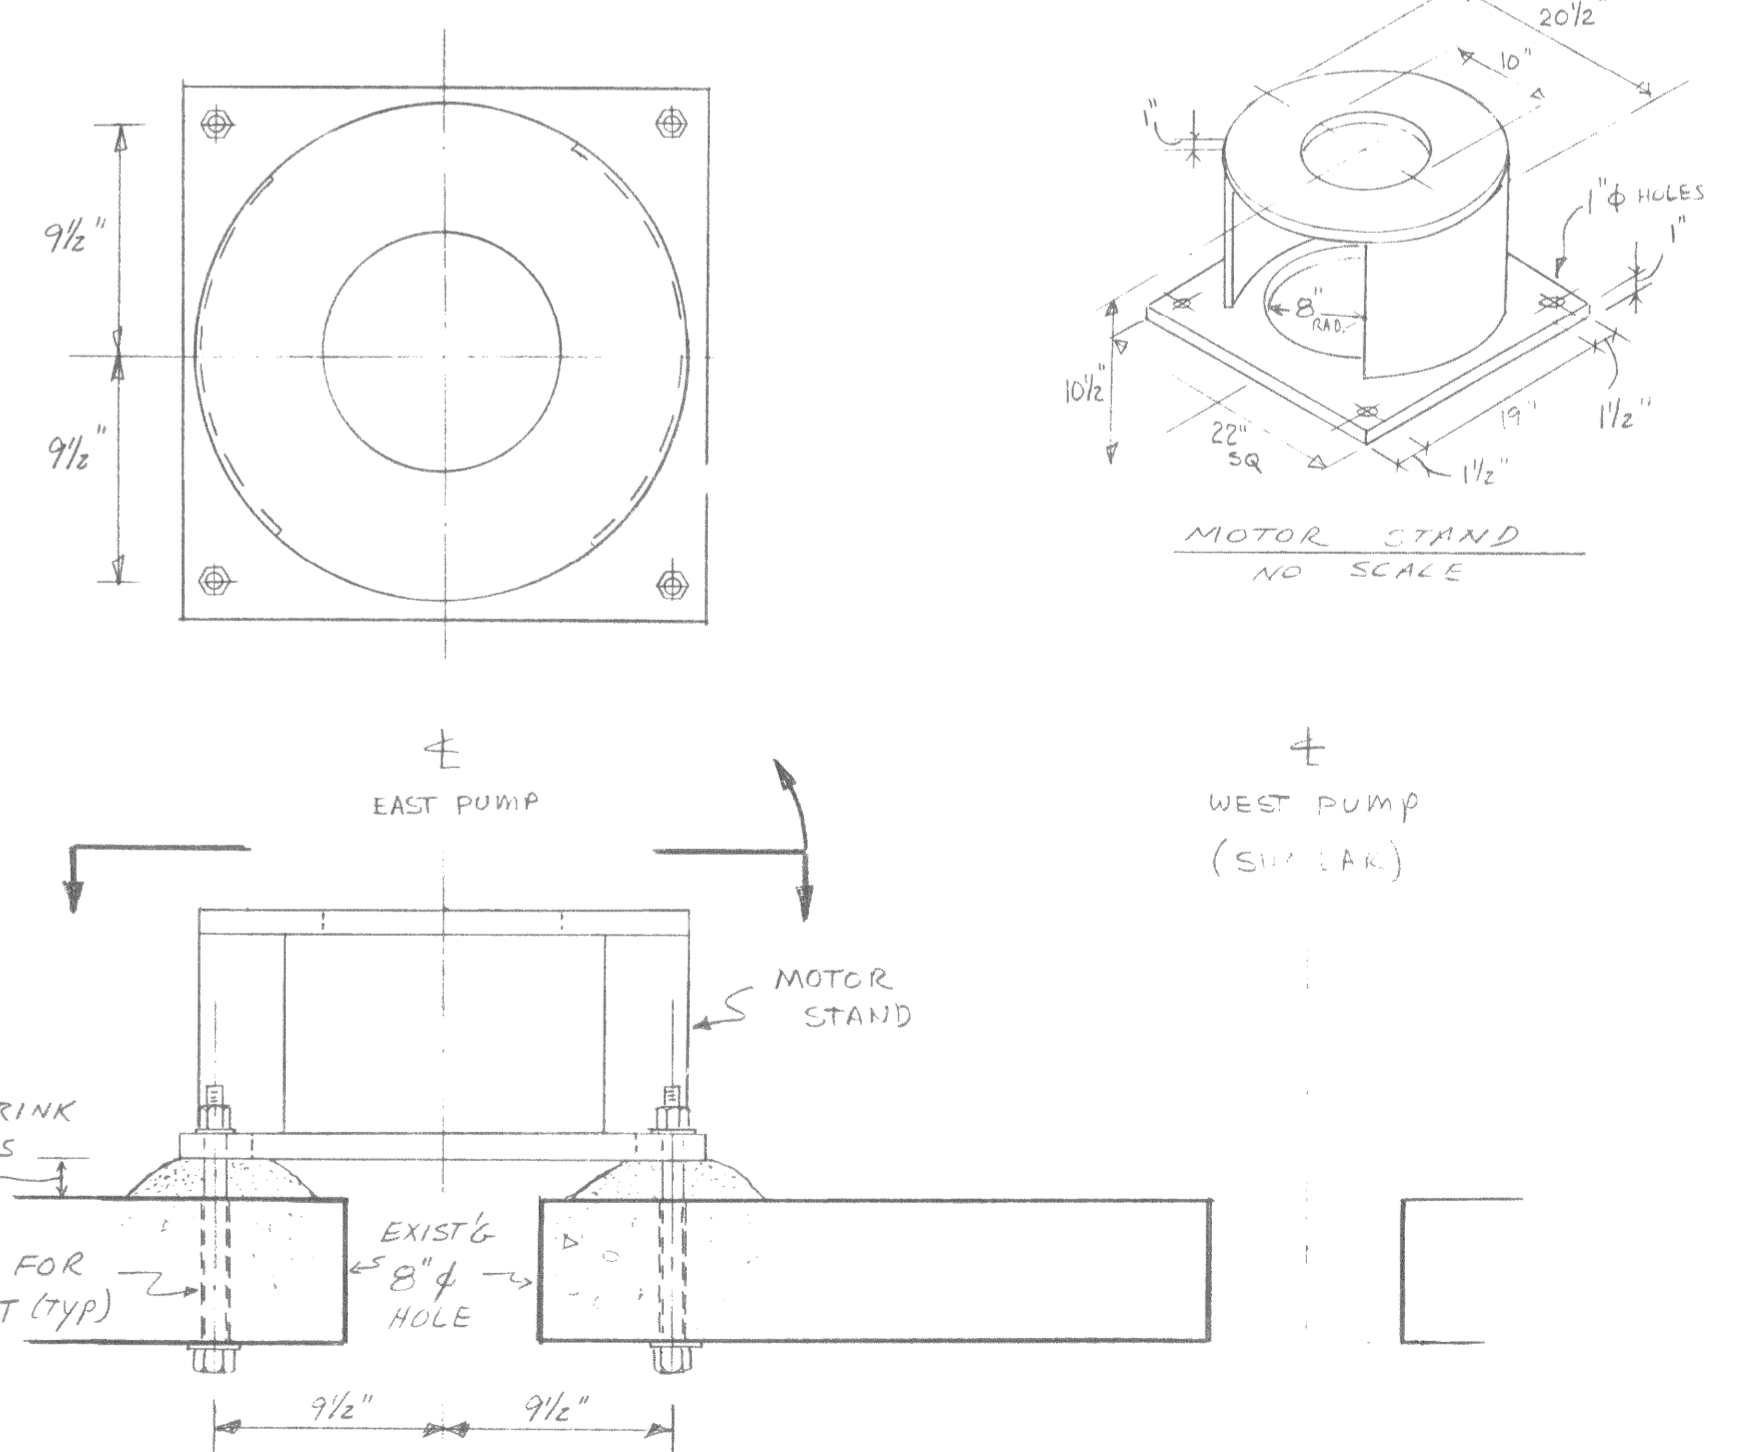





(P) MOTOR MOUNT DETAIL
1 1/2" = 1'-0"

COOK ASSOCIATES
 ENGINEERING CONSULTANTS
 2050 PARK AVENUE, OROVILLE, CALIFORNIA 95965
 CITY OF OROVILLE
 OLIVE GLEN LIFT STATION
 MISCELLANEOUS DETAILS



REVISION	DATE

DRAWN: JBYL
 DATE: JULY 51
 APPROVED: JBYL
 DATE: AUG 81
 FILE NO: A-450
 SHEET NO: 6
 OF 11 SHTS
 JOB NO: 80405

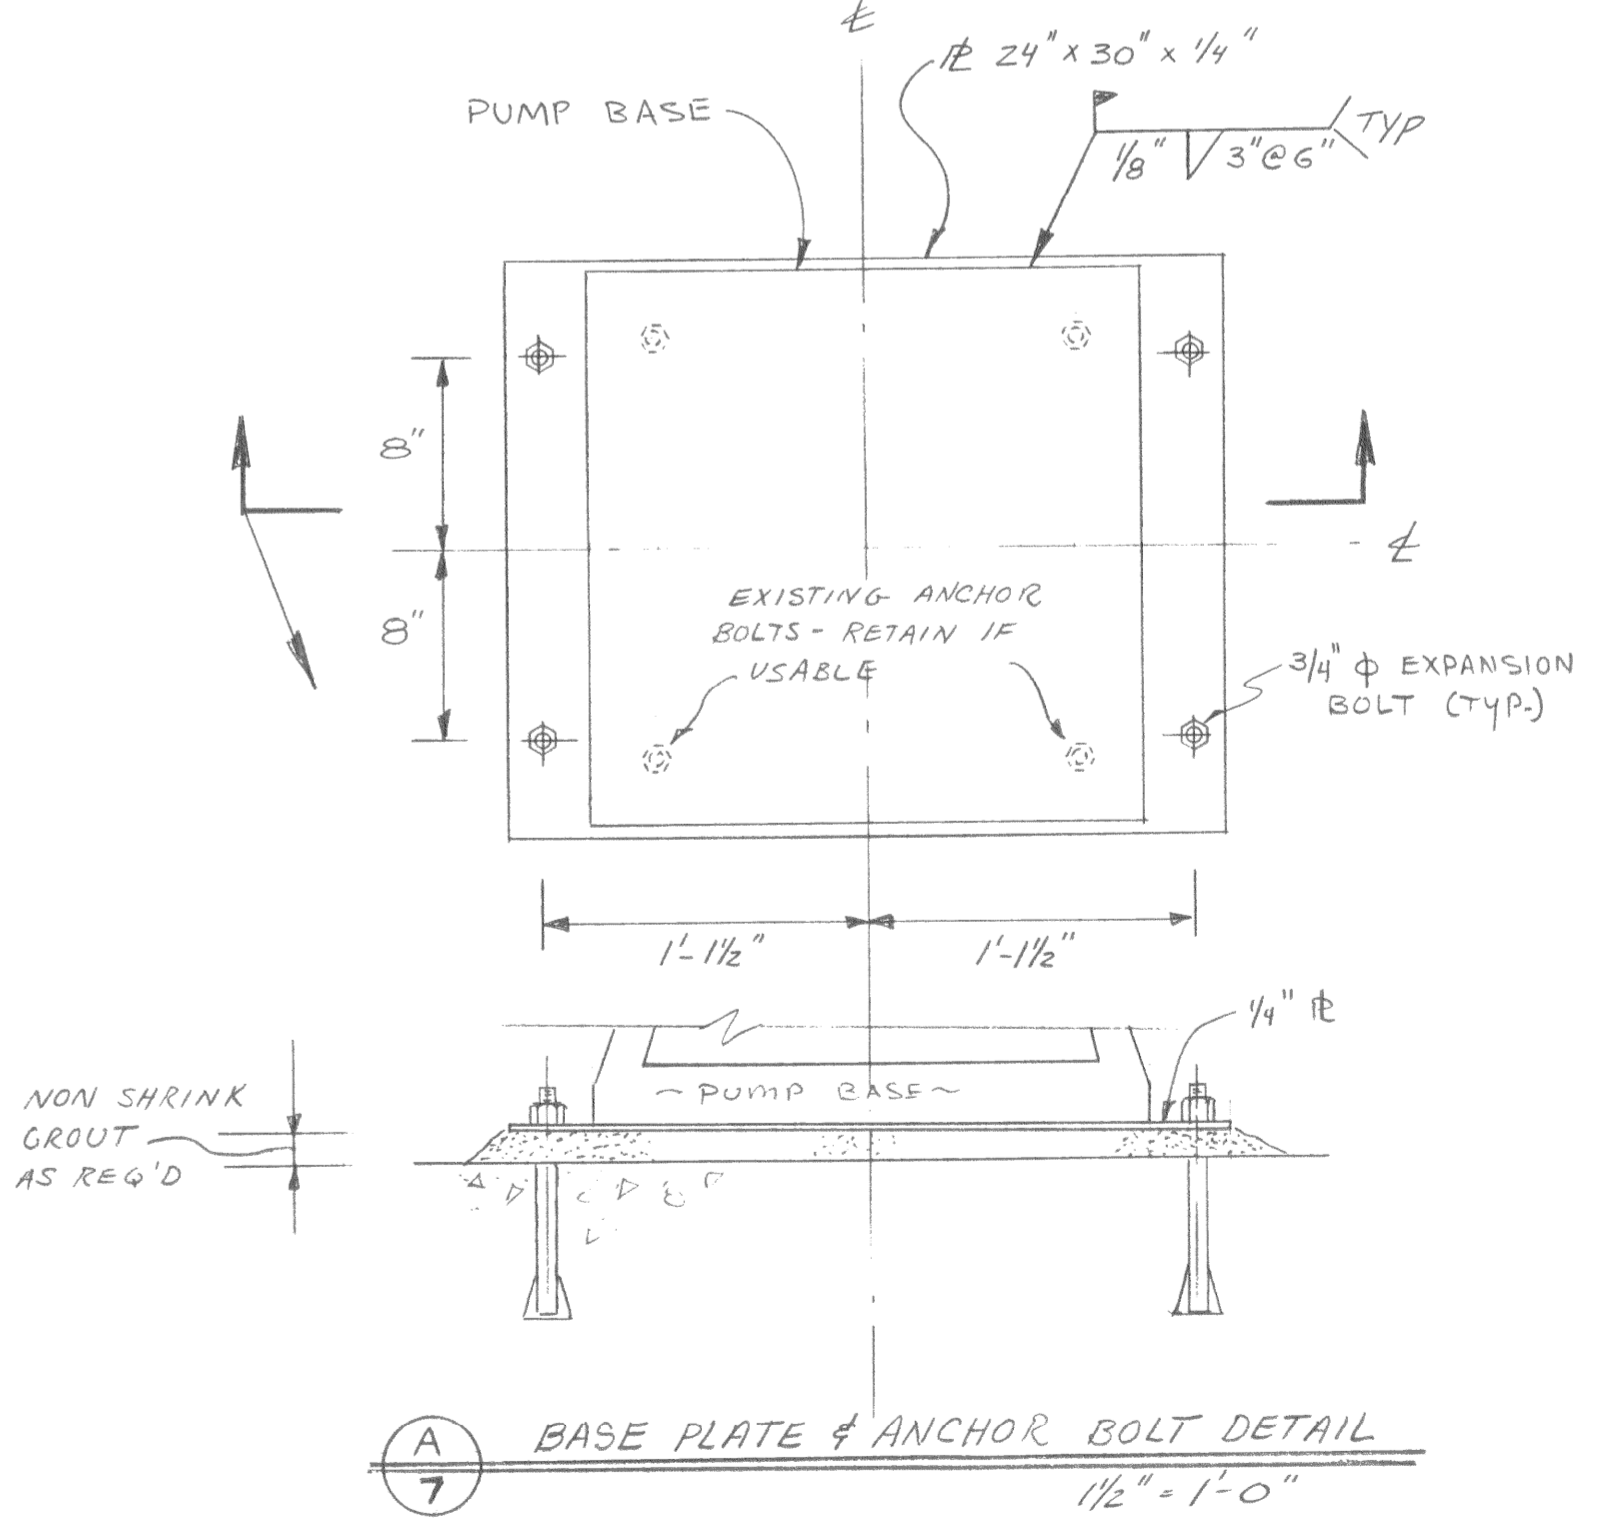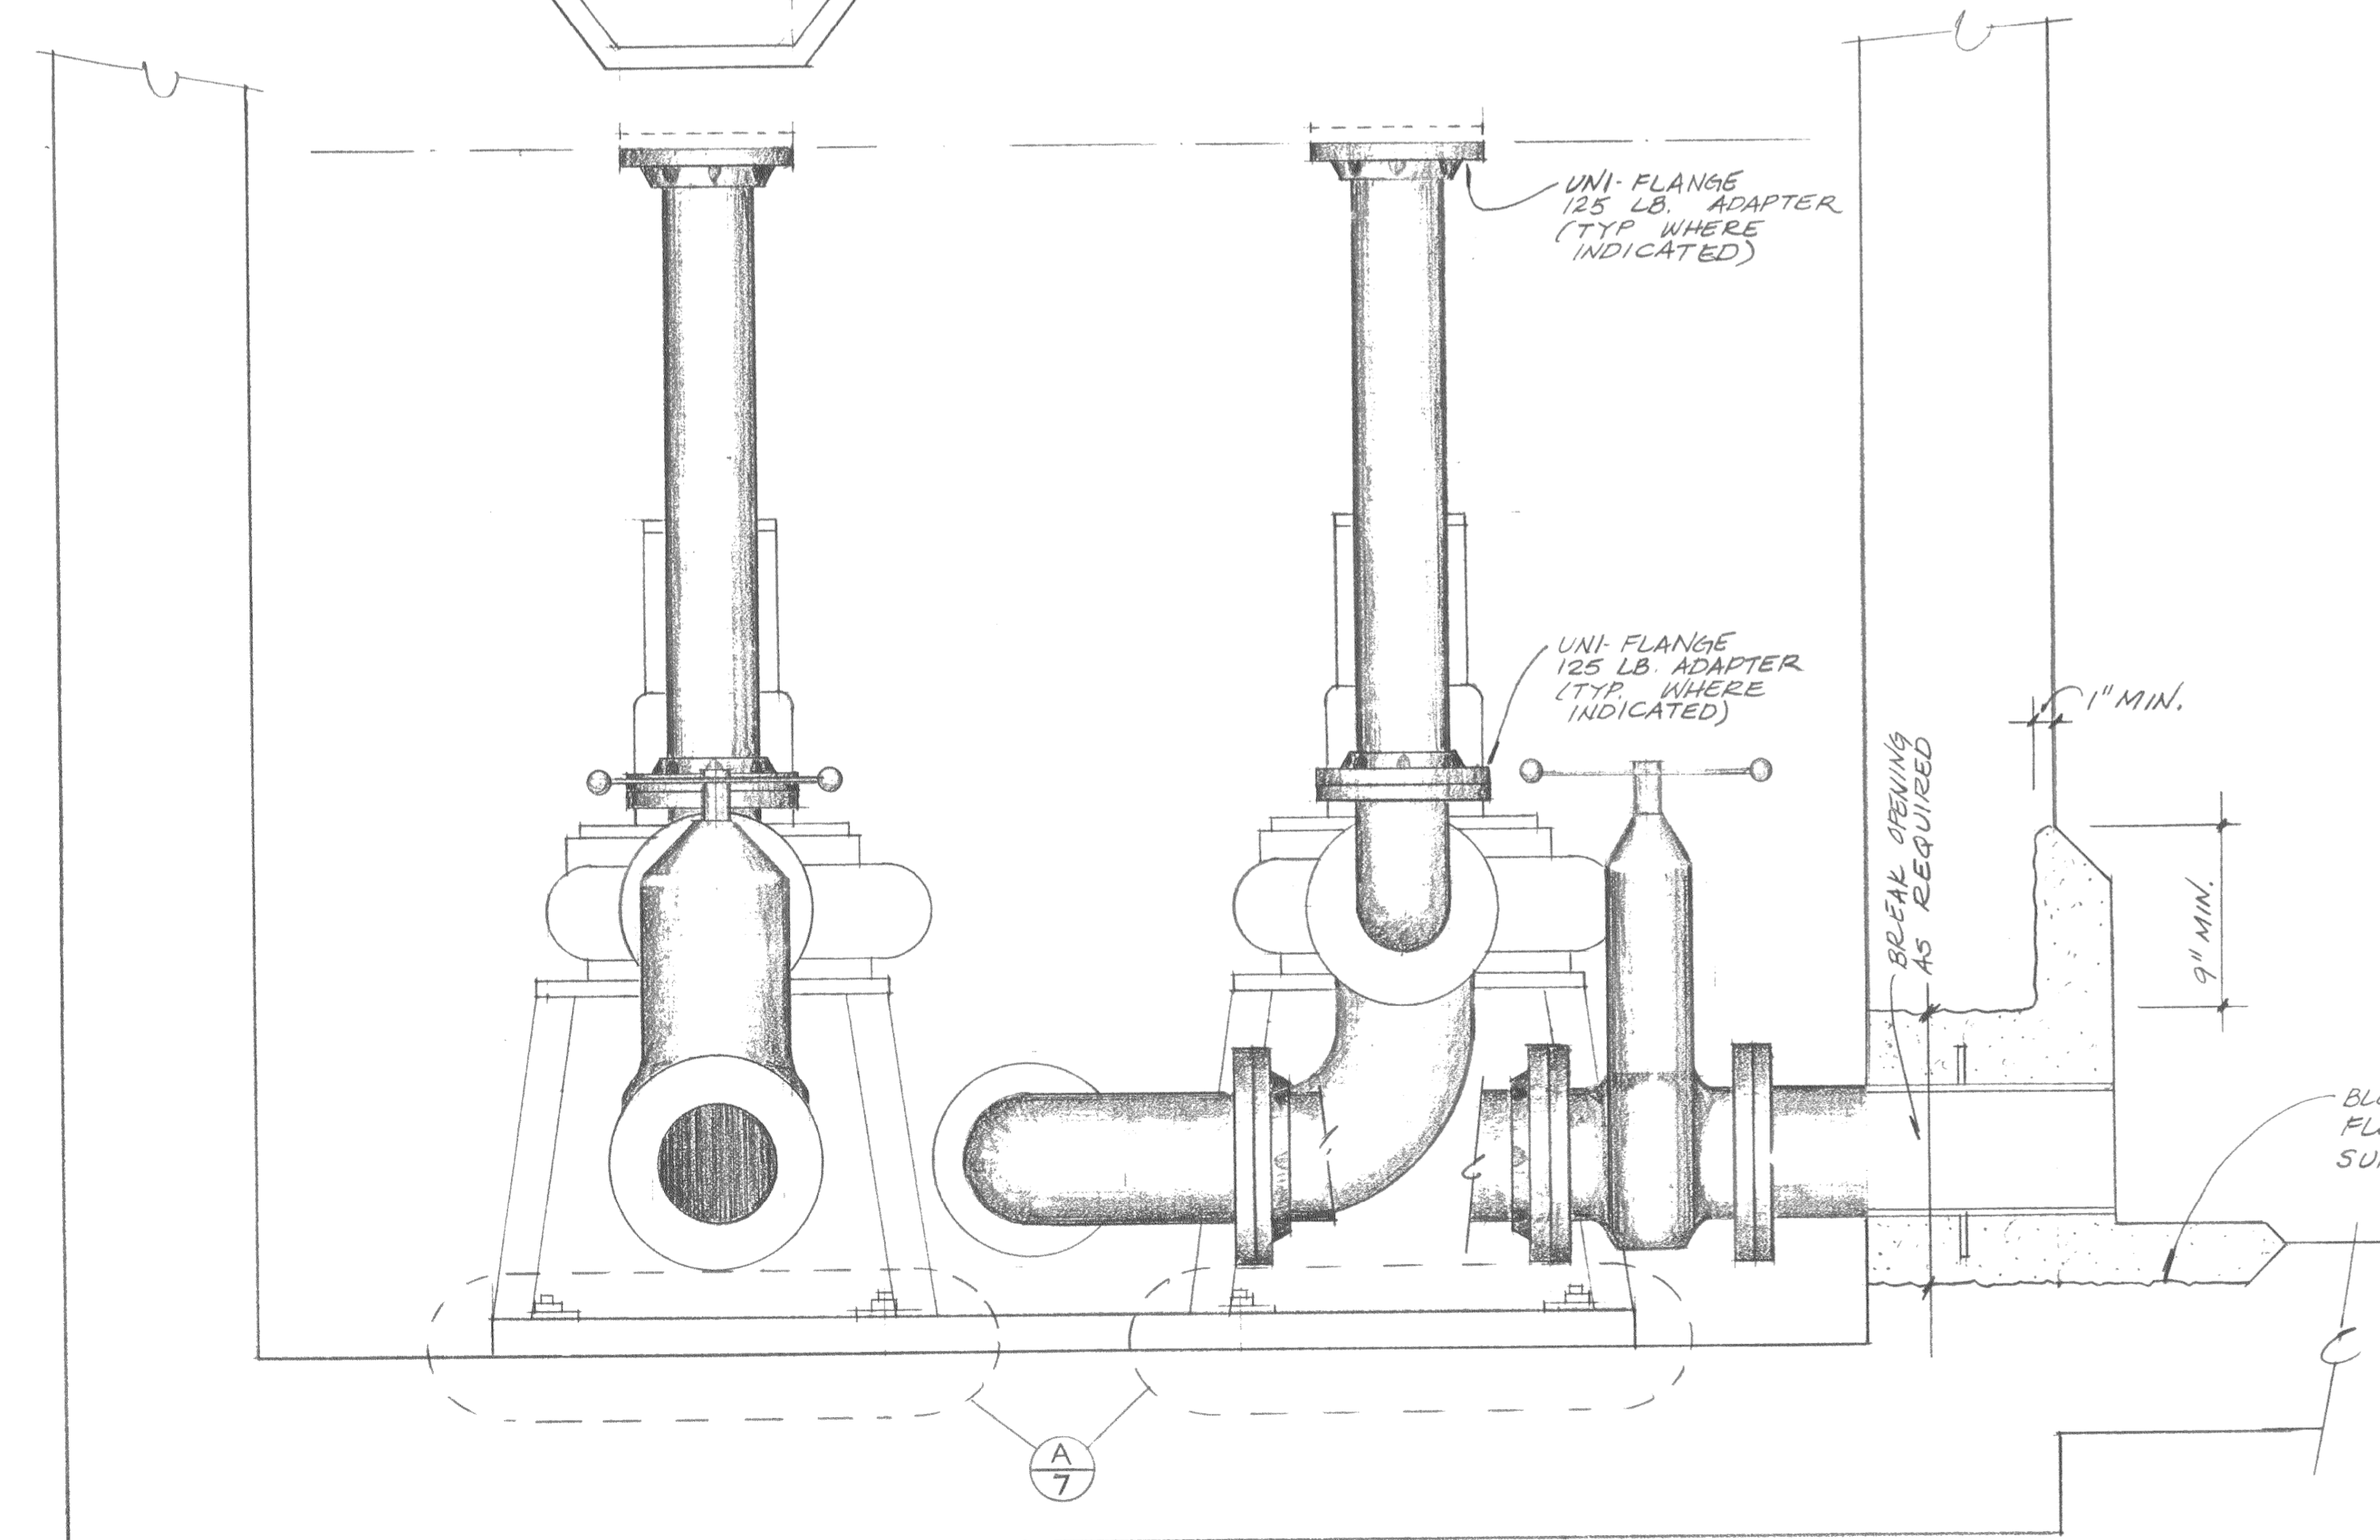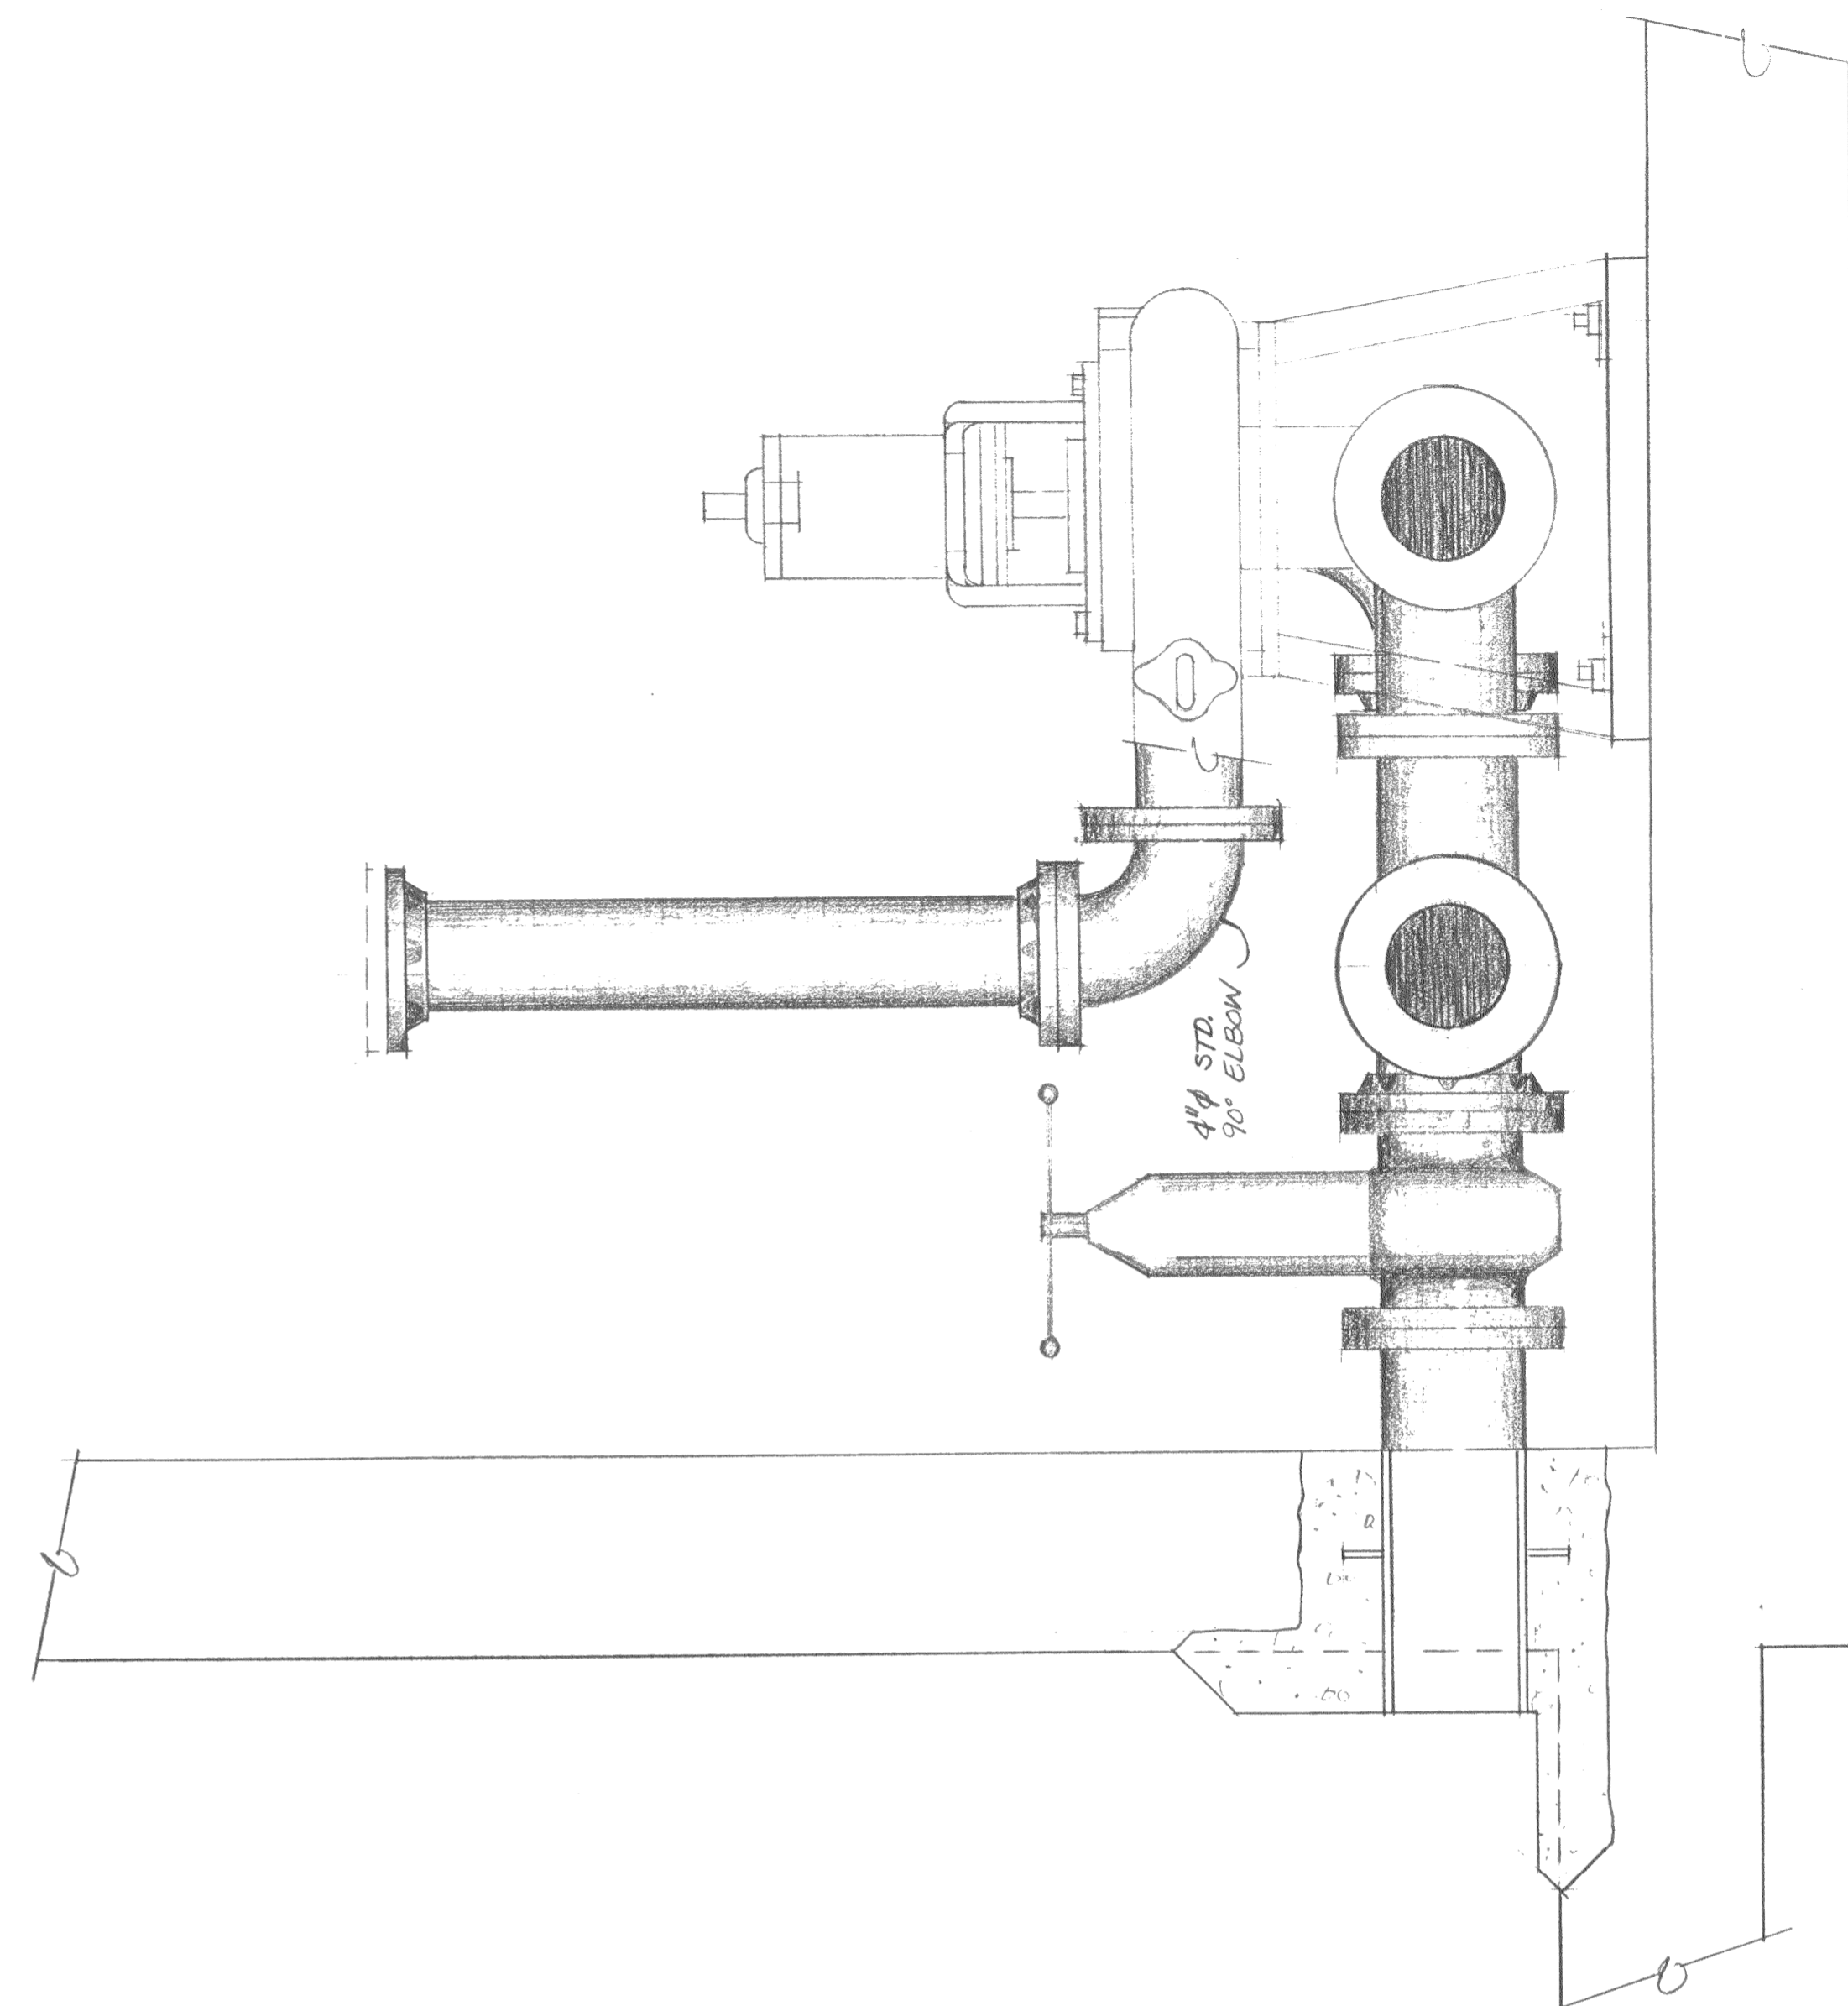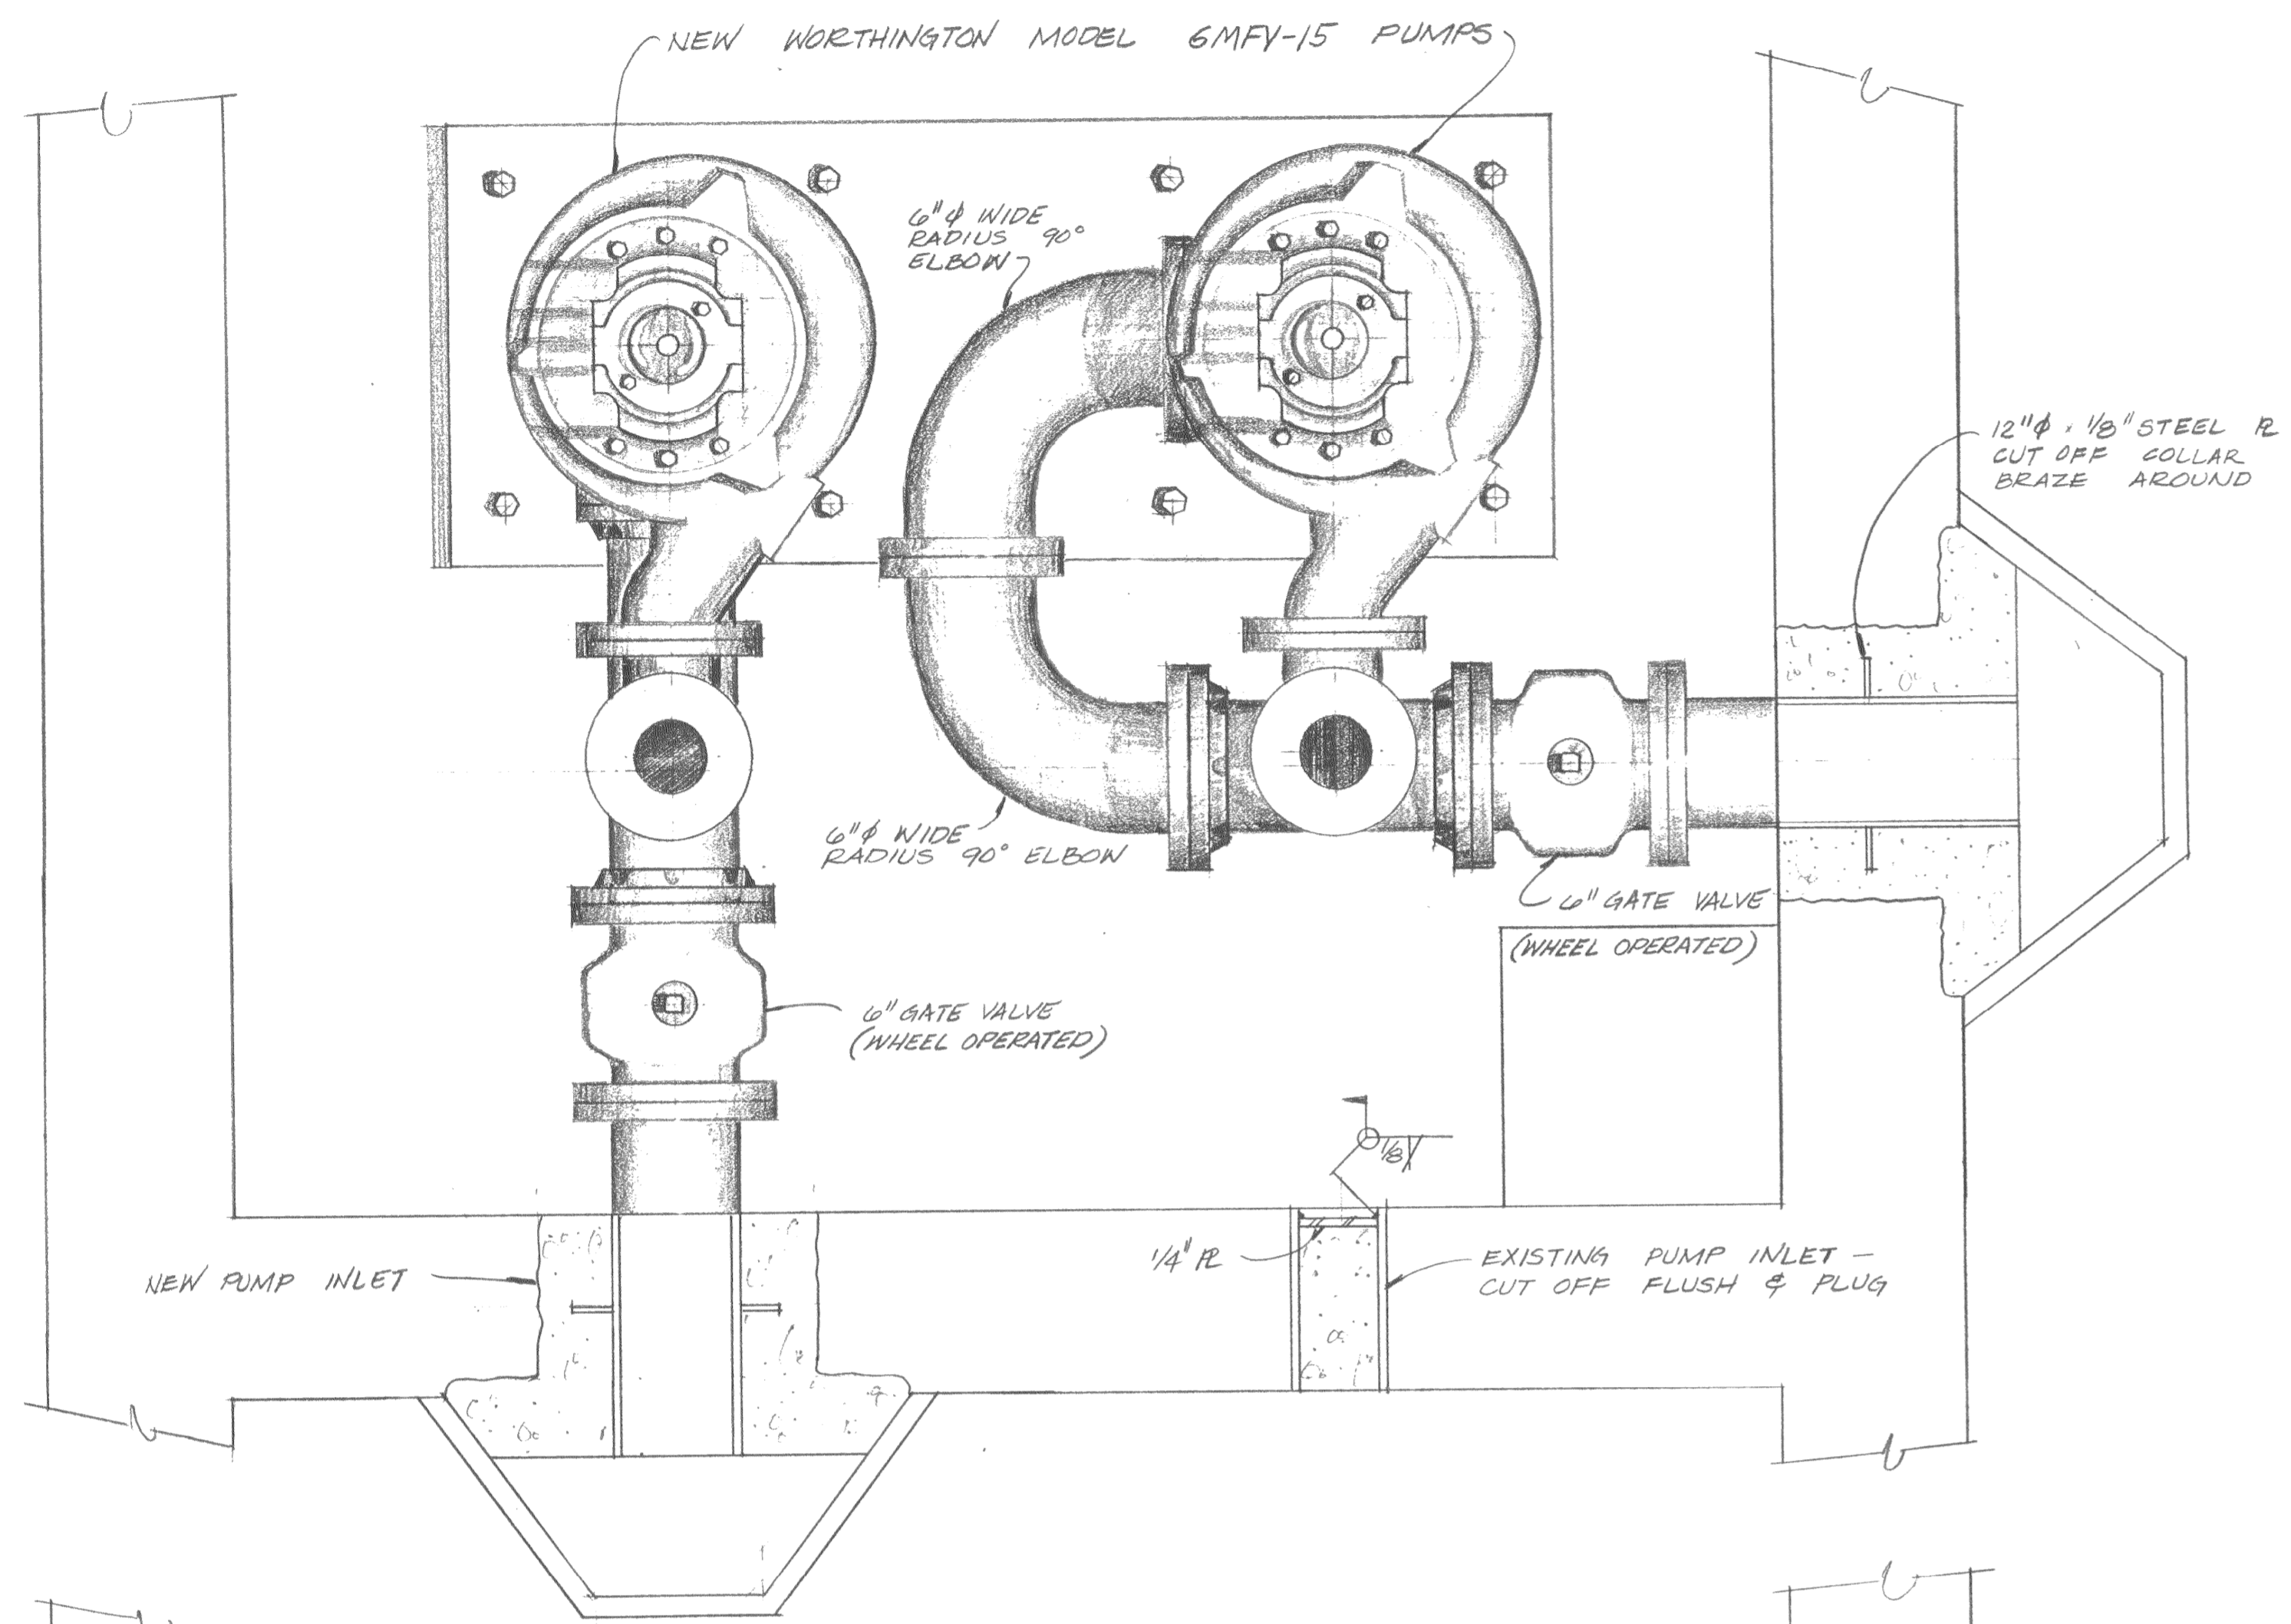



COOK ASSOCIATES
ENGINEERING CONSULTANTS
 2060 PARK AVENUE, OROVILLE, CALIFORNIA 95965

CITY OF OROVILLE
 OLIVE GLEN LIFT STATION
 PUMP & PIPING ARRANGEMENT

REGISTERED PROFESSIONAL ENGINEER
 James Cook
 13062
 Civil Engineer
 STATE OF CALIFORNIA

REVISION	DATE

JOYCE JULY 81
 DRAWN DATE
 JCK AUG 81
 APPROVED DATE
 A-452
 FILE NO.
 SHEET NO. **7**
 OF 11 SHTS
 JOB NO. 80745